


DOLLAR TREE
LINE DIAGRAM
(FOR REFERENCE ONLY NOT TO SCALE)

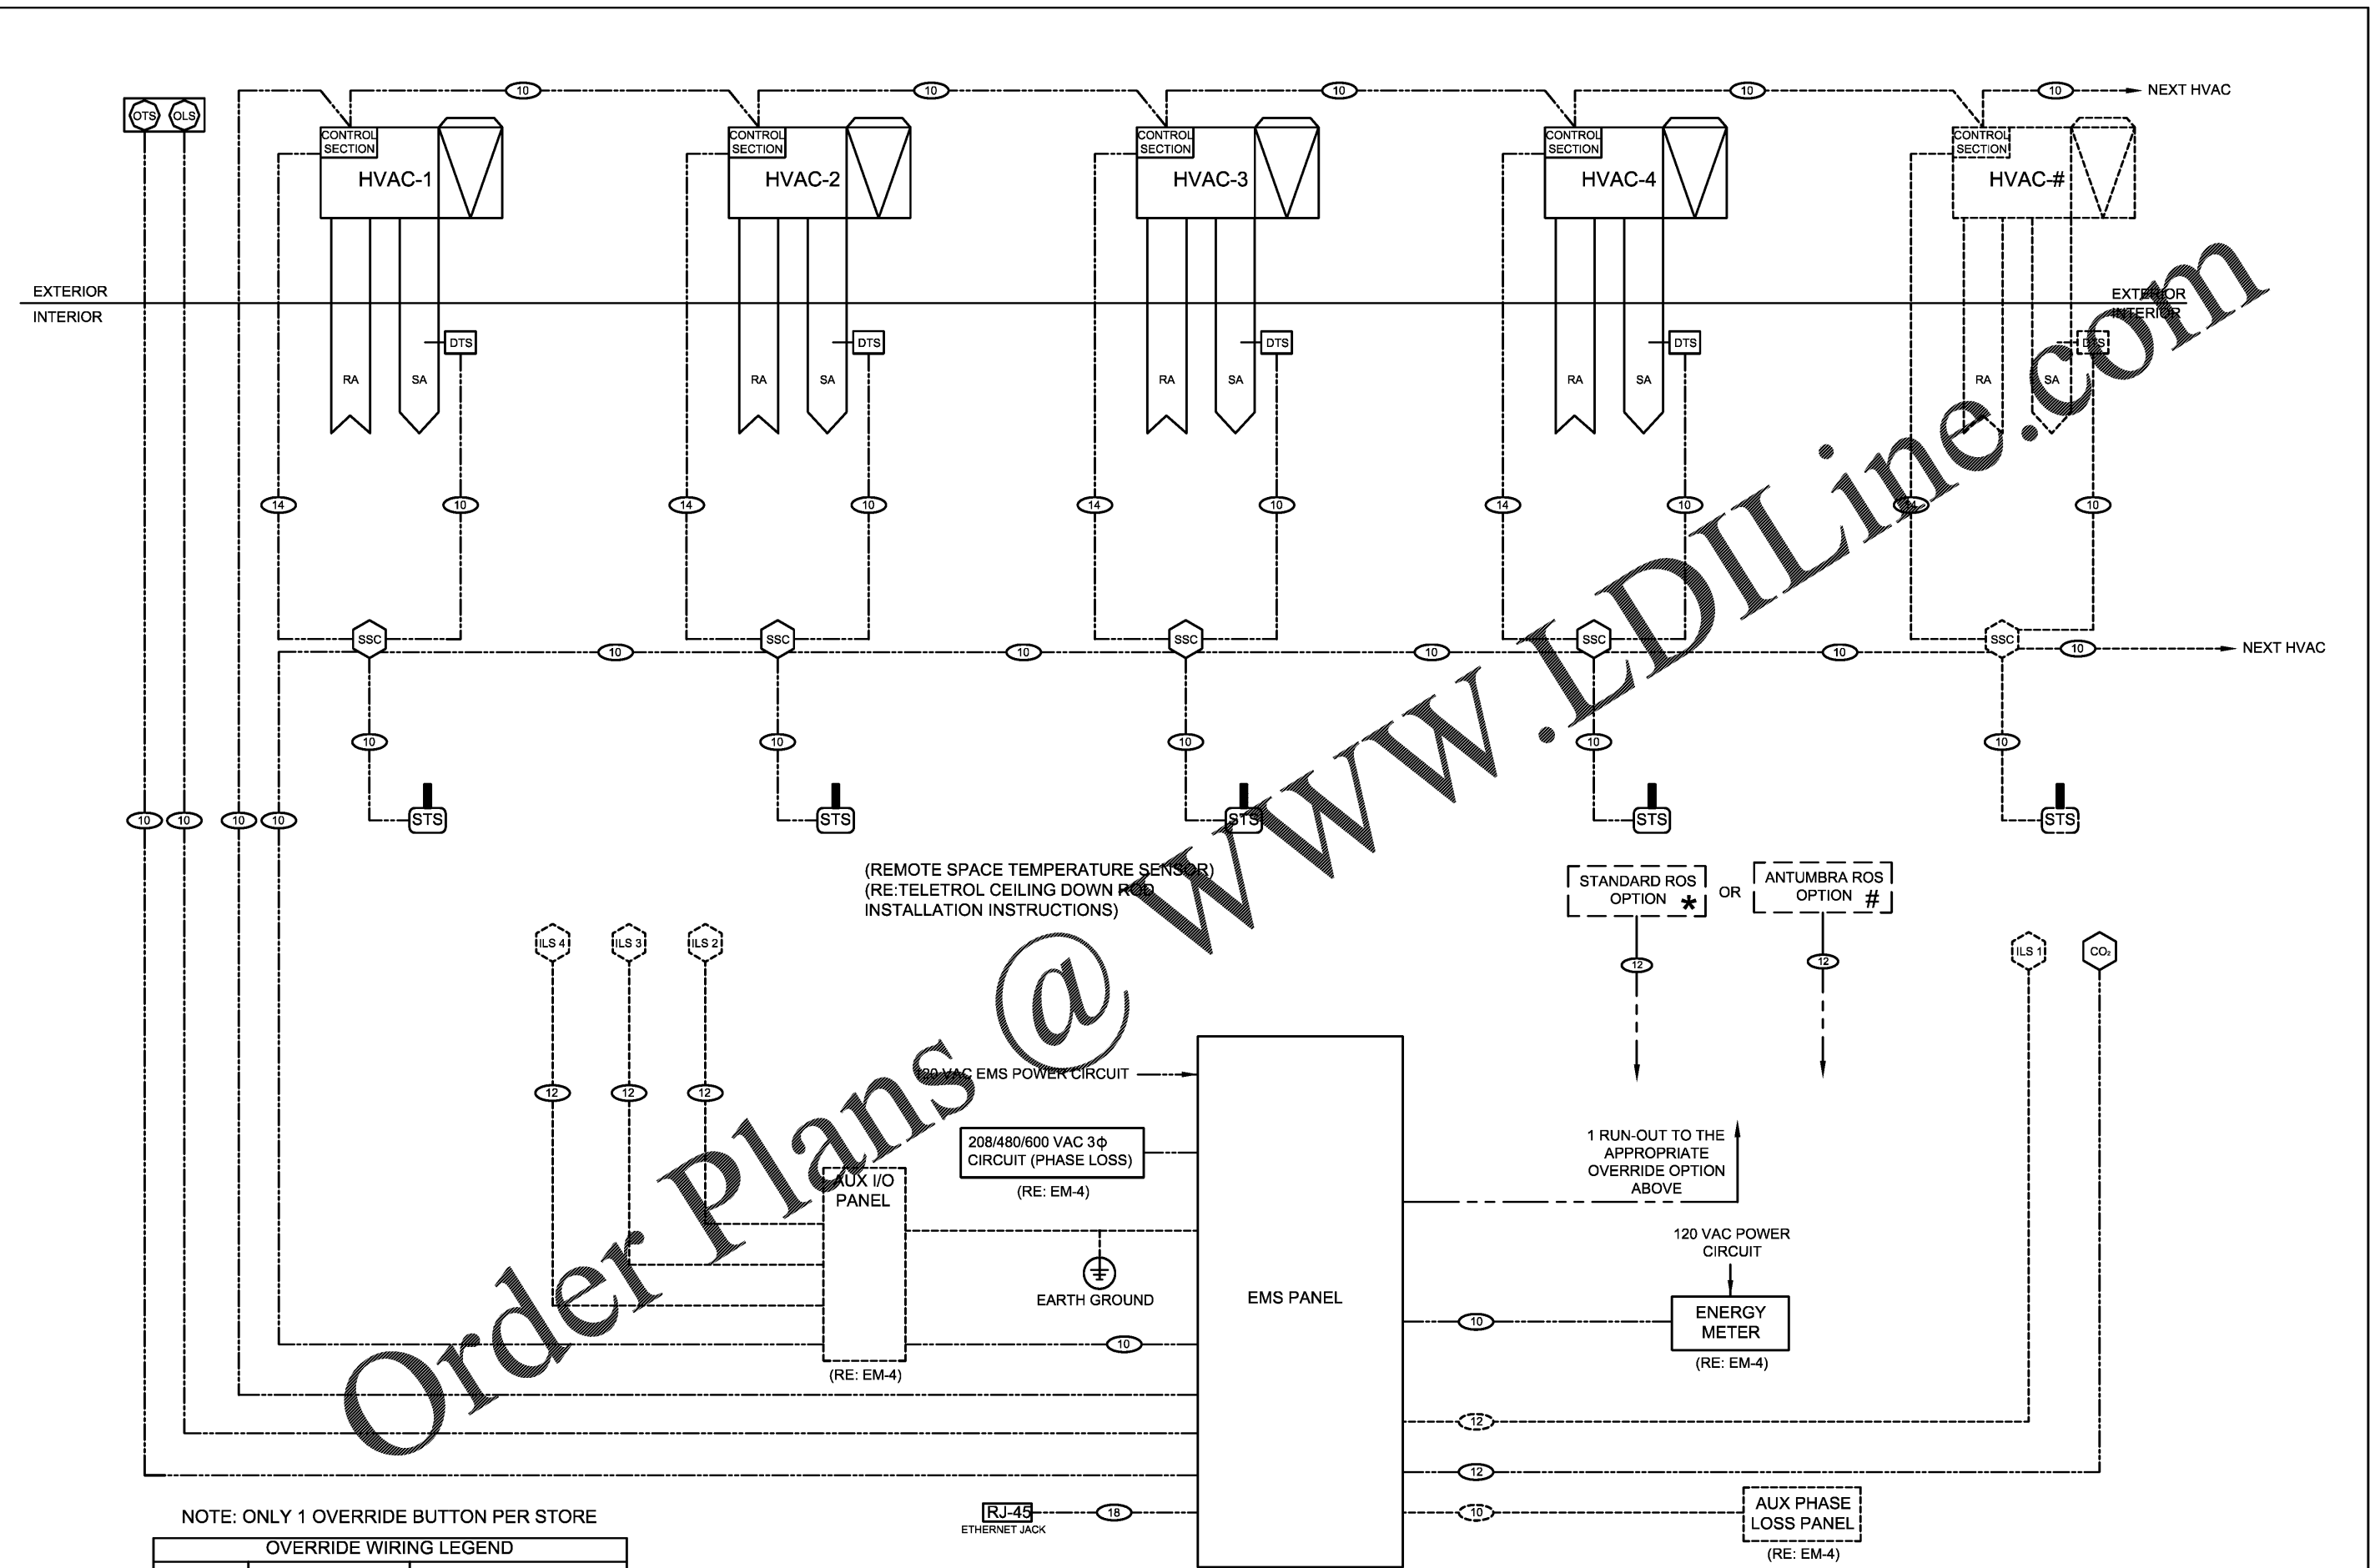

(REMOTE SPACE TEMPERATURE SENSOR)
(RE:TELETROL CEILING DOWN ROD
INSTALLATION INSTRUCTIONS)

STANDARD ROS OPTION * OR ANTUMBRA ROS OPTION #

1 RUN-OUT TO THE APPROPRIATE OVERRIDE OPTION ABOVE

120 VAC POWER CIRCUIT

ENERGY METER
(RE: EM-4)

AUX PHASE LOSS PANEL
(RE: EM-4)

(MOUNTED IN ELECTRICAL ROOM/AREA ADJACENT TO LIGHTING CIRCUIT PANELS) (RE: EM-3 EMS WIRING DETAIL)

ENERGY MANAGEMENT SYSTEM SINGLE LINE DIAGRAM
SCALE: None

NOTE: ONLY 1 OVERRIDE BUTTON PER STORE

OVERRIDE WIRING LEGEND		
DETAIL TAG	OVERRIDE TYPE	CONNECTION TO
*	TO BE USED WITH STANDARD OVERRIDE	ESC I/O TERMINALS
#	TO BE USED WITH ANTUMBRA OVERRIDE	OVERRIDE COMMUNICATION PORT

REVISION: 7	DATE: 07/10/18	ECN#: 2306
UPDATE TO CURRENT CYLON ADDRESS		
REVISION: 8	DATE: 09/27/18	ECN#: 2339
ADD METER		
REVISION: ---	DATE: ---	ECN#: ---
REVISION: ---	DATE: ---	ECN#: ---
REVISION: ---	DATE: ---	ECN#: ---
DRAWN: WPC	CHECKED: CGP	PART #: 94-339
		OPTION: P