

KEYNOTES

- INSTALL 1" GRC FOR TANK PROBE AND SENSOR FROM FRANKLIN FUEL MONITORING PANEL. ROUTE CONDUIT ALONG FUEL PIPING. REFER TO OIL DRAWING FOR MORE INFORMATION.



HARRISON FRENCH & ASSOCIATES, LTD

1705 S. Walton Blvd., Suite 3
 Bentonville, Arkansas 72712
 t 479.273.7780
 f 888.520.9685
 www.hfa-ae.com

STIPULATION FOR REUSE
 THIS DRAWING WAS PREPARED FOR THE
 PROJECT DESCRIBED HEREIN. IT IS THE
 PROPERTY OF HARRISON FRENCH & ASSOCIATES,
 LTD. AND IS NOT TO BE REPRODUCED OR
 TRANSMITTED IN ANY FORM OR BY ANY
 MEANS, ELECTRONIC OR MECHANICAL,
 INCLUDING PHOTOCOPYING, RECORDING,
 OR BY ANY INFORMATION STORAGE AND
 RETRIEVAL SYSTEM, WITHOUT THE WRITTEN
 PERMISSION OF HARRISON FRENCH & ASSOCIATES,
 LTD. ANY UNAUTHORIZED REUSE OR
 MODIFICATION OF THIS DRAWING IS
 EXPRESSLY PROHIBITED AND WILL BE
 CONSIDERED TO BE A VIOLATION OF THE
 PROFESSIONAL ENGINEERING AND ARCHITECTURAL
 STATUTES OF THE STATE OF ARKANSAS.

200 S KINGS HWY
 FORT PIERCE, FL 34945
 SPEEDCO REBRANDING &
 LIGHT MECHANICAL ADDITION
 PROJECT NUMBER: 03-19-0467




Nathan Connors, P.E.
 License No 81168
 Harrison French &
 Associates, LTD
 CCA-828421

ISSUE BLOCK	

STORE NO. 467
 DOCUMENT DATE: 05/14/19
 CHECKED BY: NKC
 DRAWN BY: CAR
 PROTO CYCLE:

SITE POWER PLAN

SHEET: YE5

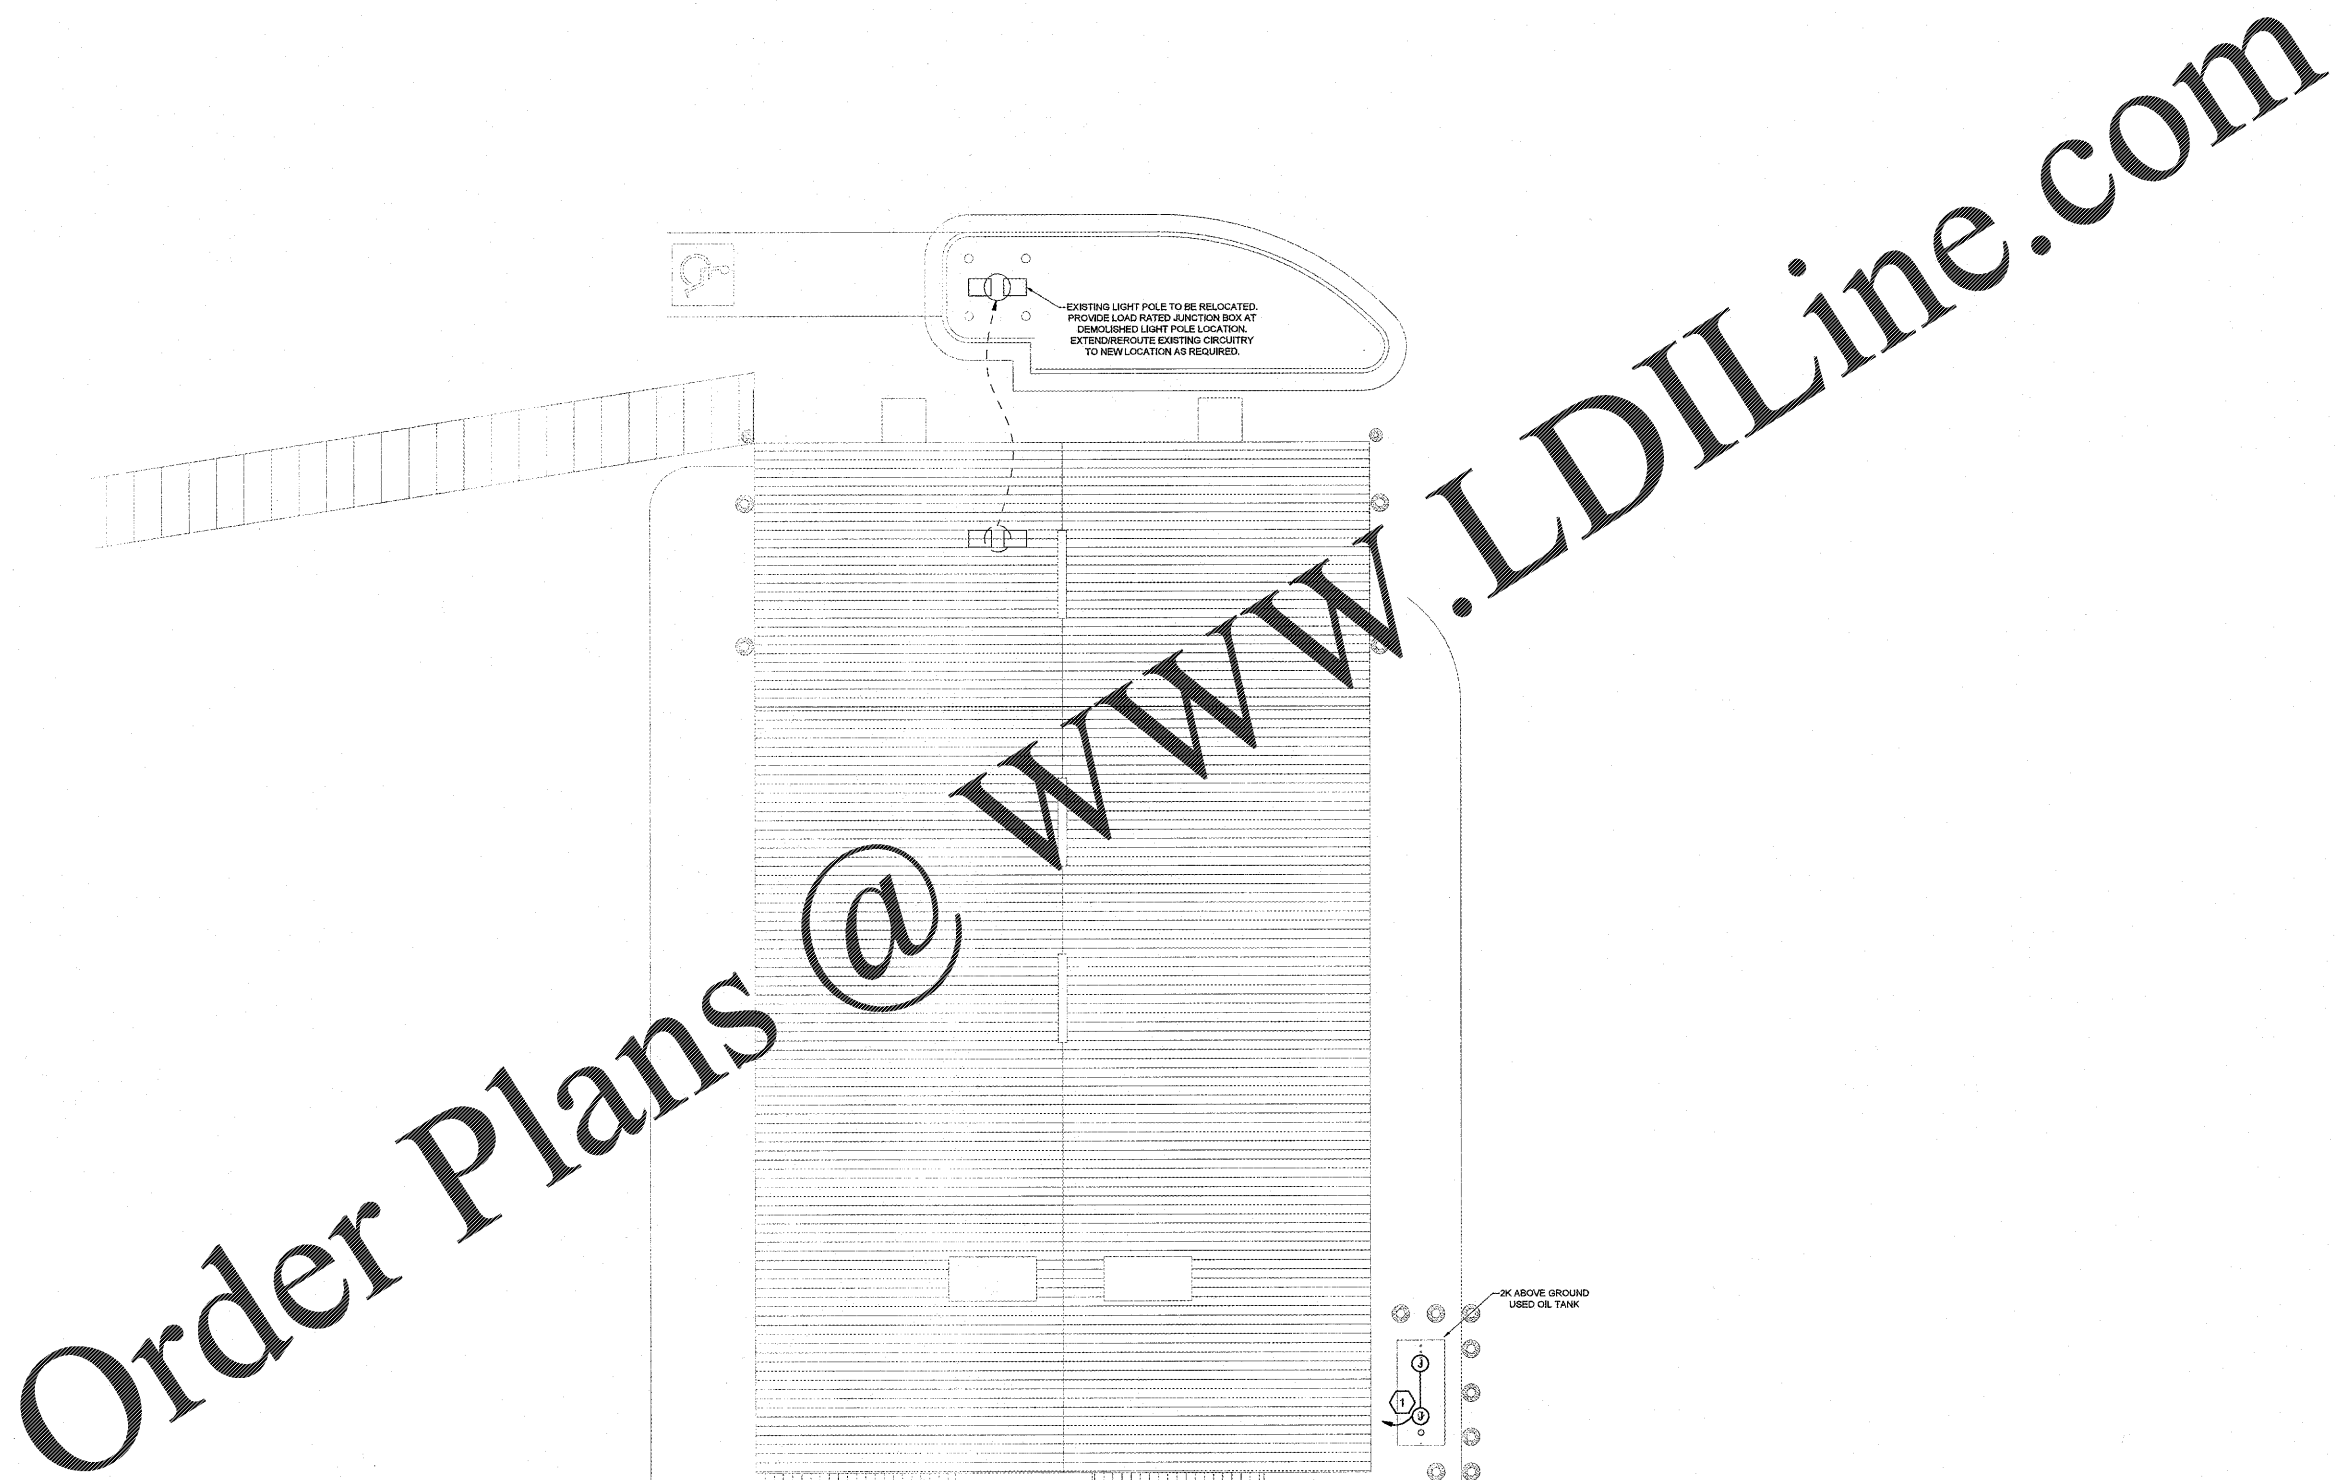

1 SITE POWER PLAN
 SCALE: 1"=10'-0"

EACH SUBCONTRACTOR IS RESPONSIBLE FOR HAVING A THOROUGH KNOWLEDGE OF ALL DRAWINGS AND SPECIFICATIONS IN THEIR RELATED FIELD. THE FAILURE TO ACQUAINT HIMSELF WITH THIS KNOWLEDGE DOES NOT RELIEVE THE RESPONSIBILITY OF PERFORMING HIS WORK PROPERLY. NO ADDITIONAL COMPENSATION SHALL BE ALLOWED BECAUSE OF CONDITIONS THAT OCCUR DUE TO FAILURE TO FAMILIARIZE WORKERS WITH THIS KNOWLEDGE.

Order Plans @ www.LDILine.com