

LIGHTING FIXTURE SCHEDULE - "L"						
DESIGN ID	COUNT	DESCRIPTION	FURN. BY	INST. BY	BULB	COMMENTS
OTHER						
X1002	2	CUSTOM FLOOR LAMP - CAFE	SB	GC		BLU DOT; PERIMETER FLOOR LAMP - OLIVE (PE1-FLROLV-OL)
SCONCE						
X1001	3	CUSTOM WALL SCONCE - CAFE	SB	GC		LITESITE SKU: 633385
X1003	2	CUSTOM WALL SCONCE - RESTROOM	SB	GC		LITESITE SKU: 459845
STRIP						
14410	3	STRIP - LED TAPE - VARIABLE LENGTH	SB	GC	INTEGRATED LED	FIELD TRIMMABLE TO 6IN LENGTHS
X0060	1	LED STRIP TAPE DRIVER - 20ft	SB	GC		JUNO DLDP5-60W-FPCZT OR APPROVED EQUAL
X0096	1	LED STRIP TAPE DRIVER - 32ft	SB	GC		JUNO DLDP5-96W-FPCZT OR APPROVED EQUAL
TRACK						
12934	2	TRACK - WITH CONNECTORS - 4FT 122CM - WHITE - 1 CIRCUIT	SB	GC		
12935	6	TRACK - WITH CONNECTORS - 8FT 244CM - WHITE - 1 CIRCUIT	SB	GC		
12945	5	TRACK - WITH CONNECTORS - 12FT 365CM - WHITE - 1 CIRCUIT	SB	GC		
15059	1	TRACK - WITH CONNECTORS - 6FT 183CM - WHITE - 1 CIRCUIT	SB	GC		
19073	12	TRACK - LED FIXTURE - 2IN 50MM - WHITE - 750LM NFL	SB	GC	INTEGRATED LED	
19074	14	TRACK - LED FIXTURE - 2IN 50MM - WHITE - 900LM FLOOD	SB	GC	INTEGRATED LED	
19075	11	TRACK - LED FIXTURE - 2IN 50MM - WHITE - 600LM WF	SB	GC	INTEGRATED LED	
19076	21	TRACK - LED FIXTURE - 2IN 50MM - WHITE - 750LM WF	SB	GC	INTEGRATED LED	
X0240	2	2 AMP CURRENT LIMITER	SB	GC		JUNO TCL2 OR EQUAL
X0360	1	3 AMP CURRENT LIMITER	SB	GC		JUNO TCL3 OR EQUAL

**KEYED NOTES**

- EXISTING TO REMAIN (ETR).

**GENERAL NOTES**


- IF REQUIRED BY LOCAL CODE, GENERAL CONTRACTOR TO PROVIDE SEMI-RECESSED SPRINKLER HEADS WITH POLISHED CHROME ESCUTCHEONS CENTERED IN ACOUSTICAL CEILING TILE. IF PENDANT HEADS ARE REQUIRED IN GWB SOFFIT OVER FRONTBAR, CONCEAL SUPPLY PIPING WITHIN SOFFIT. GENERAL CONTRACTOR TO SUBMIT SPRINKLER LAYOUT TO STARBUCKS' CONSTRUCTION MANAGER FOR APPROVAL PRIOR TO INSTALLATION.
- LEAVE TEN (10) ADDITIONAL RETAIL CEILING TILES TO MATCH RETAIL CEILING PAINT COLOR ABOVE THE WORKROOM CEILING AT MANAGER'S DESK FOR FUTURE USE.
- PROVIDE GROMMET AT ACOUSTIC CEILING PENETRATIONS FOR FIXTURES OF SUPPORTS.
- HEATING, VENTILATING AND AIR CONDITIONING SHOWN ON THIS PLAN PROVIDED FOR REFERENCE ONLY. SEE MECHANICAL DRAWINGS FOR ADDITIONAL INFORMATION.
- DIFFUSERS AND FITTINGS IN ACOUSTICAL CEILING TILE TO BE CENTERED IN TILE AND PAINTED TO MATCH ADJACENT FINISHES (TYP).
- PAINT ALL EXPOSED HVAC DUCTS, HVAC DIFFUSERS, LIGHT TRIM RINGS, PIPING, CONDUIT AND JUNCTION BOXES THE SAME COLOR AS SPECIFIED ON SURROUNDING CEILING OR SOFFIT UNLESS OTHERWISE NOTED. TYPICAL THROUGHOUT RETAIL AREA OF STORE.
- PAINT SUBSTITUTIONS ARE NOT ALLOWED. USE STARBUCKS' NATIONAL ACCOUNT "COLOR CODE" WHEN ORDERING PAINTS.



**STARBUCKS COFFEE COMPANY**  
 2401 UTAH AVENUE SOUTH  
 SEATTLE, WASHINGTON 98134  
 (206) 318-1575


THESE DRAWINGS AND SPECIFICATIONS ARE CONFIDENTIAL AND SHALL REMAIN THE SOLE PROPERTY OF STARBUCKS CORPORATION, WHICH IS THE OWNER OF THE COPYRIGHT IN THIS WORK. THEY SHALL NOT BE REPRODUCED IN WHOLE OR IN PART, SHARED WITH THIRD PARTIES OR USED IN ANY MANNER ON OTHER PROJECTS OR EXTENSIONS TO THIS PROJECT WITHOUT THE PRIOR WRITTEN CONSENT OF STARBUCKS CORPORATION. THESE DRAWINGS AND SPECIFICATIONS ARE INTENDED TO EXPRESS DESIGN INTENT FOR A PROTOTYPICAL STARBUCKS STORE (WHICH IS SUBJECT TO CHANGE AT ANYTIME) AND DO NOT REFLECT ACTUAL SITE CONDITIONS. NEITHER PARTY SHALL HAVE ANY OBLIGATION NOR LIABILITY TO THE OTHER (EXCEPT AS STATED ABOVE) UNTIL A WRITTEN AGREEMENT IS FULLY EXECUTED BY BOTH PARTIES.

STARBUCKS TEMPLATE VERSION (2018.10.16)

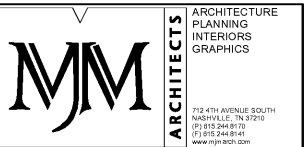

**LIGHTING LEGEND**

- ▲ TRACK HEAD, WHITE, NFL, 750 LM DID# 19073
- ▲ TRACK HEAD, WHITE, FLOOD, 900 LM DID# 19074
- TRACK HEAD, WHITE, WF, 600 LM DID# 19075
- TRACK HEAD, WHITE, WF, 750 LM DID# 19076
- EXISTING RECESSED CAN LIGHT TO REMAIN
- EXISTING, RELOCATED CAN LIGHT

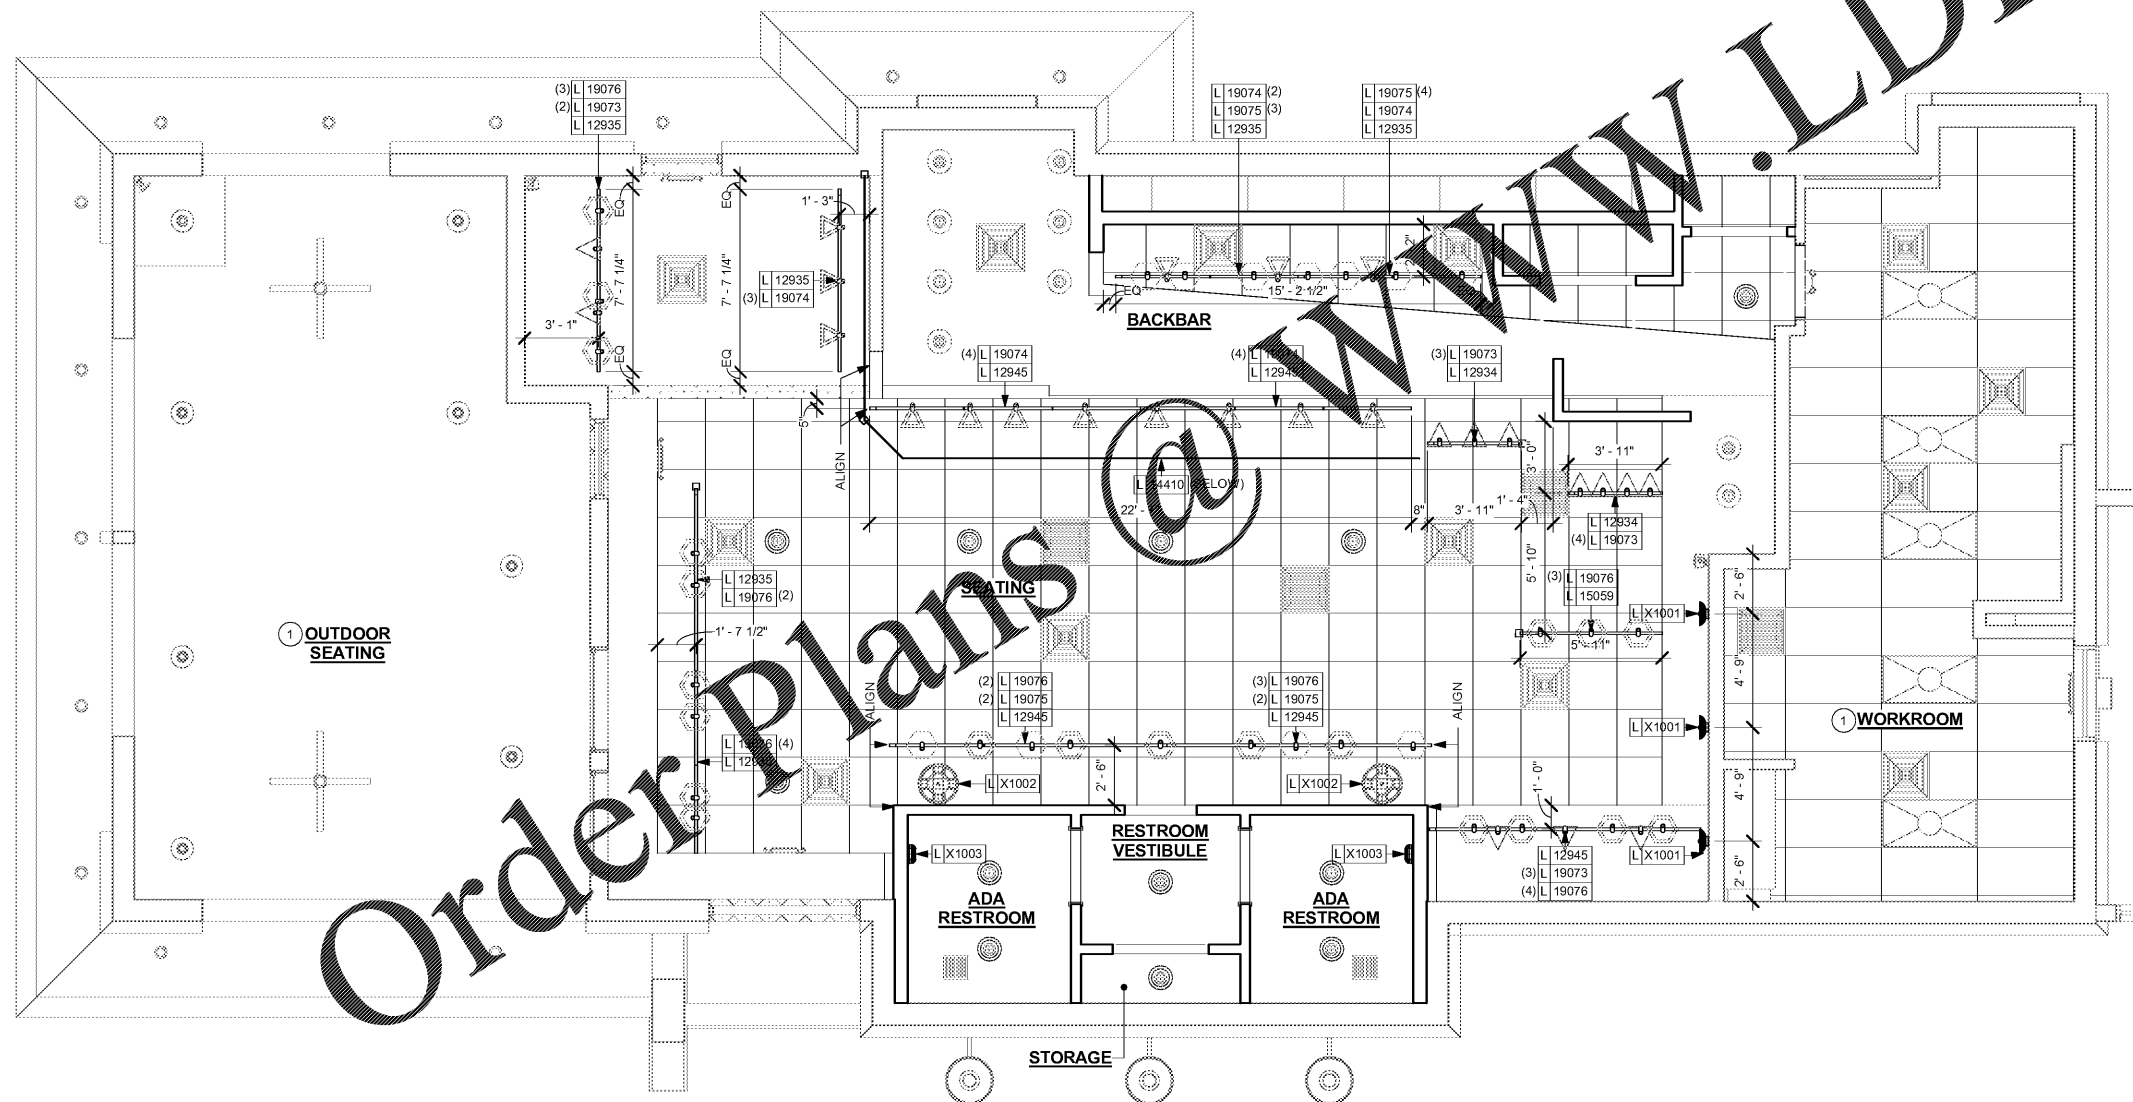

**1 LIGHTING DIMENSION PLAN**

Scale: 1/4" = 1'-0"

PROJECT NAME:  
**CUSICK & ALCOA**

PROJECT ADDRESS:  
121 CUSICK ROAD  
ALCOA, TN 37701  
BLOUNT COUNTY

STORE #:	11293
PROJECT #:	36099-035
ISSUE DATE:	04.26.19
DESIGN MANAGER:	L. MACEDA
LEED® AP:	N/A
PRODUCTION DESIGNER:	C. POBST
CHECKED BY:	MJM

REVISION SCHEDULE			
REV	DATE	BY	DESCRIPTION

SHEET TITLE:  
**LIGHTING DIMENSION PLAN**

SCALE: AS SHOWN

SHEET NUMBER:  
**1104**