

## LIGHTING FIXTURE SCHEDULE

DESIGN ID	COUNT	DESCRIPTION	FURN. BY	INST. BY	VOLTAGE	LOAD	BULB	COMMENTS
OTHER								
X1002	2	CUSTOM FLOOR LAMP - CAFE	SB	GC	120 V	22 VA		BLU DOT: PERIMETER FLOOR LAMP - OLIVE (PE1-FLROLV-OL)
SCONCE								
X1001	3	CUSTOM WALL SCONCE - CAFE	SB	GC	120 V	8 VA		LITESITE SKU: 633385
X1003	2	CUSTOM WALL SCONCE - RESTROOM	SB	GC	120 V	6 VA		LITESITE SKU: 459845
STRIP								
14410	3	STRIP - LED TAPE - VARIABLE LENGTH	SB	GC	120 V	5 VA	INTEGRATED LED	FIELD TRIMMABLE TO 6" LENGTHS - (1) 10'-0"; (1) 2'-4"; (1) 21'-6" TOTAL LENGTH: 33'-10"
X0060	1	LED STRIP TAPE DRIVER - 20ft	SB	GC	120 V	60 VA		JUNO DLDPS-60W-FPCZT OR APPROVED EQUAL
X0096	1	LED STRIP TAPE DRIVER - 32ft	SB	GC	120 V	96 VA		JUNO DLDPS-96W-FPCZT OR APPROVED EQUAL
TRACK								
12934	2	TRACK - WITH CONNECTORS - 4 FT - WHITE - 1 CIRCUIT	SB	GC	120 V	0 VA		
12935	6	TRACK - WITH CONNECTORS - 8 FT - WHITE - 1 CIRCUIT	SB	GC	120 V	0 VA		
12945	5	TRACK - WITH CONNECTORS - 12 FT - WHITE - 1 CIRCUIT	SB	GC	120 V	0 VA		
15059	1	TRACK - WITH CONNECTORS - 6 FT - WHITE - 1 CIRCUIT	SB	GC	120 V	0 VA		
19073	12	TRACK - LED FIXTURE - 2in - WHITE - 750lm NFL	SB	GC	120 V	11 VA	INTEGRATED LED	
19074	14	TRACK - LED FIXTURE - 2in - WHITE - 900lm FLOOD	SB	GC	120 V	14 VA	INTEGRATED LED	
19075	11	TRACK - LED FIXTURE - 2in - WHITE - 600LM WF	SB	GC	120 V	11 VA	INTEGRATED LED	
19076	21	TRACK - LED FIXTURE - 2in - WHITE - 750LM WF	SB	GC	120 V	11 VA	INTEGRATED LED	
X0240	2	2 AMP CURRENT LIMITER	SB	GC	120 V	240 VA		JUNO TCL2 OR EQUAL
X0360	1	3 AMP CURRENT LIMITER	SB	GC	120 V	360 VA		JUNO TCL3 OR EQUAL

### RESPONSIBILITY LEGEND

GC GENERAL CONTRACTOR  
LL LANDLORD  
SB STARBUCKS

**NOTE:** ALL RESPONSIBILITIES TO BE CONFIRMED WITH STARBUCKS DESIGN MANAGER PRIOR TO ORDERING/CONSTRUCTION

### SHEET NOTES

- SURFACE MOUNT TRACK DIRECTLY TO CEILING.
- REPLACE EXISTING RESTROOM SCONCE WITH NEW. RETAIN EXISTING POWER AND CONTROLS, REPAIR IF REQUIRED.
- FURNISH AND INSTALL DLDPS-60W-FPCZT LED STRIP DRIVER FOR MAXIMUM OF 20 FOOT RUN OF STRIP TAPE. RUN LOW VOLTAGE (0-10VDC) CONTROLLER TO SWITCHBANK AND PROVIDE SUITABLE DIMMER SWITCH.
- FURNISH AND INSTALL DLDPS-96W-FPCZT LED STRIP DRIVER FOR MAXIMUM OF 32 FOOT RUN OF STRIP TAPE. RUN LOW VOLTAGE (0-10VDC) CONTROLLER TO SWITCHBANK AND PROVIDE SUITABLE DIMMER SWITCH.
- SWITCHBANK REFER TO SWITCHBANK DETAIL THIS SHEET FOR ADDITIONAL INFORMATION.
- FLOOR LAMP REFER TO E101 - ELECTRICAL DESIGN PLAN FOR LOCATION OF RECEPTACLE FOR LAMP.
- CURRENT LIMITER FURNISHED AND INSTALLED BY ELECTRICAL CONTRACTOR. REFER TO LIGHTING FIXTURE SCHEDULE FOR SPECIFIC MODEL INFORMATION. MATCH TRACK COLOR AND ROUTE CONTROLS TO LIGHTING SWITCHBANK.

### LIGHTING DESIGN PLAN NOTES


- ALL FIXTURES IN WORK ROOM, BACK AND FRONT LINE, ABOVE CONDIMENT CART, AND ANY OTHER AREAS WHERE EXPOSED FOOD, CLEAN EQUIPMENT OR UTENSILS, OR UNWRAPPED SINGLE SERVICE ITEMS WILL BE EXPOSED, SHALL HAVE SHATTERPROOF LAMPS IF THE FIXTURE IS NOT LENSED. ARCHITECT OF RECORD TO INCLUDE APPROPRIATE LAMPS / FIXTURES ON DRAWINGS AND SCHEDULES, AND COMPLY WITH ANY ADDITIONAL JURISDICTIONAL LIGHTING REQUIREMENT.
- PROVIDE GROMMET AT ALL CEILING PENETRATIONS FOR FIXTURES/SUPPORTS.
- CENTER EMERGENCY/EXIT LIGHTS ABOVE DOORS, UNLESS OTHERWISE NOTED.
- ADJUST FOCUS OF ALL TRACK AND RECESSIBLE DIRECTIONAL LIGHTING TO FULLY ILLUMINATE TASK ARTWORK, MENU BOARDS, AND MERCHANDISE DISPLAYS.
- IF PENDANT CYLINDERS CAN BE USED, LENGTH EXCEEDS 48" (1220MM) FROM CEILING, REPLACE WITH SURFACE MOUNTED CYLINDER CANS AND SUSPEND WITH GENERAL CONTRACTOR SUPPLIED CONDUIT AND J-BOX TO DIMENSIONED HEIGHT.

FURNISH AND INSTALL DIMMER SWITCHES WITH A MINIMUM 50% LIGHTING REDUCTION. COORDINATE REQUIREMENTS WITH LIGHTING VENDOR.

SWITCH a ENGINE TRACK	SWITCH b SEATING TRACK (1)	SWITCH c WALL SCONCES
\$	\$	\$
SWITCH d SEATING TRACK (2)	SWITCH e LED STRIP TAPE	
\$	\$	


### 2 SWITCHBANK DETAIL

Scale: 6" = 1'-0"

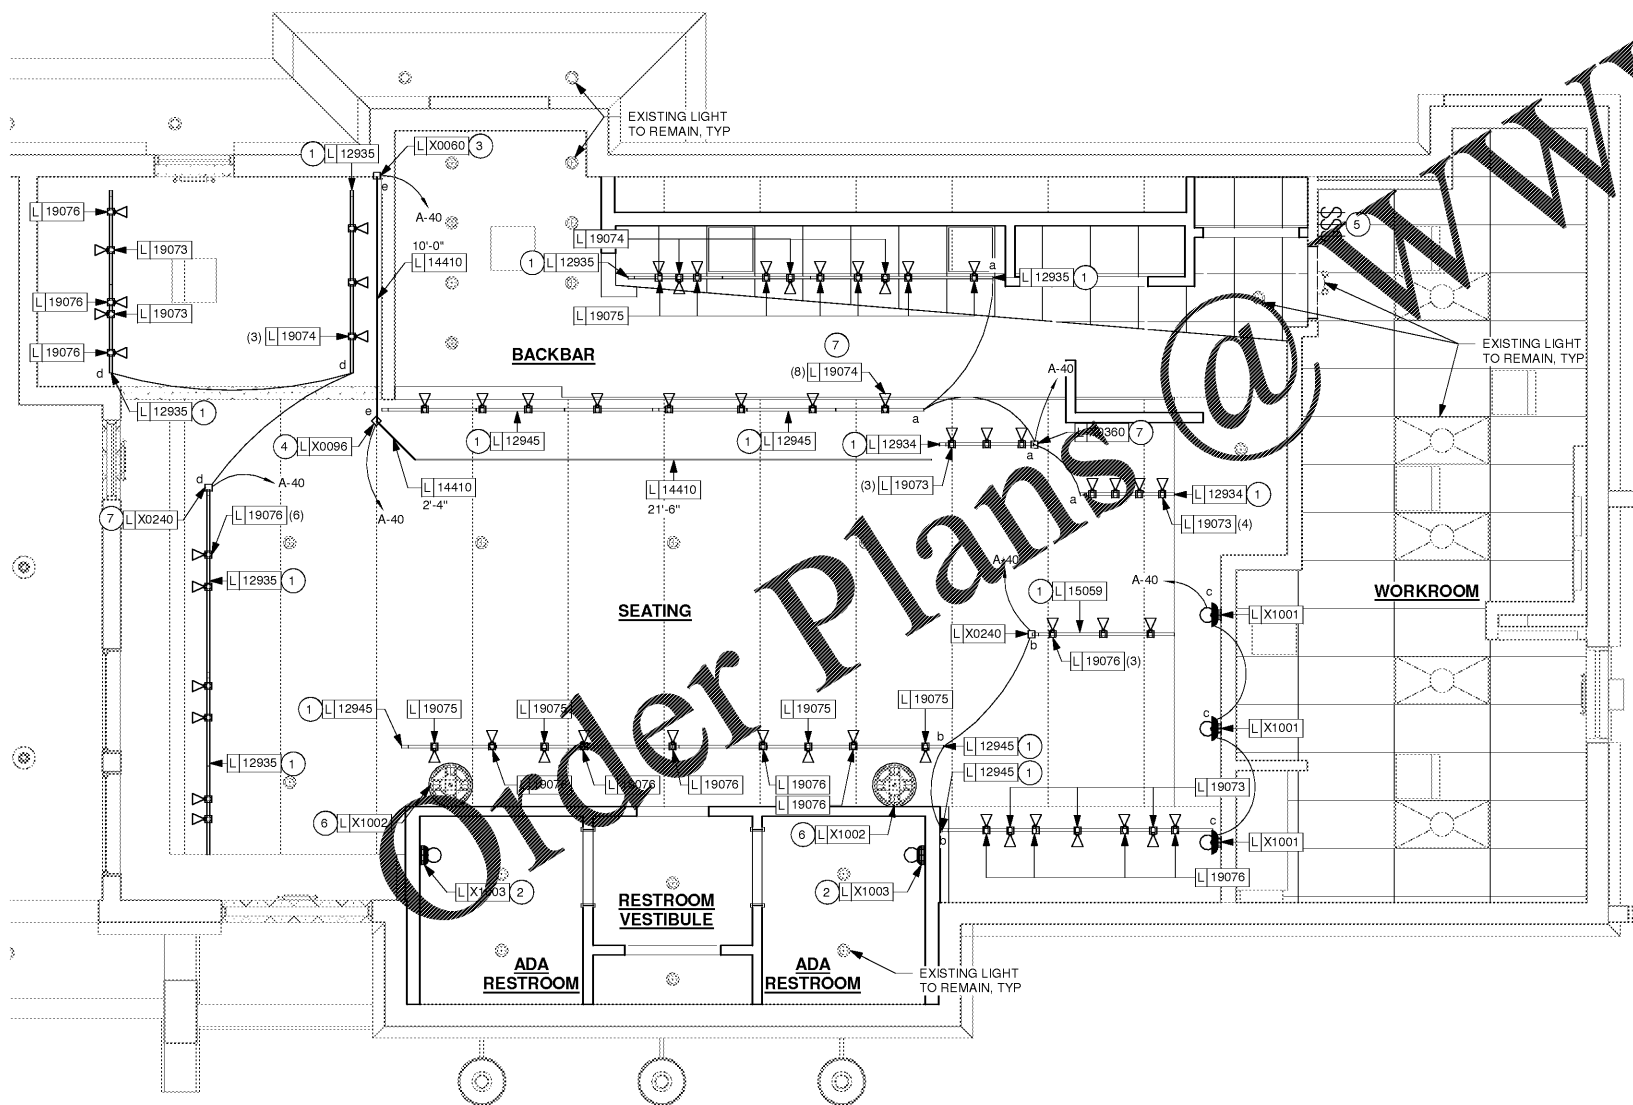

### 1 LIGHTING DESIGN PLAN

 Scale: 1/4" = 1'-0"



CONSTRUCTION DOCUMENTS - ISSUED FOR CONSTRUCTION USE



**STARBUCKS**  
2401 UTAH AVENUE SOUTH  
SEATTLE, WASHINGTON 98134  
(206) 318-1575

THESE DRAWINGS AND THE PROJECT MANUAL ARE CONFIDENTIAL AND SHALL REMAIN THE SOLE PROPERTY OF STARBUCKS CORPORATION, WHICH IS THE OWNER OF THE COPYRIGHT IN THIS WORK. THEY SHALL NOT BE REPRODUCED (IN WHOLE OR IN PART), SHARED WITH THIRD PARTIES OR USED IN ANY MANNER ON OTHER PROJECTS OR EXTENSIONS TO THIS PROJECT WITHOUT THE PRIOR WRITTEN CONSENT OF STARBUCKS CORPORATION. THESE DRAWINGS AND SPECIFICATIONS ARE INTENDED TO EXPRESS DESIGN INTENT FOR A PROTOTYPICAL STARBUCKS STORE (WHICH IS SUBJECT TO CHANGE AT ANY TIME) AND DO NOT REFLECT ACTUAL SITE CONDITIONS. NEITHER PARTY SHALL HAVE ANY OBLIGATION OR LIABILITY TO THE OTHER (EXCEPT STATED ABOVE) UNTIL A WRITTEN AGREEMENT IS FULLY EXECUTED BY BOTH PARTIES.

STARBUCKS TEMPLATE VERSION I2019.01.11

Randall C. Haase  
P.E.

SUITE 503P 479.636.5004  
1855 N. 2ND ST. JOB NO.: 23118  
ROGERS, AR 72756 DESIGNED BY: LES



PROJECT NAME:  
**CUSICK & ALCOA**

PROJECT ADDRESS:  
**121 CUSICK ROAD  
ALCOA, TN 37701  
BLOUNT COUNTY**

STORE #: 11293  
PROJECT #: 36099-035  
ISSUE DATE: 04.26.19  
DESIGN MANAGER: L MACEDA  
PRODUCTION DESIGNER: LES  
CHECKED BY: WAJ

Revision Schedule			
Rev	Date	By	Description

SHEET TITLE:  
**LIGHTING DESIGN PLAN**

SCALE: AS SHOWN

SHEET NUMBER:  
**E102**

4/25/2019 3:42:15 PM C:\Users\jjw\Documents\11293\_TN\_Cusick & Alcoa\_Revit Model\_MEP17\_NWH.rvt