



© 2018 STARBUCKS COFFEE COMPANY


STARBUCKS
2401 UTAH AVENUE SOUTH
SEATTLE, WASHINGTON 98134
(206) 318-1575

THESE DRAWINGS AND THE PROJECT MANUAL ARE CONFIDENTIAL AND SHALL REMAIN THE SOLE PROPERTY OF STARBUCKS CORPORATION, WHICH IS THE OWNER OF THE COPYRIGHT IN THIS WORK. THEY SHALL NOT BE REPRODUCED (IN WHOLE OR IN PART), SHARED WITH THIRD PARTIES OR USED IN ANY MANNER ON OTHER PROJECTS OR EXTENSIONS TO THIS PROJECT WITHOUT THE PRIOR WRITTEN CONSENT OF STARBUCKS CORPORATION. THESE DRAWINGS AND SPECIFICATIONS ARE INTENDED TO EXPRESS DESIGN INTENT FOR A PROTOTYPICAL STARBUCKS STORE (WHICH IS SUBJECT TO CHANGE AT ANY TIME) AND DO NOT REFLECT ACTUAL SITE CONDITIONS. NEITHER PARTY SHALL HAVE ANY OBLIGATION NOR LIABILITY TO THE OTHER (EXCEPT STATED ABOVE) UNTIL A WRITTEN AGREEMENT IS FULLY EXECUTED BY BOTH PARTIES.

STARBUCKS TEMPLATE VERSION I2019.01.11

Jason M. Scates
P.E.

SUITE 5274 478-636-5004
1805 N 2ND ST JOB NO.: 23138
ROGERS, AR 72756 DESIGNED BY: RAC

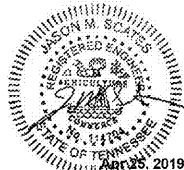

PROJECT NAME:
CUSICK & ALCOA

PROJECT ADDRESS:
121 CUSICK ROAD
ALCOA, TN 37701
BLOUNT COUNTY

STORE #: 11293
PROJECT #: 36099-035
ISSUE DATE: 04.25.19
DESIGN MANAGER: L MACEDA
PRODUCTION DESIGNER: RAC
CHECKED BY: JMS


Revision Schedule			
Rev	Date	By	Description

SHEET TITLE:
PLUMBING DETAILS


SCALE: AS SHOWN

SHEET NUMBER:
P501

CONSTRUCTION DOCUMENTS - ISSUED FOR CONSTRUCTION USE

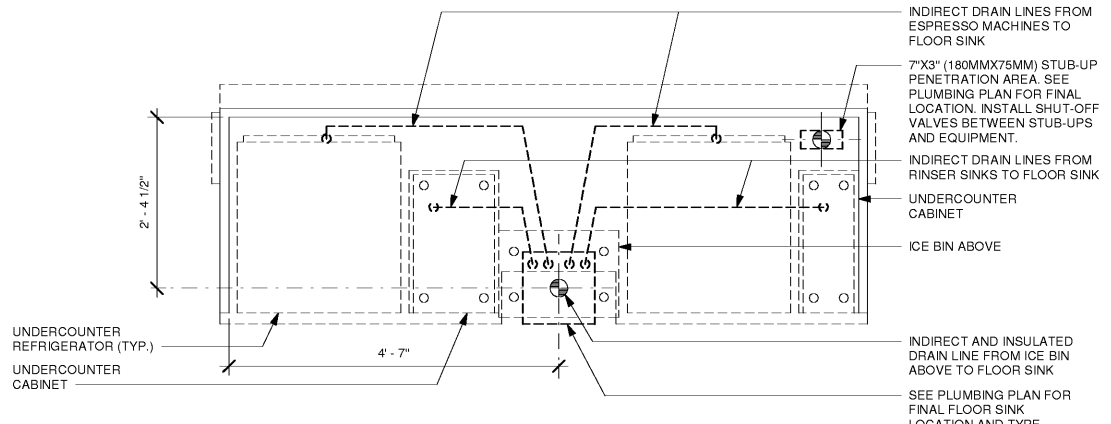


UNDER COUNTER

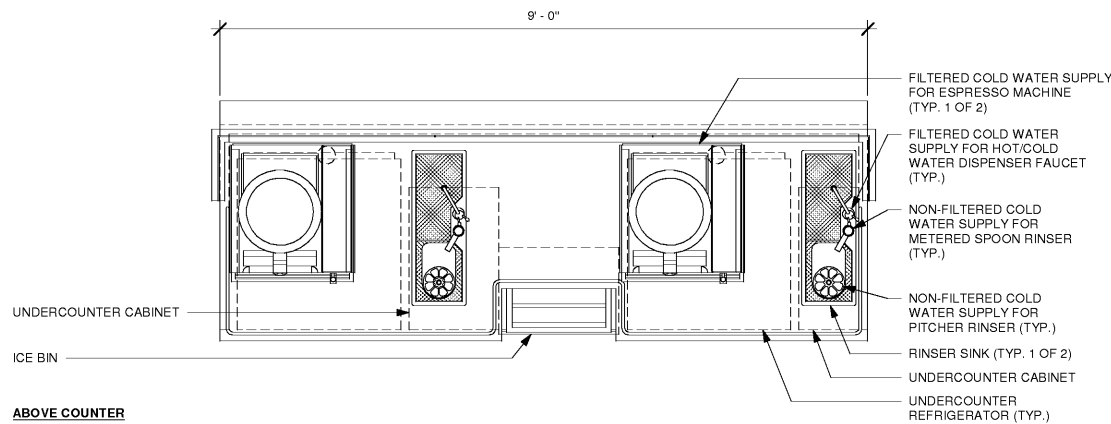


ABOVE COUNTER


1 ESP 07-01 PLUMBING
Scale: 3/4" = 1'-0"

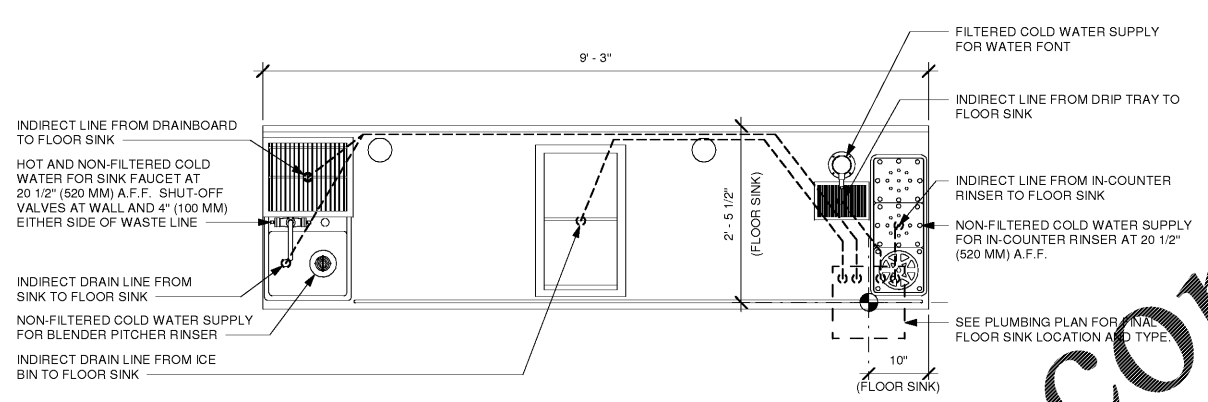


2 CBE 01-03 PLUMBING
Scale: 3/4" = 1'-0"

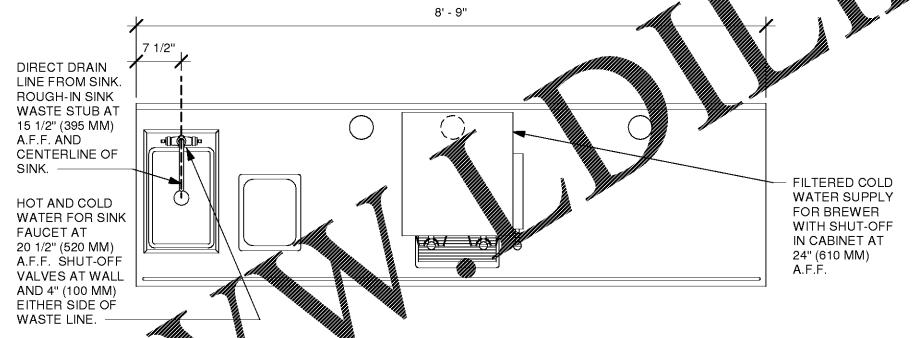

3 BRW 04-02 PLUMBING
Scale: 3/4" = 1'-0"

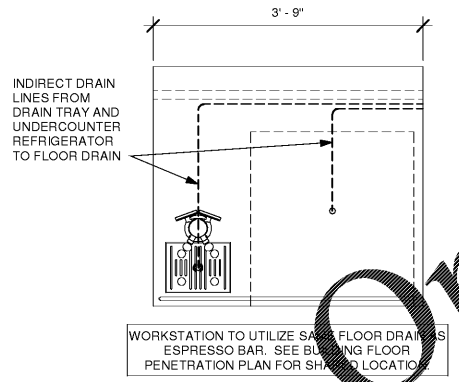

4 NIT 07-01 PLUMBING
Scale: 3/4" = 1'-0"

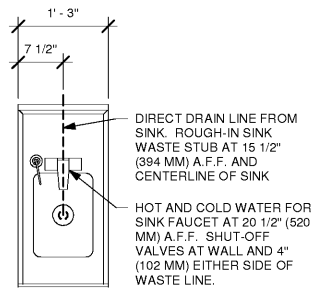

5 ADD 02-01 PLUMBING
Scale: 3/4" = 1'-0"

C:\Users\rac\Documents\11293_TN_Cusick & Alcoa_Revit Model_MEP17_RAC.rvt

4/25/2019 1:11:25 PM

Order Plans @ WWW.LDILine.com