


Order Plans @


WWW.LDLINE.COM

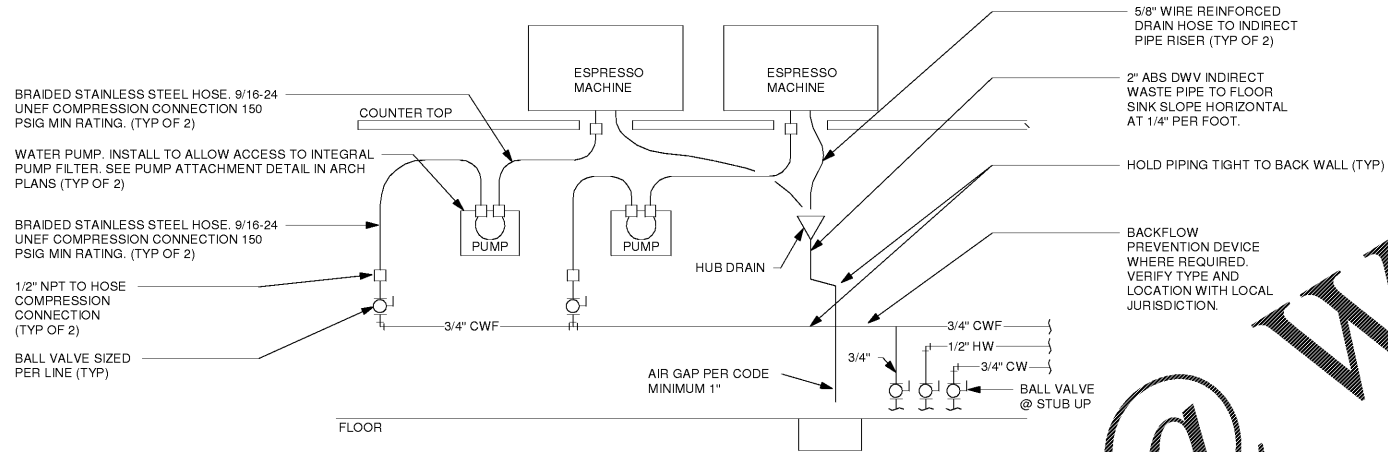

1 ESPRESSO MACHINE PIPING CONNECTION DETAIL  
Scale: NTS

DETAIL NOTES

1. THIS DETAIL IS SCHEMATIC ONLY. SEE THE PLUMBING DRAWINGS.
2. ALL WATER HOSES SHALL BE THE MINIMUM LENGTH NEEDED AND SUPPORTED AS NEEDED TO AVOID STRESSING CONNECTIONS AND COILING EXCESSIVE HOSE. ROUTE TO AVOID KINKING AND ALLOW SPACE FOR UNDER COUNTER REFRIGERATOR ACCESS TO EQUIPMENT AND VALVES.
3. ALL PIPING SHALL BE HELD TIGHT TO WALLS, SLOPED WHERE NEEDED AND ROUTED TO ALLOW ACCESS TO THE EQUIPMENT AND VALVES.  
ROUTE HORIZONTAL PIPING A MINIMUM OF 6" ABOVE FLOOR.
5. COORDINATE LOCATION AND ELEVATION OF ALL EQUIPMENT WITH OTHER TRADES. ORIENT PUMP AS NEEDED TO ALLOW MAINTENANCE.

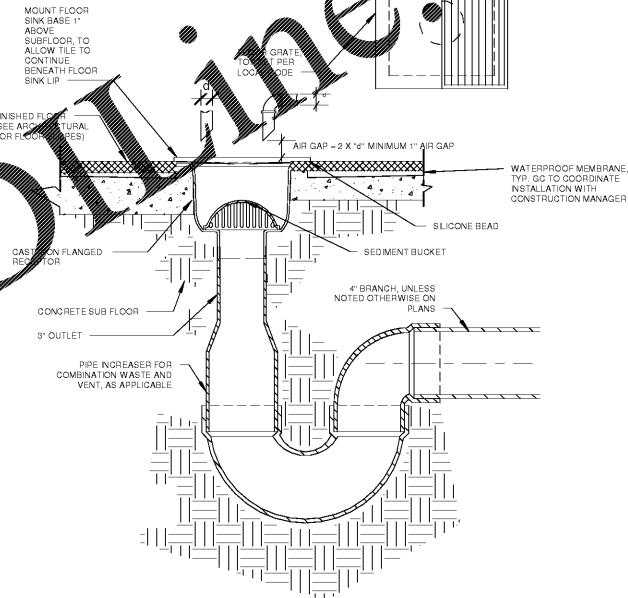

2 PLUMBING - FIXTURE - DRAIN  
Scale: 1" = 1'-0"




**STARBUCKS**<sup>®</sup>  
2401 UTAH AVENUE SOUTH  
SEATTLE, WASHINGTON 98134  
(206) 318-1575

THESE DRAWINGS AND THE PROJECT MANUAL ARE CONFIDENTIAL AND SHALL REMAIN THE SOLE PROPERTY OF STARBUCKS CORPORATION, WHICH IS THE OWNER OF THE COPYRIGHT IN THIS WORK. THEY SHALL NOT BE REPRODUCED (IN WHOLE OR IN PART), SHARED WITH THIRD PARTIES OR USED IN ANY MANNER ON OTHER PROJECTS OR EXTENSIONS TO THIS PROJECT WITHOUT THE PRIOR WRITTEN CONSENT OF STARBUCKS CORPORATION. THESE DRAWINGS AND SPECIFICATIONS ARE INTENDED TO EXPRESS DESIGN INTENT FOR A PROTOTYPICAL STARBUCKS STORE (WHICH IS SUBJECT TO CHANGE AT ANY TIME) AND DO NOT REFLECT ACTUAL SITE CONDITIONS. NEITHER PARTY SHALL HAVE ANY OBLIGATION NOR LIABILITY TO THE OTHER (EXCEPT STATED ABOVE) UNTIL A WRITTEN AGREEMENT IS FULLY EXECUTED BY BOTH PARTIES.

STARBUCKS TEMPLATE VERSION | 2019.01.11

Jason M. Scates  
P.E.

SUITE 5274 478-636-5004  
1805 N 2ND ST JOB NO.: 23138  
ROGERS, AR 72756 DESIGNED BY: RAC

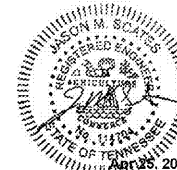

PROJECT NAME:  
**CUSICK & ALCOA**

PROJECT ADDRESS:  
121 CUSICK ROAD  
ALCOA, TN 37701  
BLOUNT COUNTY

STORE #: 11293  
PROJECT #: 36099-035  
ISSUE DATE: 04.25.19  
DESIGN MANAGER: L. MACEDA  
PRODUCTION DESIGNER: RAC  
CHECKED BY: JMS

Revision Schedule			
Rev	Date	By	Description

SHEET TITLE:  
**PLUMBING DETAILS**

SCALE: AS SHOWN

SHEET NUMBER:  
**P502**

CONSTRUCTION DOCUMENTS - ISSUED FOR CONSTRUCTION USE