



Order Plans @ www.LDLine.com

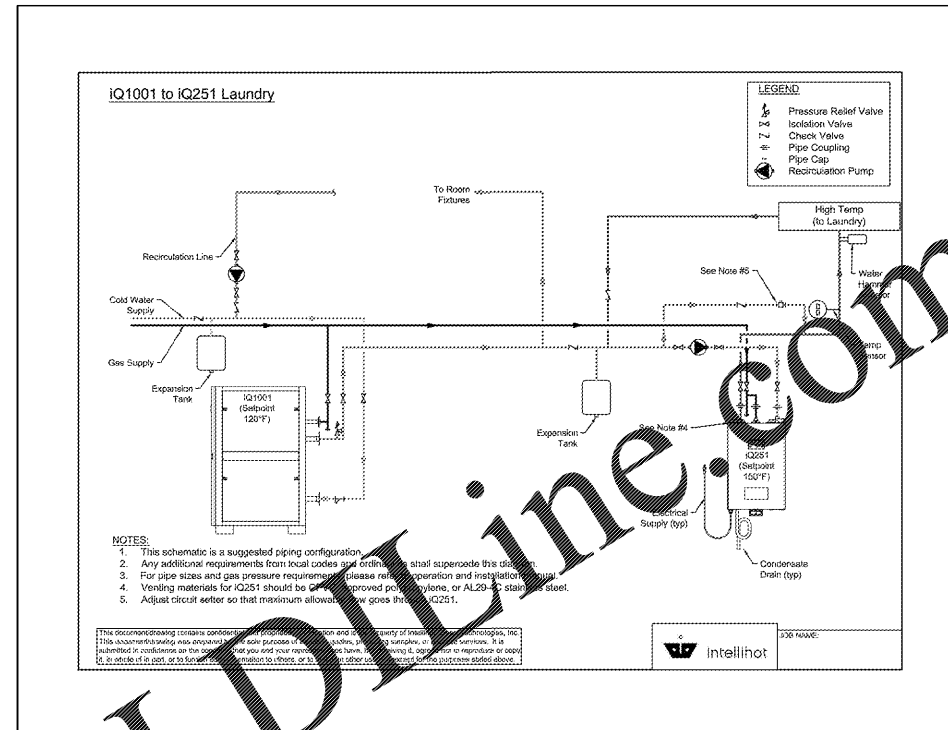

2 DOMESTIC WATER HEATER DETAIL
P.004 NOT TO SCALE

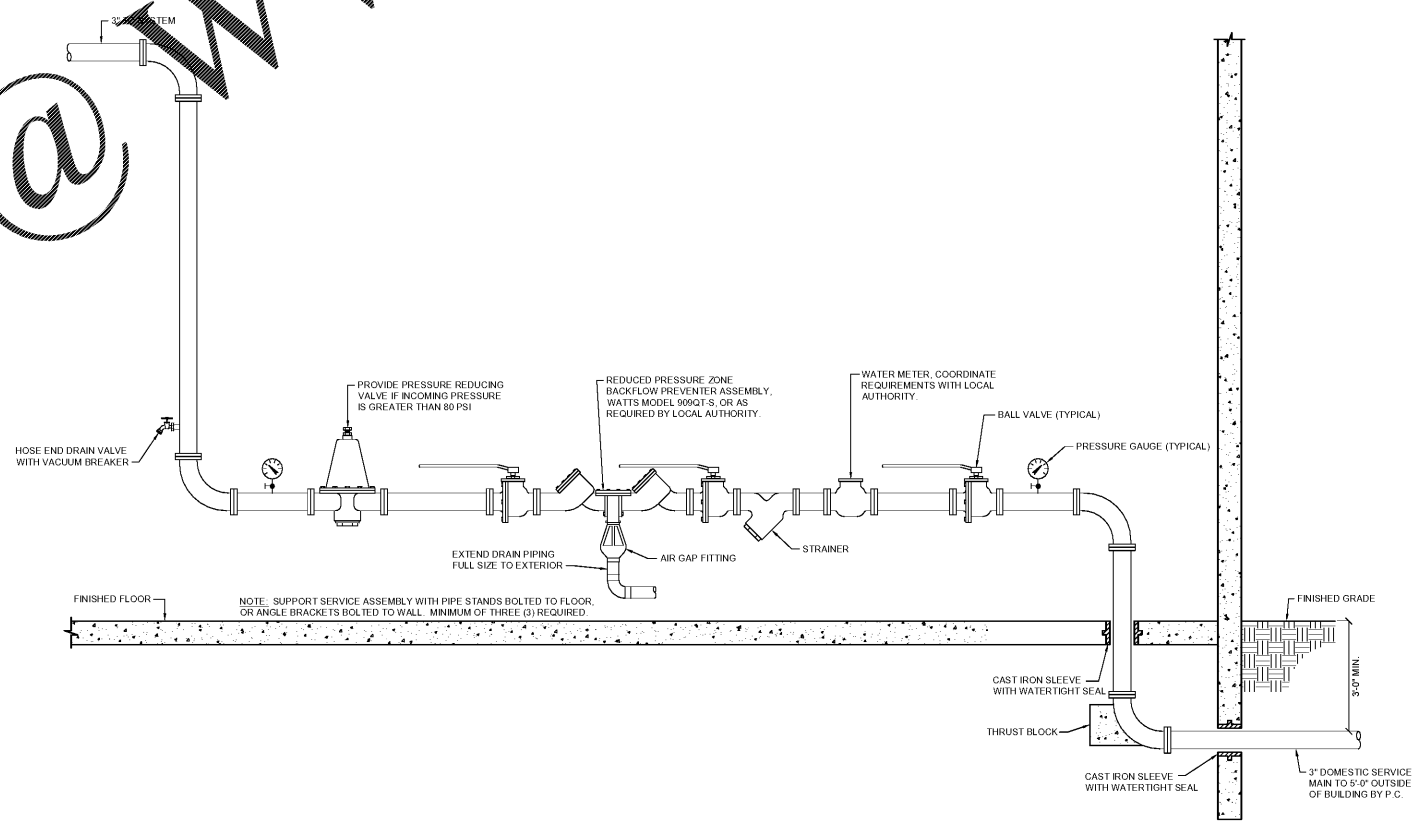

1 DOMESTIC SERVICE ENTRANCE DETAIL
P.004 NOT TO SCALE



Ragone Architecture & Design, PLLC
145A S. Carypark Road, Charlotte, NC 28209
T: 704.372.5110 www.rad-arch.com



WAVE ENGINEERING
1302 S. MINT ST., SUITE 110
CHARLOTTE, NC 28209
PHONE: 704.372.5110
FAX: 704.372.5111
WAVE PROJECT #18021



HOME 2 SUITES BELMONT

HAWLEY AVE
BELMONT, NC 28012

KEY PLAN

Revisions		
#	Date	Description

Project Number: 18021
Issued for: CONSTRUCTION
Issue Date: 2019.06.07

DRAWING TITLE
PLUMBING DETAILS

SHEET NUMBER
P.004