


Revisions		
#	Date	Description

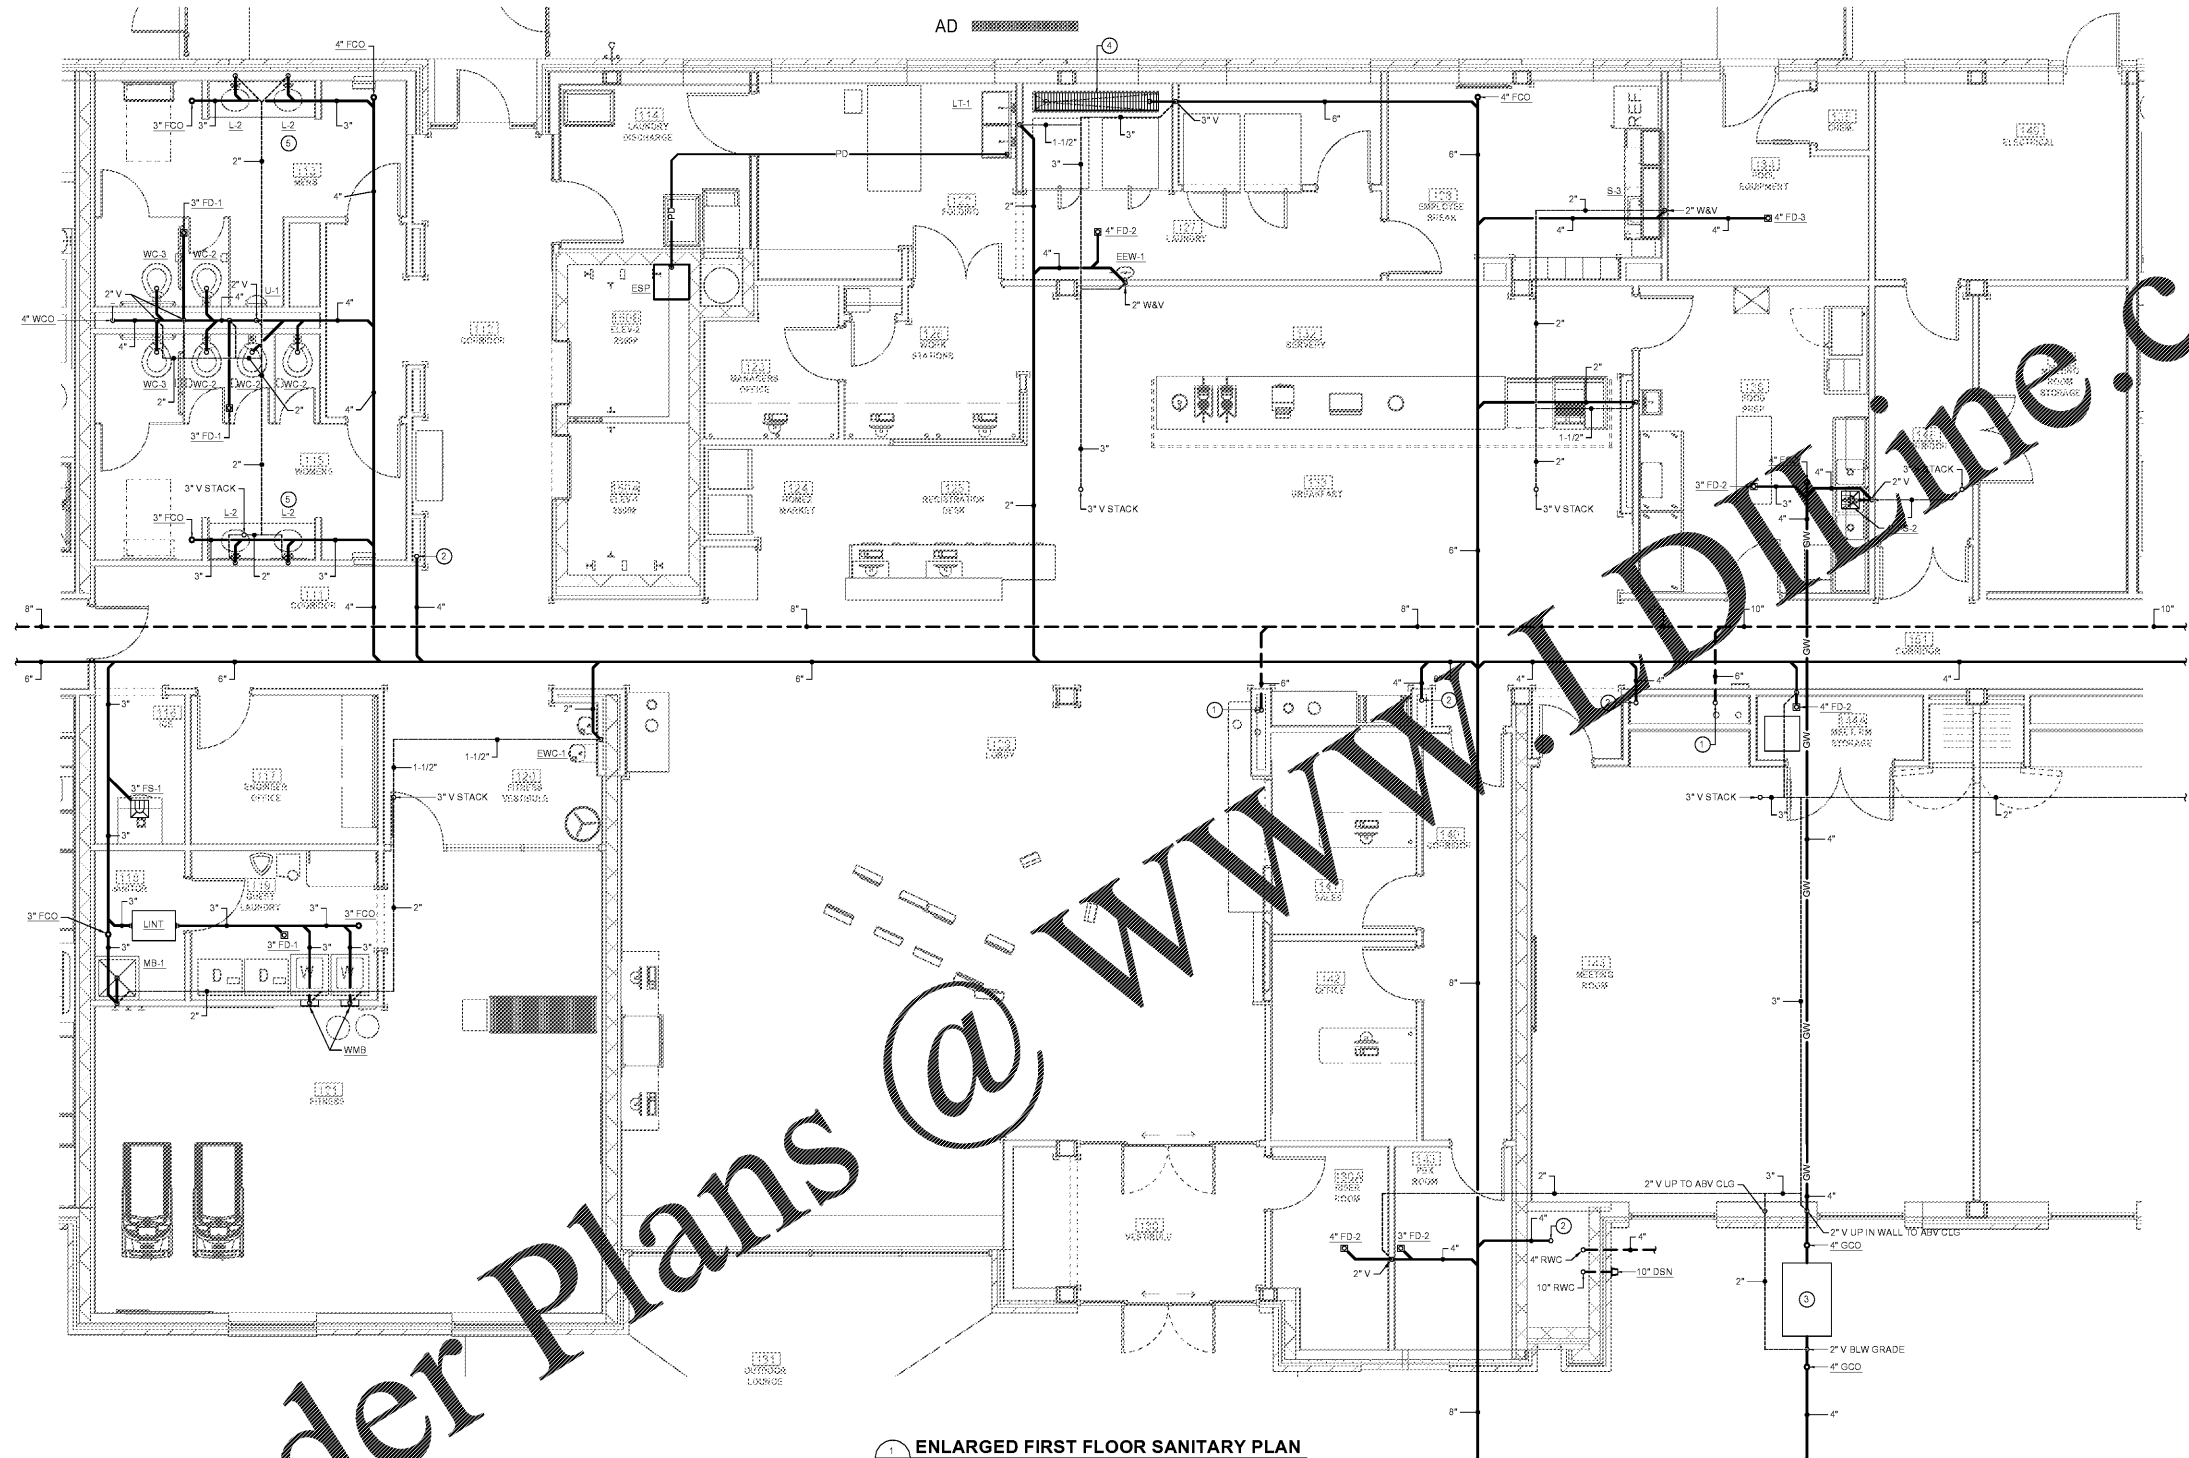

ENLARGED FIRST FLOOR SANITARY PLAN
SCALE: 1/8" = 1'-0"

KEYED NOTES THIS SHEET

- ① 6" RWC DOWN TO BELOW FLOOR
- ② 4" SAN STACK DOWN TO BELOW FLOOR
- ③ GREASE INTERCEPTOR BELOW GRADE. SEE SIZING SCHEDULE ON SHEET PD 02 FOR SPECIFICATIONS AND SEE DETAIL ON SHEET PD 03 FOR INSTALLATION INSTRUCTIONS.
- ④ 12" WIDE X 18" HIGH X 7'-0" LONG ABS DRAIN TROUGH WITH LINT SCREEN AND 6" BOTTOM OUTLET, MANUFACTURED BY HIGH MARK MANUFACTURING, INC.
- ⑤ IN LIEU OF SPECIFIED P-TRAP AND AUTOMATIC TRAP PRIMER VALVE, ZURN Z1021 WATER SAVER TRAP PRIMER P-TRAP WITH CLEANOUT PLUG AND PRIMER HOSE MAY BE PROVIDED. CONNECT 1/2" TRAP PRIMER LINE TO PRIMER HOSE, DROP DOWN IN WALL TO BELOW FLOOR, AND EXTEND BELOW FLOOR TO CONNECTION ON FLOOR DRAIN.

Project Number: 18021
Issued for: CONSTRUCTION
Issue Date: 2019.08.07

DRAWING TITLE
ENLARGED FIRST FLOOR SANITARY PLAN

SHEET NUMBER
P.203

Order Plans @ WWW.IDIline.com