



Ragone Architecture & Design, PLLC
145A S. Stryker Road, Charlotte, NC 28209
T: 704.372.5110 www.rad-arch.com



WAVE ENGINEERING
1302 S. MINT ST., SUITE 110
CHARLOTTE, NC 28209
REG. NO. 7788
PROFESSIONAL ENGINEER LICENSE
NO. 35074 LICENSE #11542
WAVE PROJECT #15042



**HOME 2
SUITES
BELMONT**
HAWLEY AVE
BELMONT, NC 28012


KEY PLAN

Revisions		
#	Date	Description

Project Number: 18021
Issued for: CONSTRUCTION
Issue Date: 2019.06.07

DRAWING TITLE
**FIRE
PROTECTION
FIRST FLOOR
PLAN**

SHEET NUMBER
FP.101

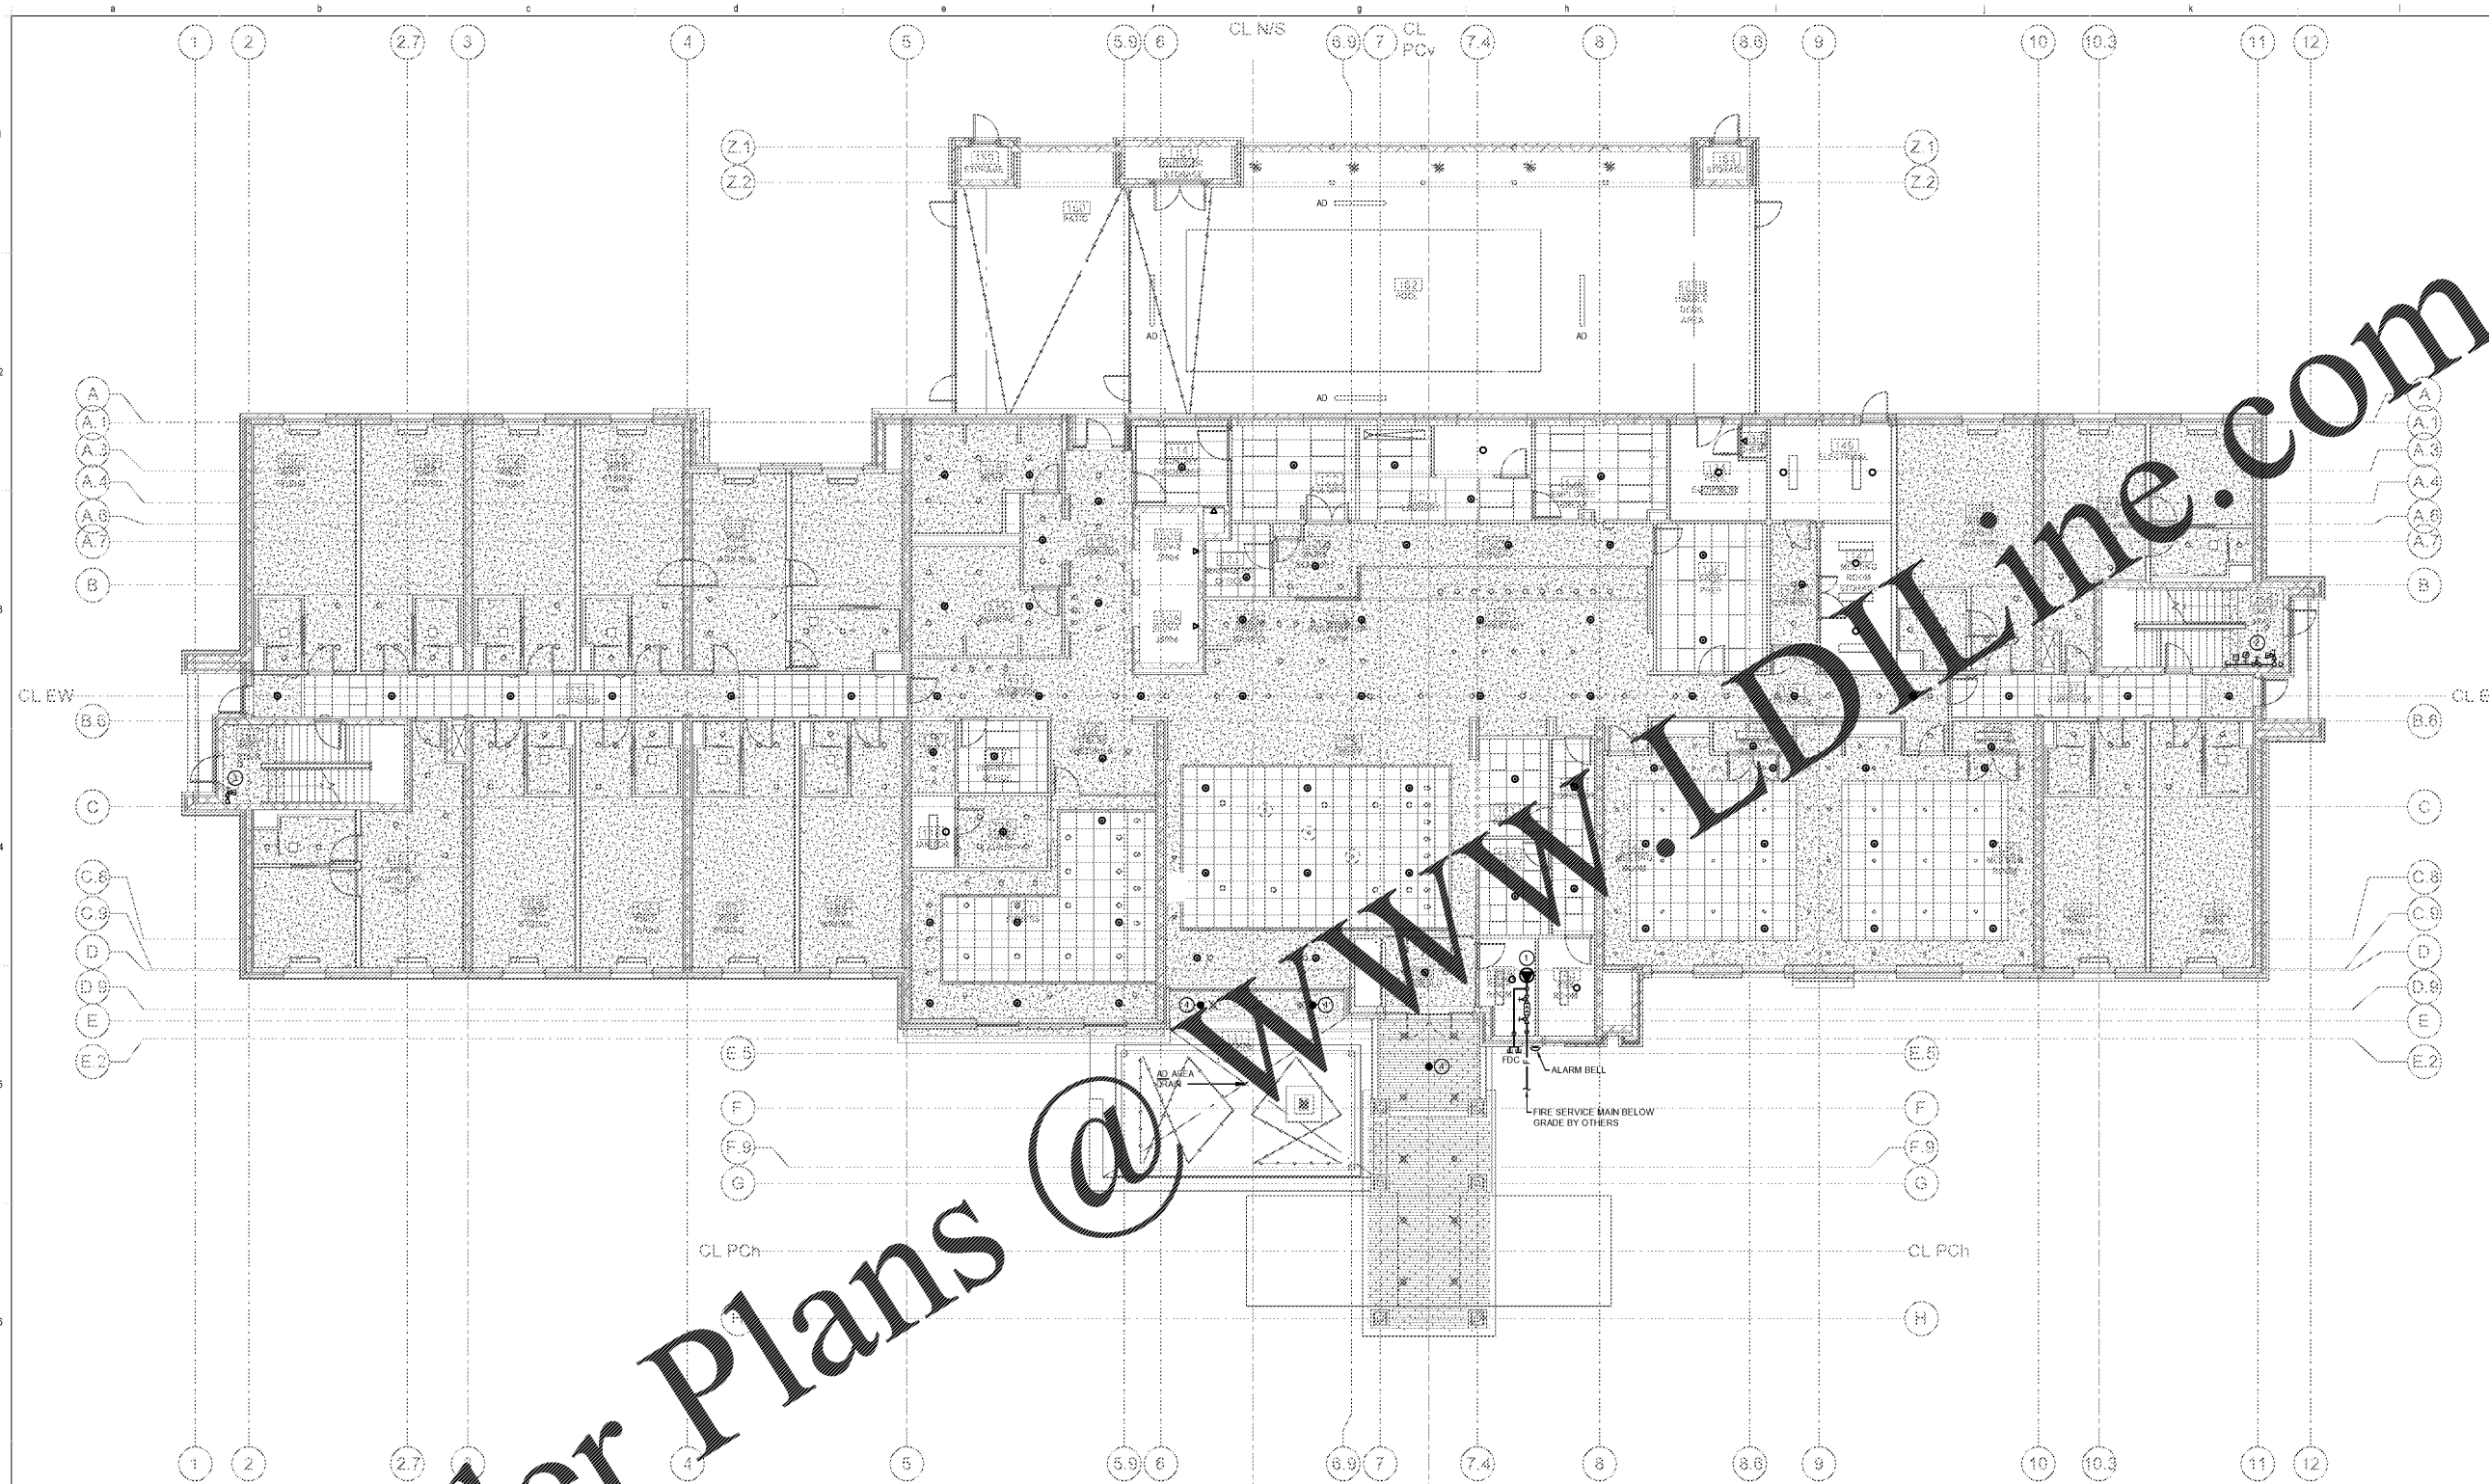

Order Plans @ www.ediline.com

1 FIRST FLOOR PLAN
FP.101 SCALE: 1/8" = 1'-0"

KEYED NOTES THIS SHEET

- ① FIRE SERVICE ENTRANCE. SEE DETAIL #1 ON SHEET FP.001.
- ② FIRE STANDPIPE AND DRAIN RISERS WITH FLOOR CONTROL ASSEMBLY AND FIRE DEPARTMENT HOSE CONNECTION. SEE DETAIL #2 ON SHEET FP.001.
- ③ FIRE STANDPIPE RISER WITH FIRE DEPARTMENT HOSE CONNECTION. SEE DETAIL #3 ON SHEET FP.001.
- ④ PROVIDE DRY SPRINKLER HEADS IN EXTERIOR SOFFITS AND ATTACHED CANOPIES.

GENERAL NOTES THIS SHEET

- 1 SEE ENLARGED TYPICAL GUEST ROOM PLANS ON SHEET FP.201 FOR SPRINKLERS IN TYPICAL GUEST ROOMS.