



Ragone Architecture & Design, PLLC
145A S. Stryker Road, Charlotte, NC 28209
T: 704.372.5110 www.rad-arch.com



WAVE ENGINEERING
1302 S. MINT ST., SUITE 110
CHARLOTTE, NC 28209
REGISTERED PROFESSIONAL ENGINEER
REGISTERED LICENSE #11787
WAVE PROJECT #18042



**HOME 2
SUITES
BELMONT**
HAWLEY AVE
BELMONT, NC 28012


KEY PLAN

Revisions		
#	Date	Description

Project Number: 18021
Issued for: CONSTRUCTION
Issue Date: 2018.05.07

DRAWING TITLE
**FIRE
PROTECTION
ROOF PLAN**

SHEET NUMBER
FP.103

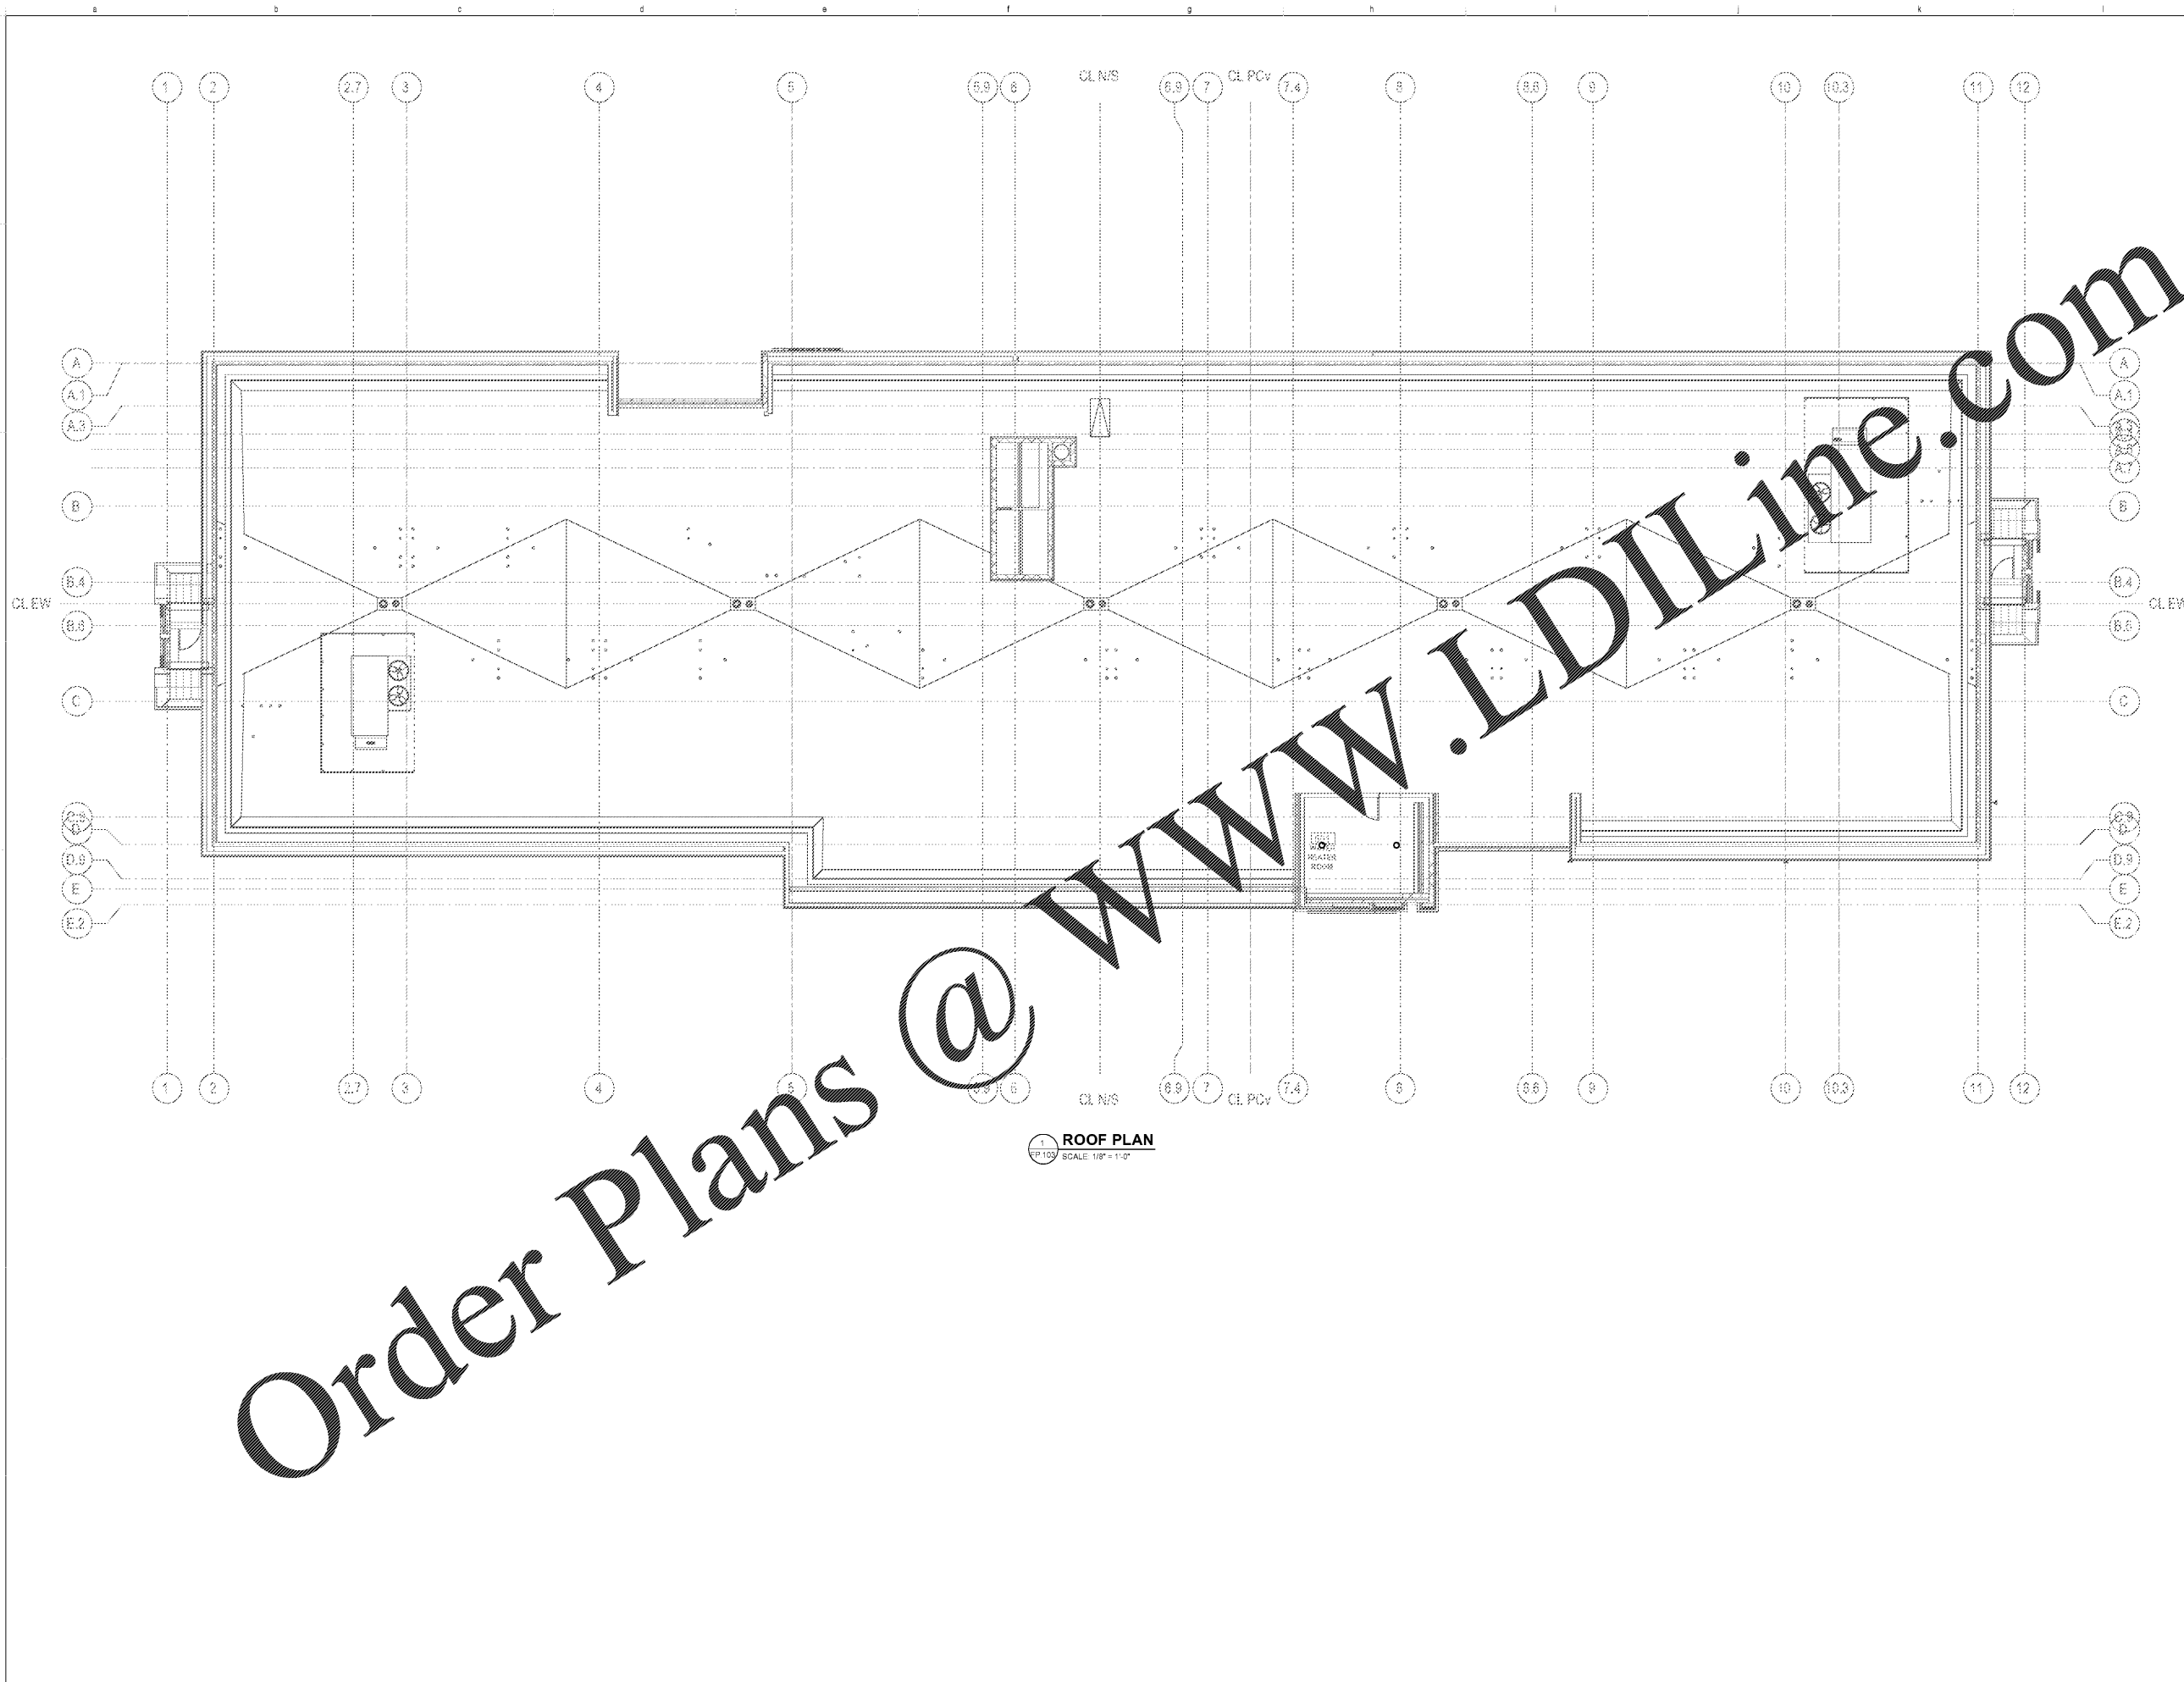

Order Plans @