


EQUIPMENT SCHEDULE (CONT.)				ELECTRIC
NO.	DESCRIPTION	PROV. BY	INSTALL BY	CONNECTED BY
ELECTRIC FRYERS				
AA	EXHAUST HOOD #1 @ 142"	DYKES	G.C.	G.C.
BB	REFRIGERATED BASE 64"	DYKES	DYKES	OWNER
CC	ELECTRIC FRYER - SMALL	DYKES	DYKES	OWNER
DD	ELECTRIC FRYER - LARGE	DYKES	DYKES	OWNER
EE	REFRIGERATED BASE 48"	DYKES	DYKES	OWNER
GAS FRYERS				
A	TBD	-	-	-
B	TBD	-	-	-
C	TBD	-	-	-
D	TBD	-	-	-
E	TBD	-	-	-

EQUIPMENT SCHEDULE				ELECTRIC
NO.	DESCRIPTION	PROV. BY	INSTALL BY	CONNECTED BY
1	CASH REGISTERS	OWNER	OWNER	OWNER
2	WIRE SHELVING UNITS	DYKES	OWNER	OWNER
3	U.C. REFRIGERATOR	DYKES	OWNER	OWNER
4	SERVICE COUNTER/ FRONT	DYKES	DYKES	DYKES
5	FRONT COUNTER / DRIVE THRU	DYKES	DYKES	DYKES
5A	DROP-IN SINK	DYKES	DYKES	OWNER
6	MONITORS	OWNER	OWNER	OWNER
7	DRINK DISPENSER	OWNER	OWNER	OWNER
7A	HEAD CARBONATOR	OWNER	OWNER	OWNER
8	COFFEE / TEA MAKER	DYKES	OWNER	OWNER
9	SERVICE COUNTER/ BACK	DYKES	DYKES	DYKES
10	MENU BOARD (INT / EXT)	OWNER	OWNER	OWNER
11	TEA DISPENSERS	DYKES	DYKES	DYKES
12	HEAT LAMP / PASS THRU	DYKES	DYKES	OWNER
13	OPEN	-	-	-
14	T ¹ LINE CAPTAINS TABLE	DYKES	DYKES	OWNER
14A	HOLDING BIN, HEATED	DYKES	DYKES	OWNER
14a	CAPTAINS TABLE	DYKES	DYKES	OWNER
14b	CAPTAINS TABLE	DYKES	DYKES	OWNER
14c	CAPTAINS TABLE	DYKES	DYKES	OWNER
14d	CAPTAINS TABLE	DYKES	DYKES	OWNER
15	STEAMER	DYKES	DYKES	OWNER
16	STEAMER CONDENSER	DYKES	DYKES	OWNER
16	OPEN	-	-	-
17	DEL. W/ U.C. REFRIG.	DYKES	DYKES	OWNER
18	PROILER	DYKES	DYKES	OWNER
18A	OPEN	-	-	-
19	SAND. TOP REFRIG.	DYKES	DYKES	OWNER
20	COUNTER TOP WARMER	DYKES	DYKES	OWNER
21	OPEN	-	-	-
22	TOASTER	DYKES	DYKES	OWNER
23	MICROWAVE	DYKES	DYKES	OWNER
24	S.S. MICROWAVE SHELF	DYKES	DYKES	DYKES
25	HOT HOLDING CABINET	DYKES	DYKES	OWNER
26	SHORTENING TRANSPORTER	DYKES	DYKES	OWNER
27	SHELF UNIT - WALL MOUNTED	DYKES	DYKES	DYKES
28	5/5 WORK TABLE	DYKES	DYKES	DYKES
29	DAMAGE RACK	DYKES	DYKES	DYKES
30	DISHWASHER	DYKES	DYKES	OWNER
31	3-COMPARTMENT POT SINK	DYKES	OWNER	OWNER
31A	PRE-RINSE FAUCET	DYKES	OWNER	OWNER
32	WALL HUNG POT RACK	DYKES	DYKES	DYKES
33	VEGETABLE SINK	DYKES	DYKES	OWNER
33A	OPEN	-	-	-
34	ICE MACHINE	DYKES	DYKES	DYKES
34A	ICE BIN	DYKES	DYKES	DYKES
35	MANAGER'S DESK	DYKES	DYKES	DYKES
36	48" ELEC. CABINET	DYKES	DYKES	DYKES
37	FILE CABINET	OWNER	OWNER	OWNER
38	SAFE	DYKES	DYKES	DYKES
39	ELECTRICAL PANELS	OWNER	G.C.	G.C.
40	GREASE FILTER MACHINE	DYKES	DYKES	DYKES
41	BAG 'N' BOX RACK	OWNER	OWNER	OWNER
42	CO2 TANK	OWNER	OWNER	OWNER
43	DISH RACK	DYKES	DYKES	DYKES
44	MOBILE CART	DYKES	DYKES	DYKES
45	WALK-IN COOLER (EXISTING)	DYKES	DYKES	DYKES
46	WALK-IN FREEZER (EXISTING)	DYKES	DYKES	DYKES
47	OPEN	-	-	-
48	OPEN	-	-	-
49	OPEN	-	-	-
50	OPEN	-	-	-
51	OPEN	-	-	-
52	WORK TABLE	DYKES	DYKES	DYKES
53	WATER COOLER STAND	DYKES	DYKES	DYKES
54	INSULATED BEVERAGE SERVER	DYKES	DYKES	DYKES
55	BLENDER - BY OWNER	OWNER	OWNER	OWNER
56	MOP SINK	G.C.	G.C.	G.C.
57	SERVICE FAUCET, MOP SINK	G.C.	G.C.	G.C.
58	SHELF, WALL MOUNTED	DYKES	DYKES	DYKES
59	WATER HEATER	G.C.	G.C.	G.C.
60	HAND SINK	DYKES	OWNER	OWNER
61	ENCLOSED CABINET	DYKES	DYKES	DYKES
62	FURNITURE	DYKES	DYKES	DYKES
63	TRASH UNIT	DYKES	DYKES	DYKES
64	BACK LIT POP (DBL)	OWNER	G.C.	G.C.
65	DRINK STATION COUNTER	DYKES	DYKES	DYKES
65A	CONDIMENT COUNTER	DYKES	DYKES	DYKES
66	DRINK HEAD W/ ICE DISP.	OWNER	OWNER	OWNER
66A	DRINK HEAD CARBONATOR	OWNER	OWNER	OWNER
67	ICE MACHINE	DYKES	DYKES	DYKES
68	CONDIMENT PUMP	DYKES	DYKES	DYKES
69	HOOD FIRE SUPP. SYSTEM	DYKES	G.C.	G.C.
70	PULLS FOR FIRE SUPP. SYS.	DYKES	G.C.	G.C.
71	ECOLAB WATER FILTER	OWNER	G.C.	G.C.
-	-	-	-	-

NOT IN PROTOTYPE			
90	-	-	-
91	-	-	-

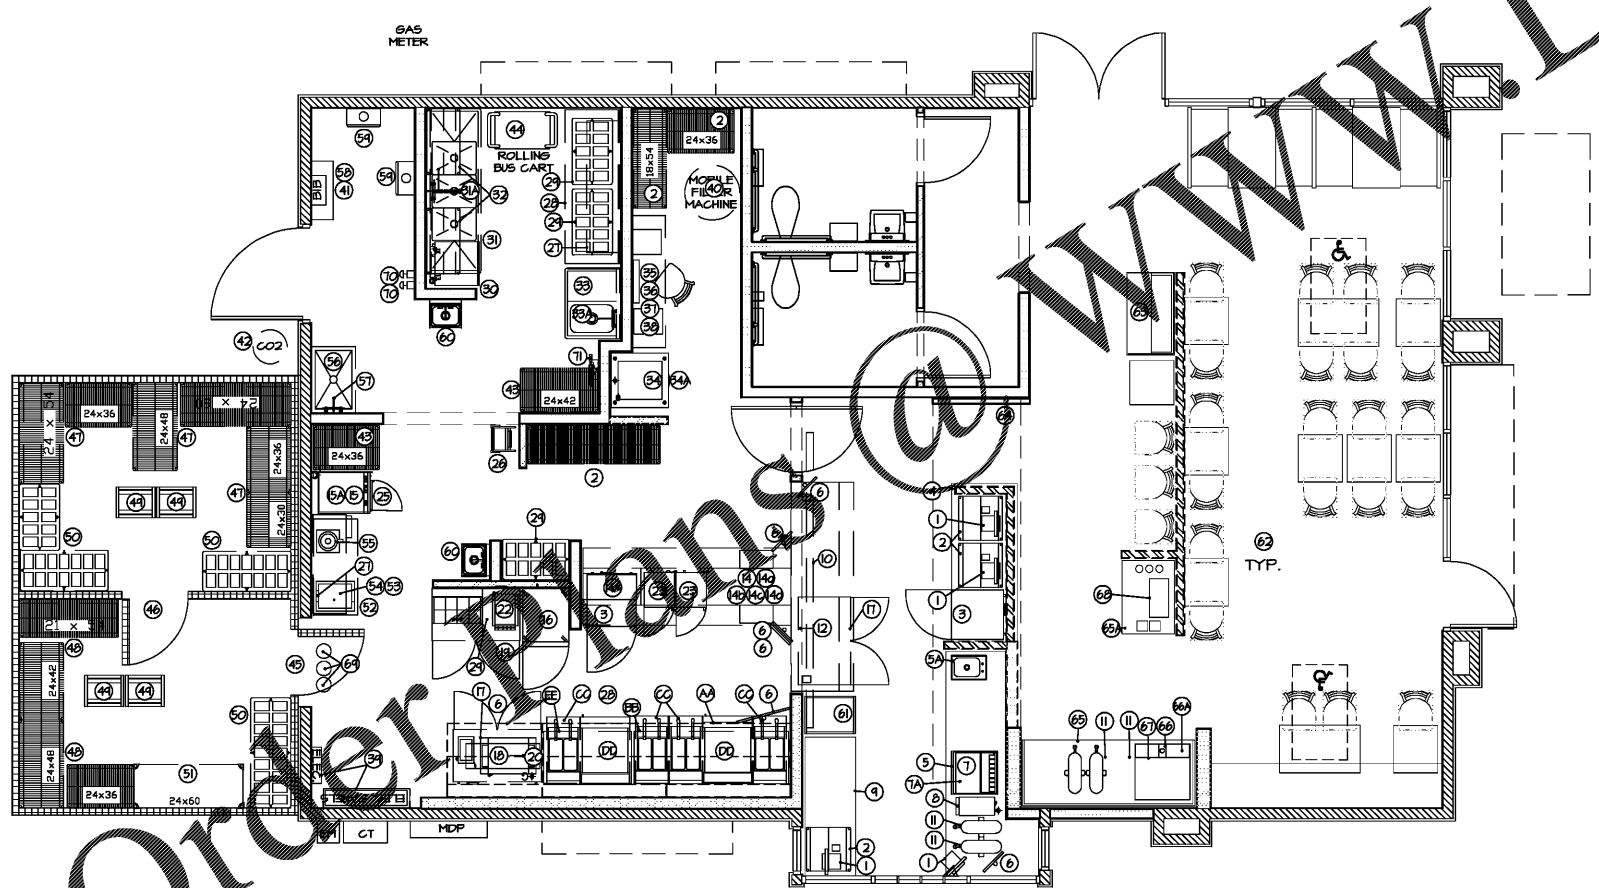

EQUIPMENT FLOOR PLAN
SCALE 1/4" = 1'-0"

DESIGN and ENGINEERING
INC ARCHITECTS
STRUCTURAL AND CIVIL ENGINEERS
1645 Westgate Circle
Brentwood, Tennessee 37027
615-370-1779 fax: 370-9108
www.dandoinc.us

STATE OF SOUTH CAROLINA
Professional Seal
01/30/19

A NEW LOCATION FOR
CAPTAIN D'S
1236 W. FLOYD BAKER BLVD
GAFFNEY, SC 29342
STAR CHAIN, INC.
11375 POINTE PLACE,
ROSWELL, GA 30076



Job Number:
68F-0071
Revisions:

JANUARY 16, 2019
EQ-1
EQUIPMENT PLAN
CONVERSION