




JOB NAME: BEACH HIGH SCHOOL AUDITORIUM
 3001 Higgins Street
 Savannah, Georgia 31405
 Chatham County Public School System

SHEET NAME: MECHANICAL PLANS


J. W. ROBINSON & ASSOCIATES, INC.
 ARCHITECTS • INTERIOR DESIGNERS • URBAN PLANNERS •
 1020 RALPH DAVID ABERNATHY BLVD., S.W., ATLANTA, GEORGIA 30310
 PHONE: (404) 753-4129 FAX: (404) 753-4435



18	17	16	15	14	13	12	11	10	9	8	7	6	5	4	3	2	1
201801 CHECKED: JFS 100% SCHEMATIC DESIGN DATE: SEPT. 4, 2018 DRAWN: ANM 100% DESIGN DEVELOPMENT DATE: SEPT. 4, 2018 APRIL 5, 2019 80% CONST. DOCUMENTS MAY 17, 2019 100% CONST. DOCUMENTS																	
SHEET NUMBER M1.01																	

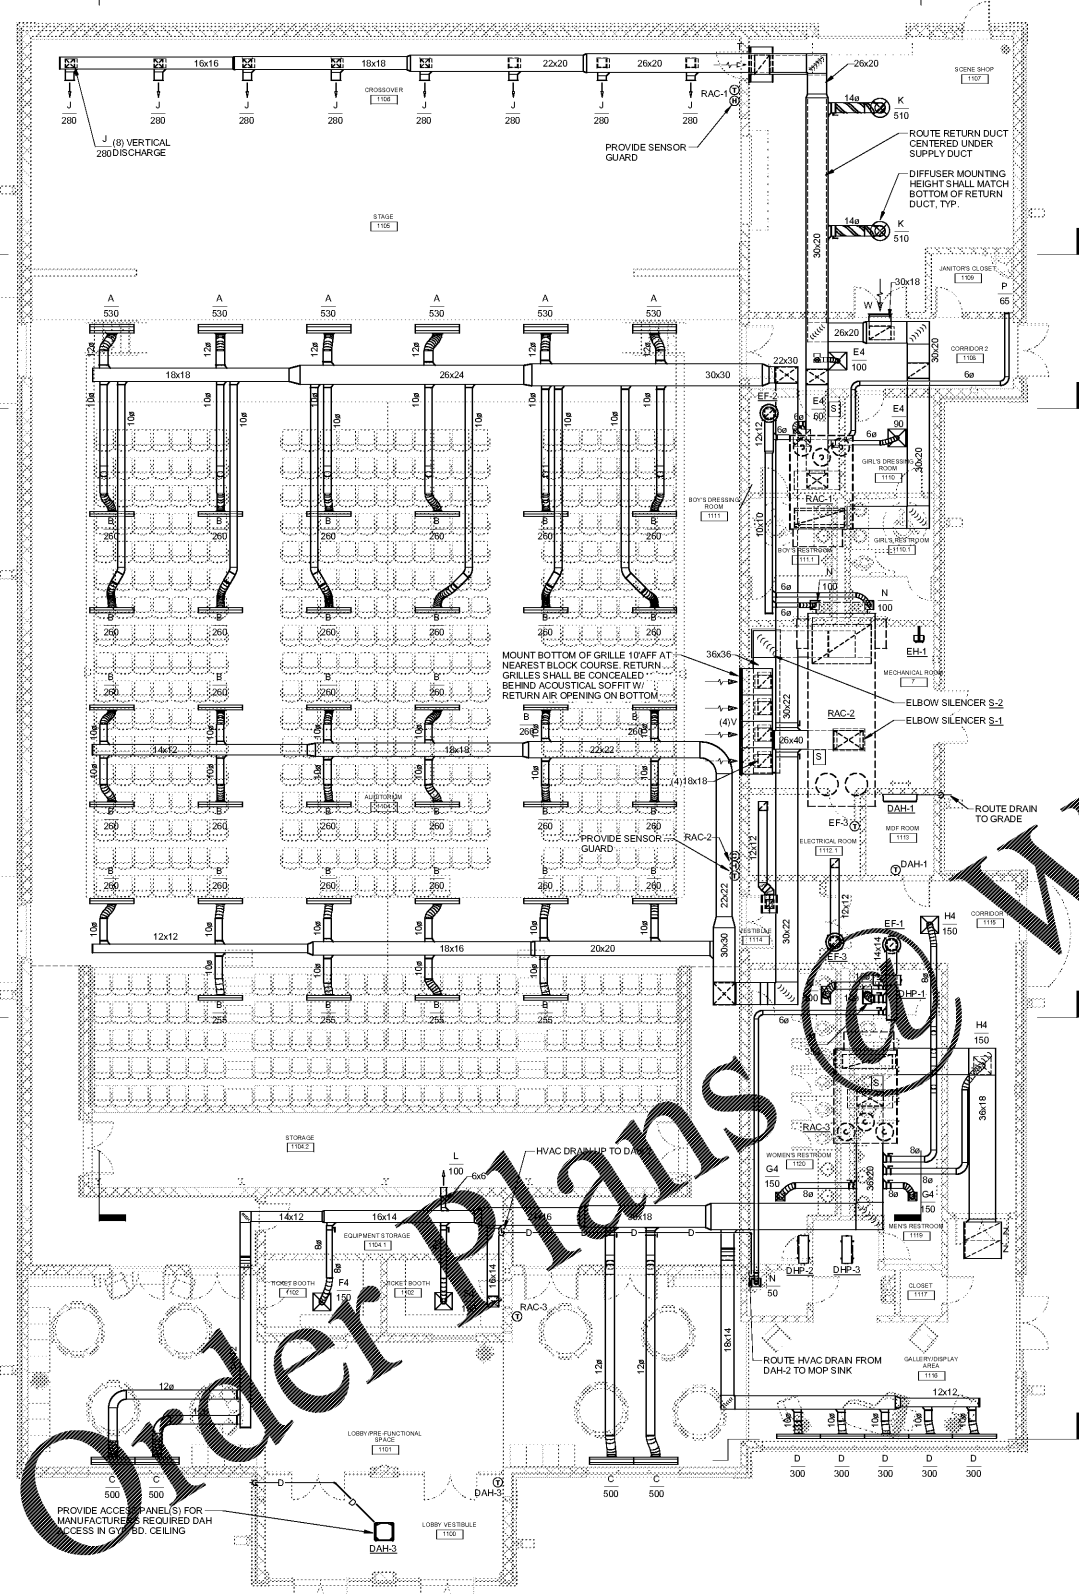

1 MECHANICAL PLAN-FIRST FLOOR
 SCALE: 1/8" = 1'-0"

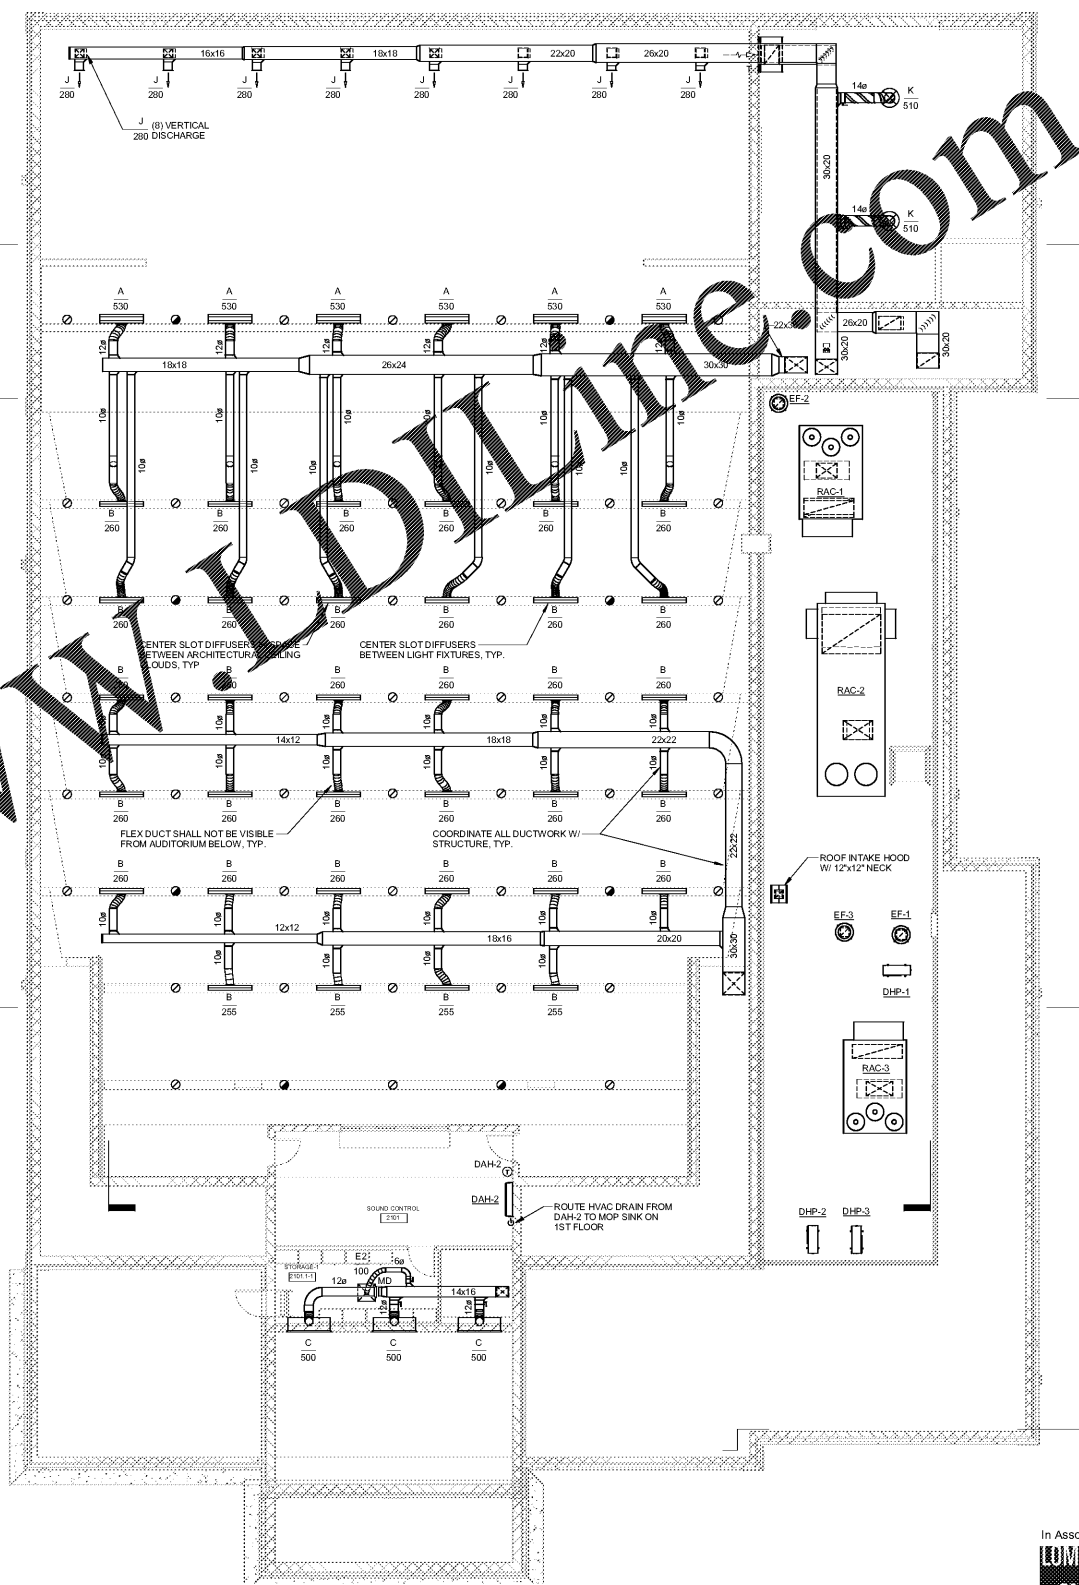

2 MECHANICAL PLAN-SECOND FLOOR
 SCALE: 1/8" = 1'-0"

In Association With

 ARCHITECTS
 301 W. Broughton St. #301
 Savannah, GA. 30401
 Ph: 912-232-5561

RELEASED FOR CONSTRUCTION
 FACILITY CODE: 625-0312