



JOB NAME: BEACH HIGH SCHOOL AUDITORIUM
 3011 Higgins Street
 Savannah, Georgia 31405
 Chatham County Public School System

SHEET NAME: PLUMBING ROOF PLAN

THIS DRAWING AND ITS REPRESENTATIONS ARE THE PROPERTY OF THE ARCHITECT AND MAY NOT BE REPRODUCED OR TRANSMITTED IN ANY FORM OR BY ANY MEANS, ELECTRONIC OR MECHANICAL, WITHOUT THE WRITTEN PERMISSION OF THE ARCHITECT.

J. W. ROBINSON & ASSOCIATES, INC.
 • ARCHITECTS • INTERIOR DESIGNERS • URBAN PLANNERS •
 1020 RALPH DAVID ABERNATHY BLVD., S.W., ATLANTA, GEORGIA 30310
 PHONE: (404) 753-4129 FAX: (404) 753-4435



In Association With


 ARCHITECTS
 301 W. Broughton St. #301
 Savannah, GA. 30401
 Ph.: 912-232-5561

JOB NO.	DATE	DESCRIPTION
201801	10/1/18	100% SCHEMATIC DESIGN
	10/1/18	100% DESIGN DEVELOPMENT
	10/1/18	80% CONST. DOCUMENTS
	10/1/18	100% CONST. DOCUMENTS

SHEET NUMBER
P3.01

RELEASED FOR CONSTRUCTION
 FACILITY CODE: 625-0312

Order Plans @ www.LDILine.com

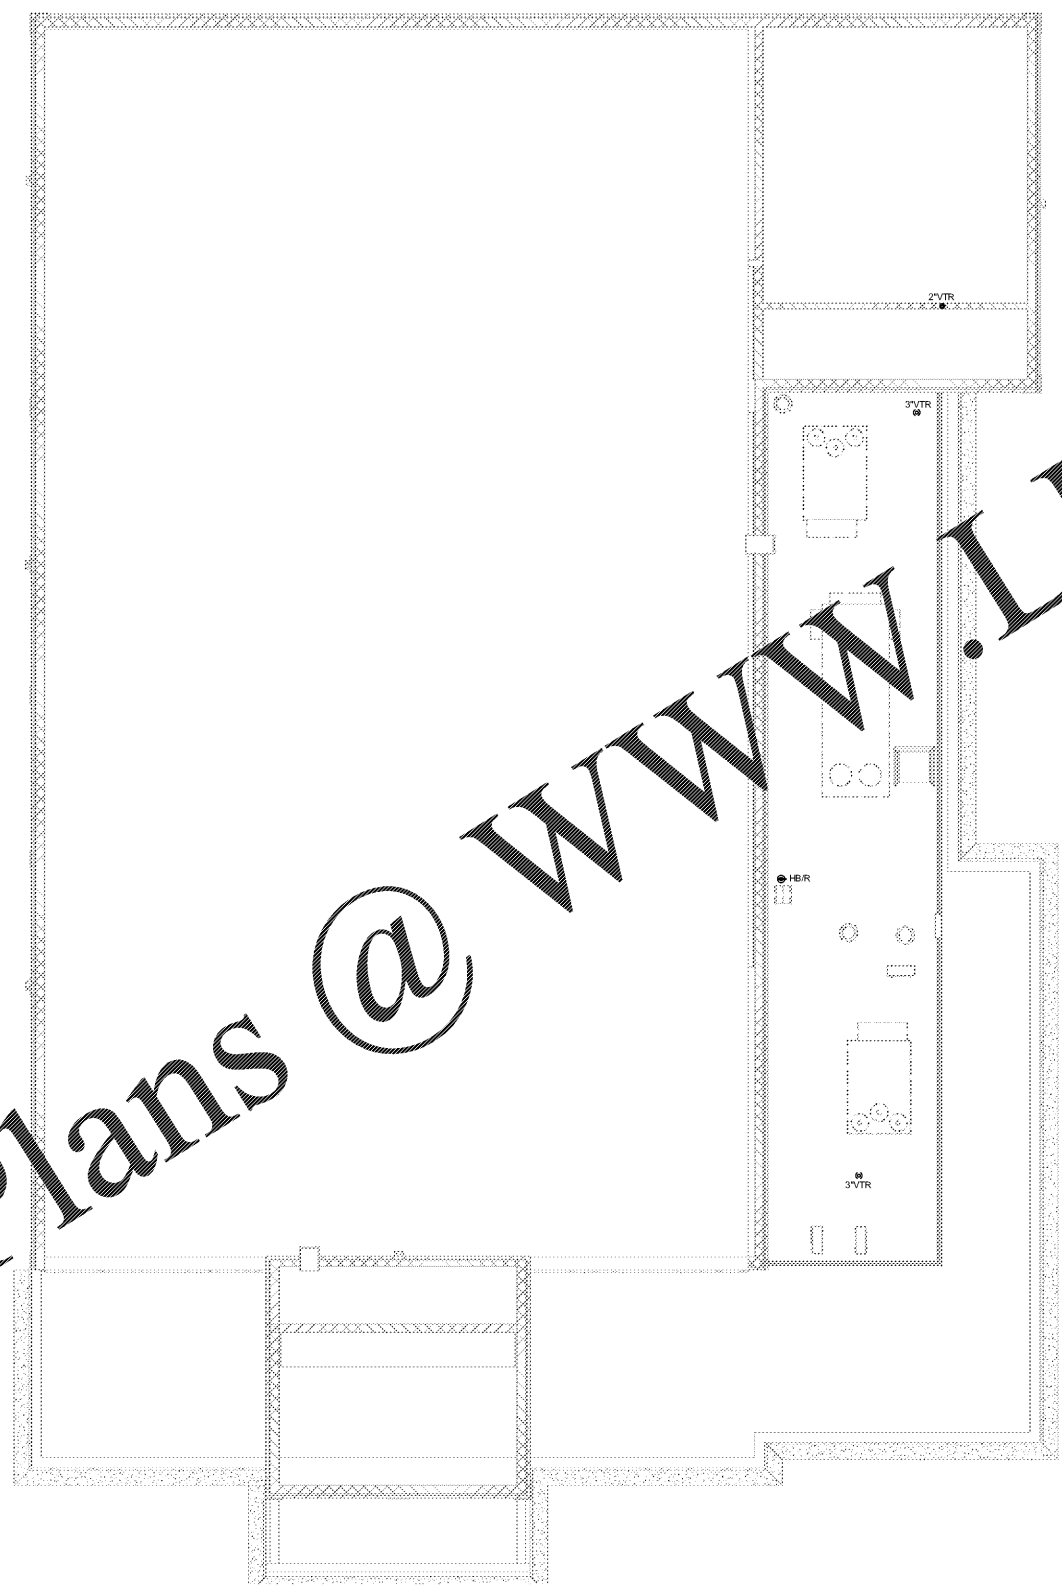

1 PLUMBING ROOF PLAN
 P3.01 SCALE: 1/8" = 1'-0"

A
B
C
D
E
F
G
H
I
J
K
L
M
N

1 2 3 4 5 6 7 8 9 10 11 12 13 14 15 16 17 18 19