



A  
B  
C  
D  
E  
F  
G  
H  
I  
J  
K  
L  
M  
N

1 2 3 4 5 6 7 8 9 10 11 12 13 14 15 16 17 18 19

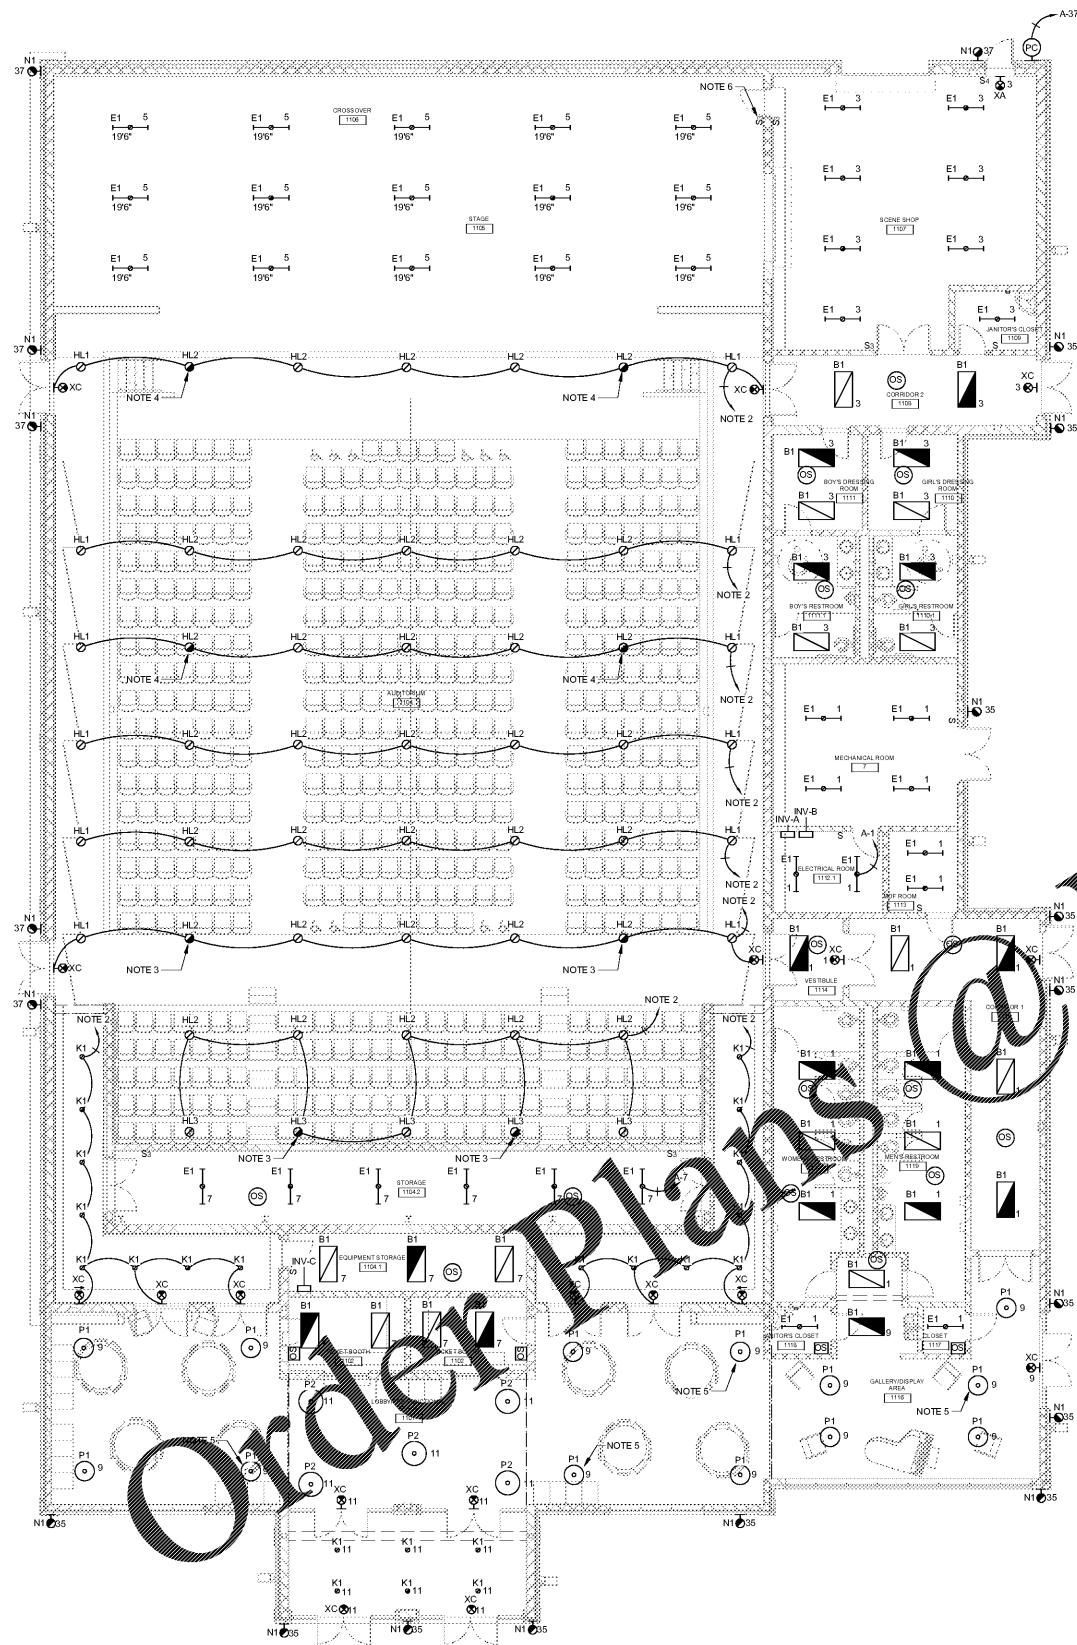

1 LIGHTING PLAN-FIRST FLOOR  
E1.01 SCALE: 1/8" = 1'-0"

- NOTES
- (GENERAL) ELECTRICAL CONTRACTOR IS RESPONSIBLE FOR ALL ROUGH-IN AND ELECTRICAL WIRING FOR THEATRICAL LIGHTING SYSTEM AND AV SYSTEM. SEE EPS SHEETS FOR ROUGH-IN RESPONSIBILITIES AND LOCATIONS FOR ELECTRICAL CONTRACTOR.
  - ROUTE TO THEATRICAL DIMMING PANEL IDP.
  - PROVIDE ETC AUTOMATIC LOAD CONTROL RELAY FOR FIXTURE. ROUTE THROUGH INVERTER "INV-A" FOR EMERGENCY POWER. INV-A SHALL BE 400W INVERTER OR HIGHER BY BODINE OR IOTA.
  - PROVIDE ETC AUTOMATIC LOAD CONTROL RELAY FOR FIXTURE. ROUTE THROUGH INVERTER "INV-B" FOR EMERGENCY POWER. INV-B SHALL BE 400W INVERTER OR HIGHER BY BODINE OR IOTA.
  - PROVIDE EMERGENCY TRANSFER DEVICE FOR FIXTURE. ROUTE THROUGH INVERTER "INV-C" FOR EMERGENCY POWER. INV-C SHALL BE 400W INVERTER OR HIGHER BY BODINE OR IOTA.
  - PROVIDE 3 WAY SWITCHES AT LOCATIONS SHOWN (ONE ON STAGE AND ONE IN SOUND CONTROL BOOTH) FOR TYPE E1 FIXTURES OVER STAGE.

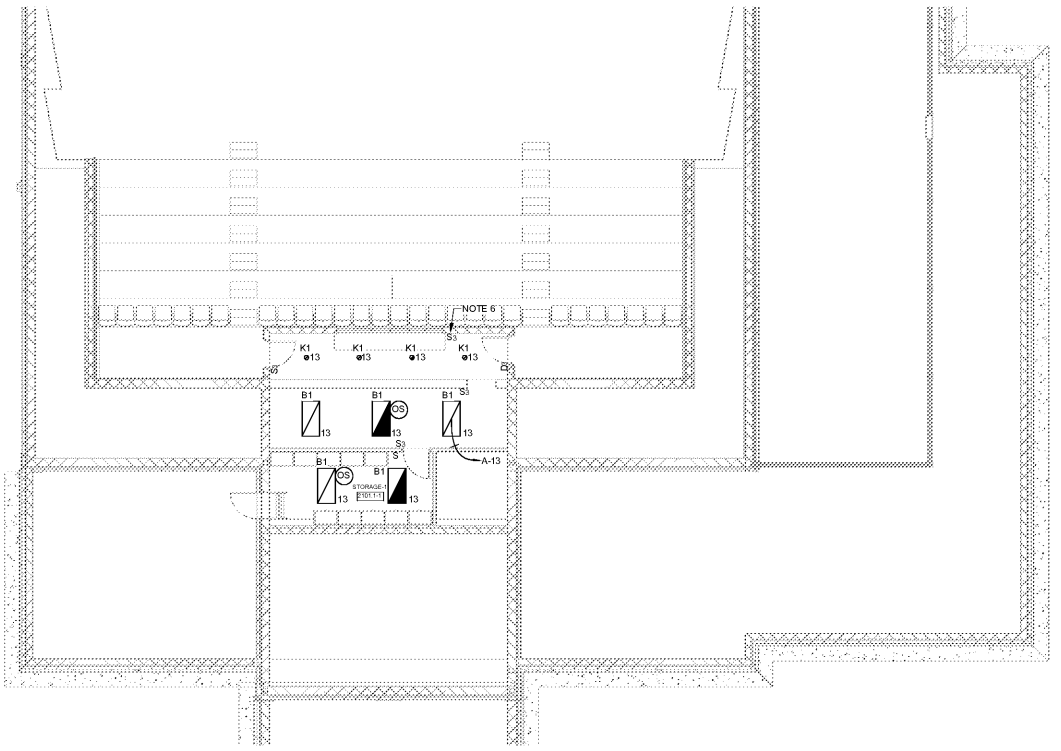

2 LIGHTING PLAN-SECOND FLOOR  
E1.01 SCALE: 1/8" = 1'-0"

Order Plans @

WWW.LDILine.com



JOB NAME: BEACH HIGH SCHOOL AUDITORIUM  
301 W. Broughton Street  
Savannah, Georgia 31405  
Chatham County Public School System

SHEET NAME: ELECTRICAL LIGHTING PLANS

THESE DRAWINGS ARE THE PROPERTY OF THE ARCHITECT AND MAY BE REPRODUCED OR TRANSMITTED IN ANY FORM OR BY ANY MEANS, ELECTRONIC OR MECHANICAL, WITHOUT PERMISSION OF THE ARCHITECT.

J. W. ROBINSON & ASSOCIATES, INC.  
ARCHITECTS • INTERIOR DESIGNERS • URBAN PLANNERS •  
1020 RALPH DAVID ABERNATHY BLVD., S.W., ATLANTA, GEORGIA 30310  
PHONE: (404) 753-4129 FAX: (404) 753-4435



DATE	DESCRIPTION
APRIL 5, 2018	100% SCHEMATIC DESIGN
APRIL 5, 2018	100% SCHEMATIC DESIGN
APRIL 5, 2018	80% CONST. DOCUMENTS
MAY 17, 2019	100% CONST. DOCUMENTS

In Association With  
**LUMINAK SMITH**  
ARCHITECTS  
301 W. Broughton St. #301  
Savannah, GA. 30401  
Ph: 912-232-5561

RELEASED FOR CONSTRUCTION  
FACILITY CODE: 625-0312

SHEET NUMBER  
E1.01