



JOB NAME: BEACH HIGH SCHOOL AUDITORIUM
 3001 Higgins Street
 Savannah, Georgia 31405
 Chatham County Public School System

SHEET NAME: ELECTRICAL POWER PLANS

THESE DRAWINGS ARE PREPARED FOR THE PROJECT OF THE ARCHITECT AND MAY BE USED FOR ANY OTHER PROJECT WITHOUT THE WRITTEN PERMISSION OF THE ARCHITECT.


J. W. ROBINSON & ASSOCIATES, INC.
 ARCHITECTS • INTERIOR DESIGNERS • URBAN PLANNERS •
 1020 RALPH DAVID ABERNATHY BLVD., S.W., ATLANTA, GEORGIA 30310
 PHONE: (404) 753-4129 FAX: (404) 753-4435



JOB NO.	201801
DRAWN: CCS	CHECKED: WOV
DATE: SEPT. 4, 2018	100% SCHEMATIC DESIGN
OCT. 29, 2018	100% DESIGN DEVELOPMENT
APRIL 5, 2019	80% CONST. DOCUMENTS
MAY 17, 2019	100% CONST. DOCUMENTS

In Association With

 ARCHITECTS
 301 W. Broughton St. #301
 Savannah, GA. 30401
 Ph: 912-232-5561

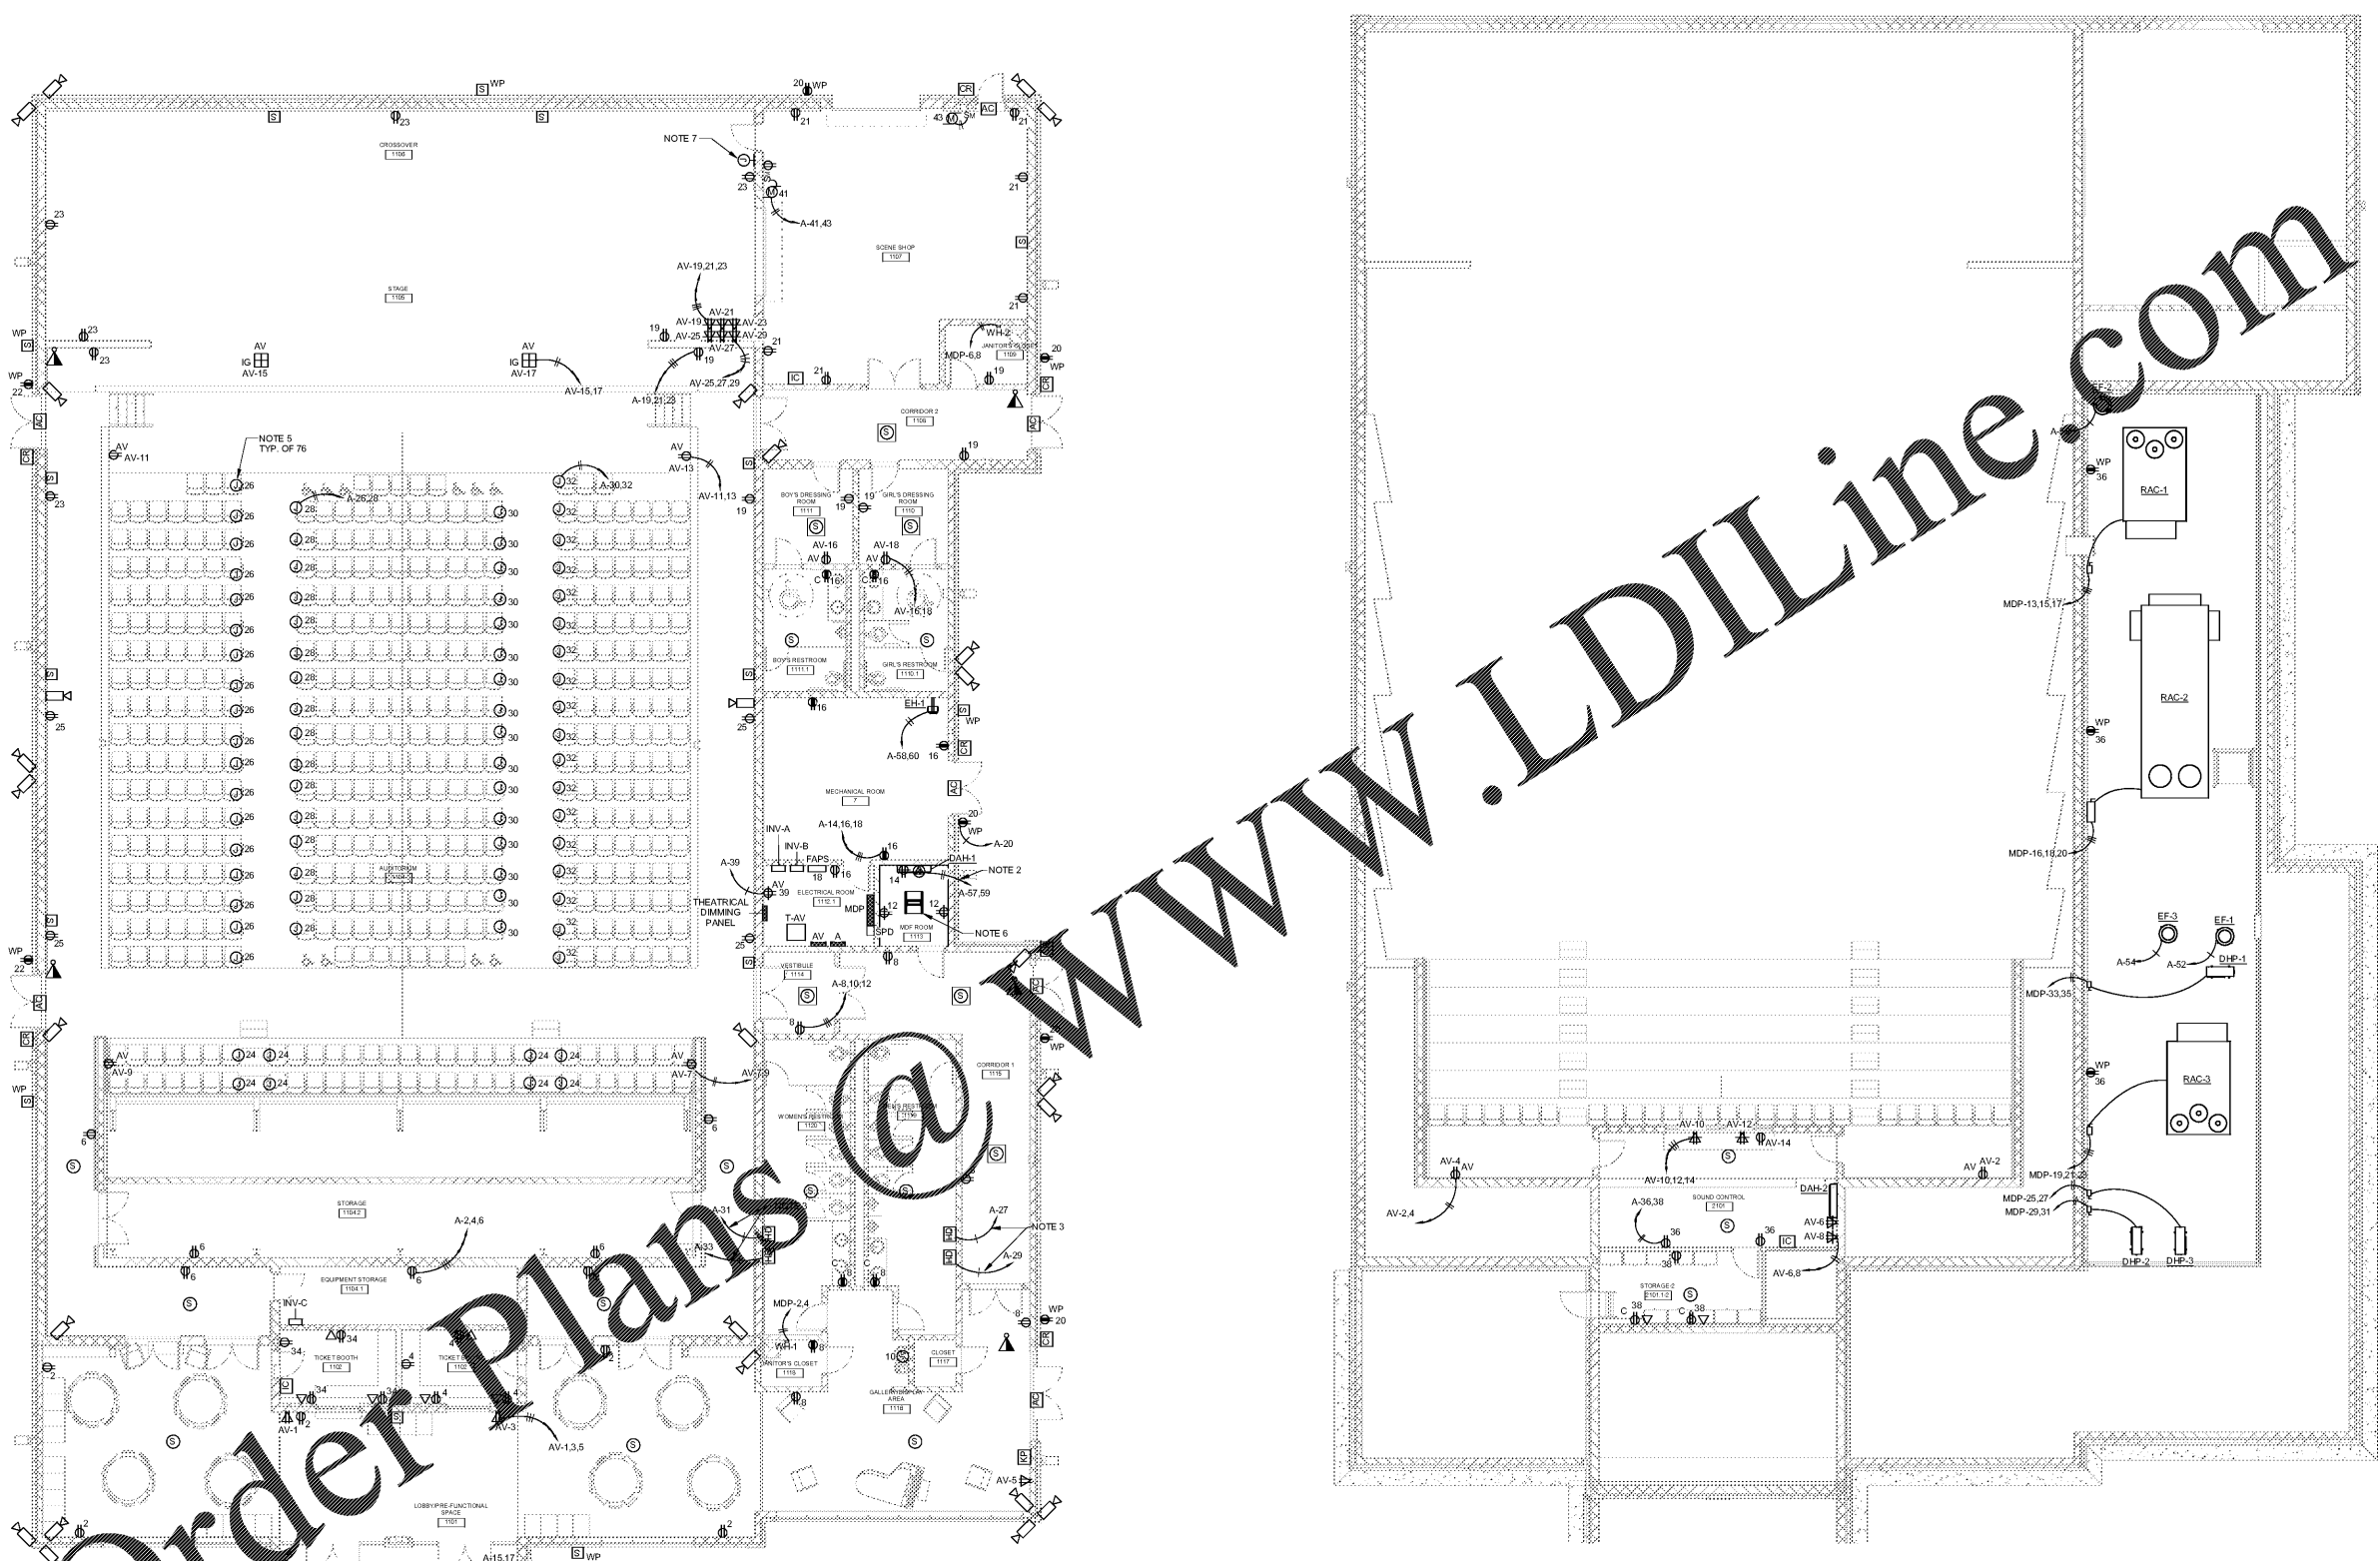

1 POWER PLAN-FIRST FLOOR
 E2.01 SCALE: 1/8" = 1'-0"

2 POWER PLAN-SECOND FLOOR
 E2.01 SCALE: 1/8" = 1'-0"

- NOTES**
- (GENERAL) ELECTRICAL CONTRACTOR IS RESPONSIBLE FOR ALL ROUGH-IN AND ELECTRICAL WIRING FOR THEATRICAL LIGHTING SYSTEM AND AV SYSTEM. SEE EPS SHEETS FOR ROUGH-IN RESPONSIBILITIES AND LOCATIONS FOR ELECTRICAL CONTRACTOR.
 - PROVIDE 2#10, #10G, 1/2". FOR UPS.
 - PROVIDE 2#10, #10G, 1/2". FOR HAND DRYERS.
 - FOR SECURITY METAL DETECTORS.
 - FOR AUDITORIUM SEAT AISLE LIGHTS. SEE DETAIL 6.65.01 FOR INSTALLATION INFORMATION. COORDINATE EXACT REQUIREMENTS WITH SEAT AISLE MANUFACTURER PRIOR TO ROUGH-IN.
 - PROVIDE 24 PORT POE SWITCH IN RACK FOR RAJLAND INTERCOM SYSTEM. PROVIDE ALL NECESSARY COMPONENTS TO COMMUNICATE WITH EXISTING INTERCOM HEADEND LOCATED IN SCHOOL OVER NETWORK. INTERCOM SHALL OVERRIDE AV SYSTEM FOR EMERGENCY CALLS. COORDINATE WITH AV INSTALLER.
 - PROVIDE 3/4" TO INTERCOM HEADEND FOR ON/OFF SWITCH FOR INTERCOM SPEAKERS IN AUDITORIUM.

RELEASED FOR CONSTRUCTION
 FACILITY CODE: 625-0312

SHEET NUMBER
E2.01