



A
B
C
D
E
F
G
H
I
J
K
L
M
N

1 2 3 4 5 6 7 8 9 10 11 12 13 14 15 16 17 18 19

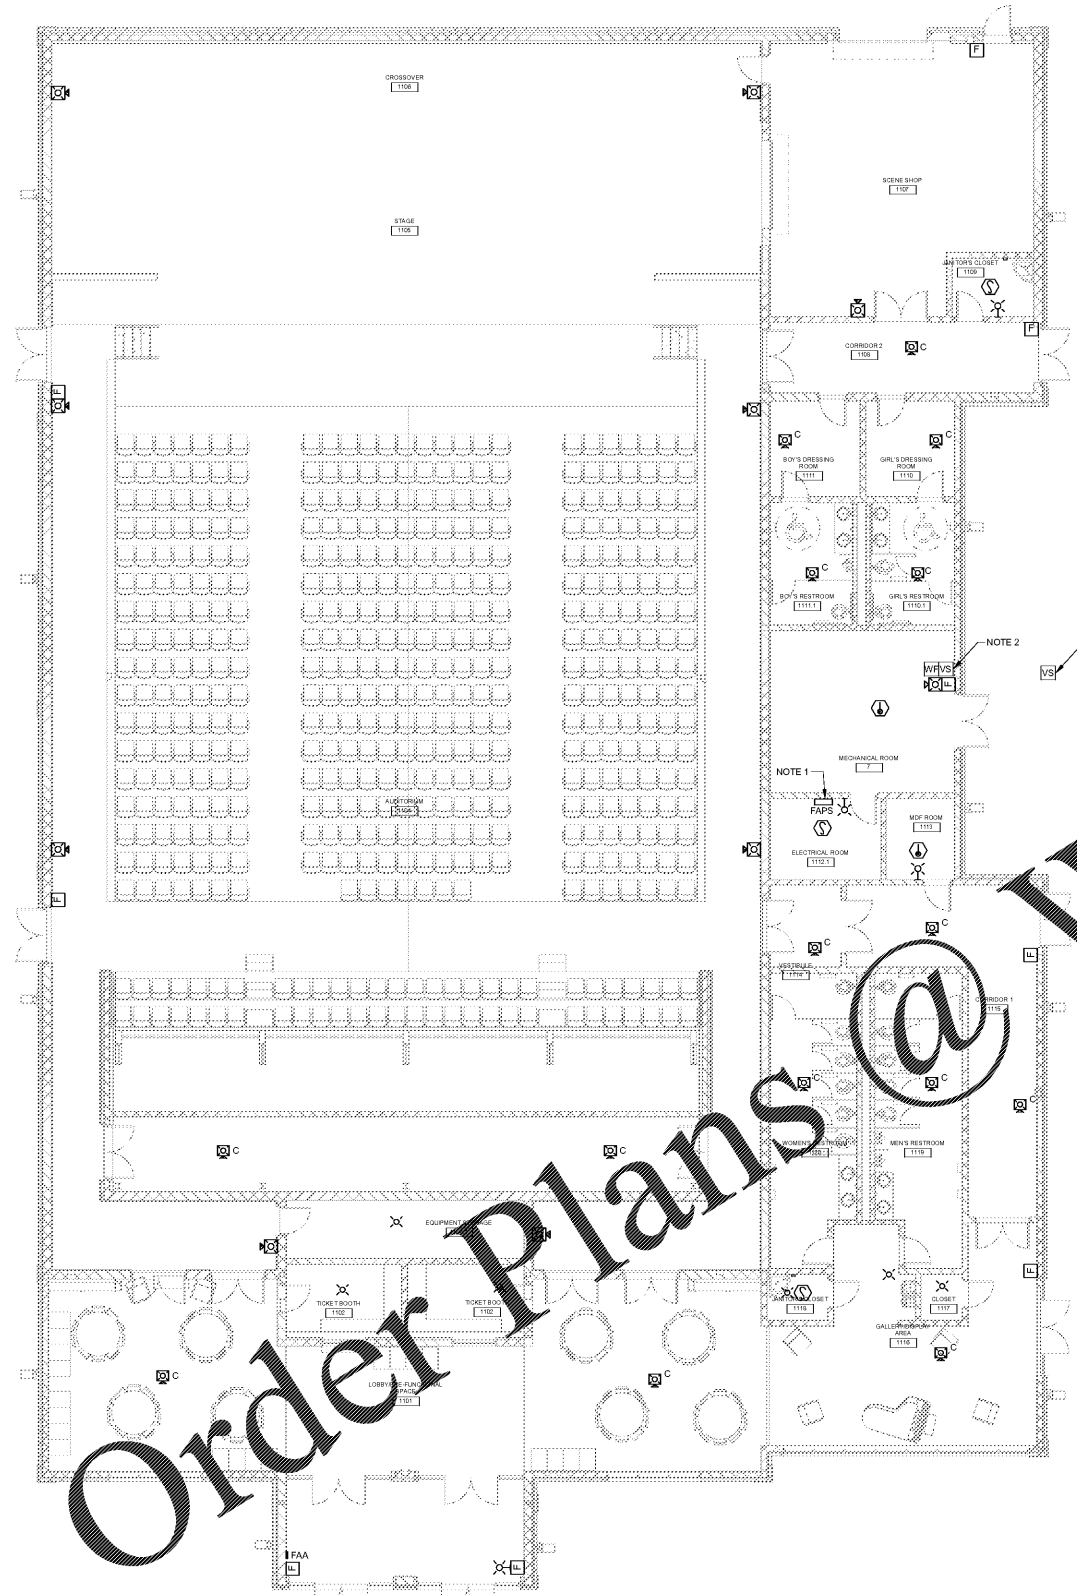

1 FIRE ALARM PLAN-FIRST FLOOR
E3.01 SCALE: 1/8" = 1'-0"

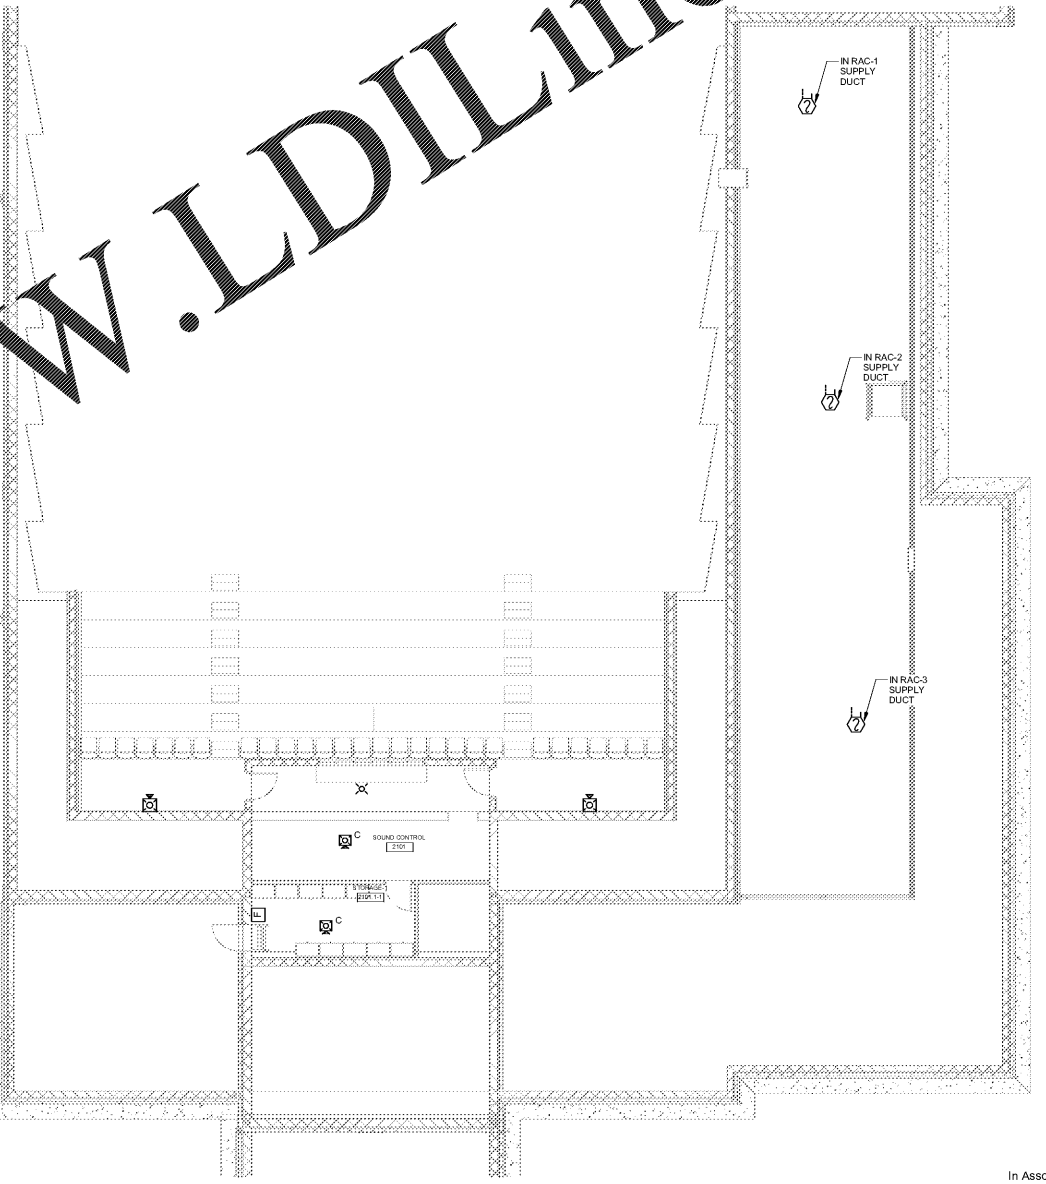

2 FIRE ALARM PLAN-SECOND FLOOR
E3.01 SCALE: 1/8" = 1'-0"

- NOTES**
1. CONNECT NEW FIRE ALARM AUXILIARY POWER SUPPLY TO EXISTING FIRE ALARM PANEL IN EXISTING SCHOOL GYM. EXISTING SYSTEM IS EDWARDS EST3. NEW SYSTEM SHALL BE BY EDWARDS AND COMPATIBLE WITH EXISTING FIRE ALARM SYSTEM. PROVIDE ALL NECESSARY COMPONENTS FOR FIRE ALARM SYSTEM TO OVERRIDE AV SYSTEM IN AUDITORIUM.
 2. PROVIDE (1) CONTROL MODULE AND (1) MONITOR MODULE FOR FLOW AND TAMPER SWITCHES AT THE FIRE RISER. COORDINATE EXACT QUANTITY AND LOCATION OF CONTROL AND MONITOR MODULES WITH FIRE RISER INSTALLER.
 3. PROVIDE (1) MONITOR MODULE FOR PIV. COORDINATE EXACT LOCATION OF PIV WITH CIVIL CONTRACTOR.



JOB NAME: BEACH HIGH SCHOOL AUDITORIUM
3001 Higgins Street
Savannah, Georgia 31405
Chatham County Public School System

SHEET NAME: ELECTRICAL FIRE ALARM PLANS

THESE DRAWINGS ARE THE PROPERTY OF THE ARCHITECT AND MAY BE USED ONLY FOR THE PROJECT AND SITE SPECIFICALLY IDENTIFIED HEREIN.

J. W. ROBINSON & ASSOCIATES, INC.
• ARCHITECTS • INTERIOR DESIGNERS • URBAN PLANNERS •
1020 RALPH DAVID ABERNATHY BLVD., S.W., ATLANTA, GEORGIA 30310
PHONE: (404) 753-4129 FAX: (404) 753-4435



JOB NO.	201801
DRAWN: CCS	CHECKED: WOV
DATE: SEPT. 4, 2018	100% SCHEMATIC DESIGN
OCT. 29, 2018	100% DESIGN DEVELOPMENT
APRIL 5, 2019	80% CONST. DOCUMENTS
MAY 17, 2019	100% CONST. DOCUMENTS

In Association With
LUMMAK SMITH
ARCHITECTS
301 W. Broughton St. #301
Savannah, GA. 30401
Ph: 912-232-5561

RELEASED FOR CONSTRUCTION
FACILITY CODE: 625-0312

SHEET NUMBER
E3.01