
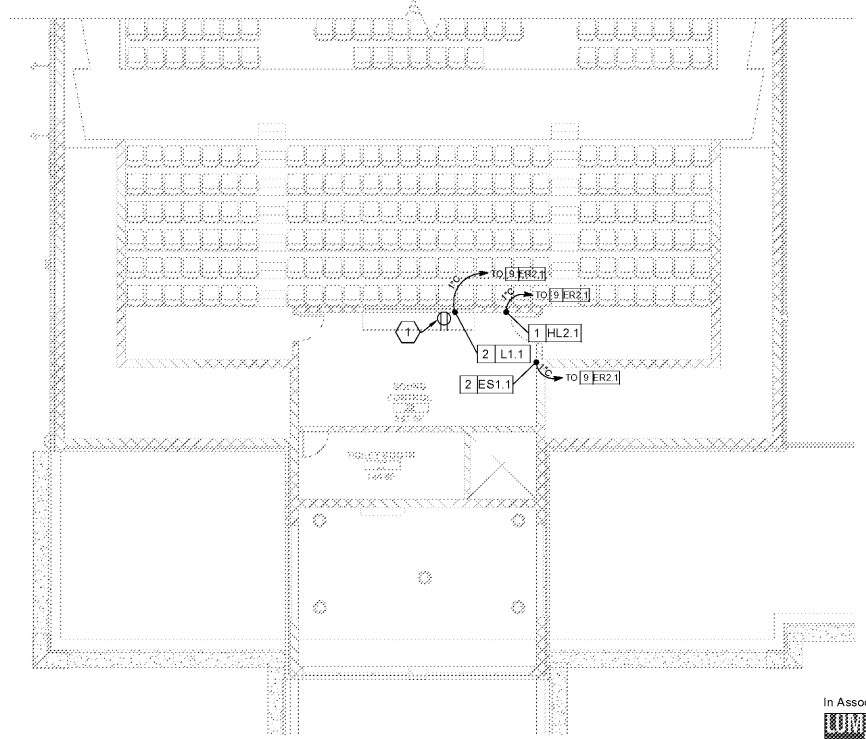


- SHEET KEY NOTES**
- (QTY. OF 1) 20A 120VAC CIRCUIT ON DUPLEX RECEPTACLE MOUNTED A.F.C. BY E.C.
 - (QTY. OF 1) 20A 120VAC CIRCUIT ON QUAD RECEPTACLE MOUNTED IN BACK PLANE OF EQUIPMENT RACK BY E.C.

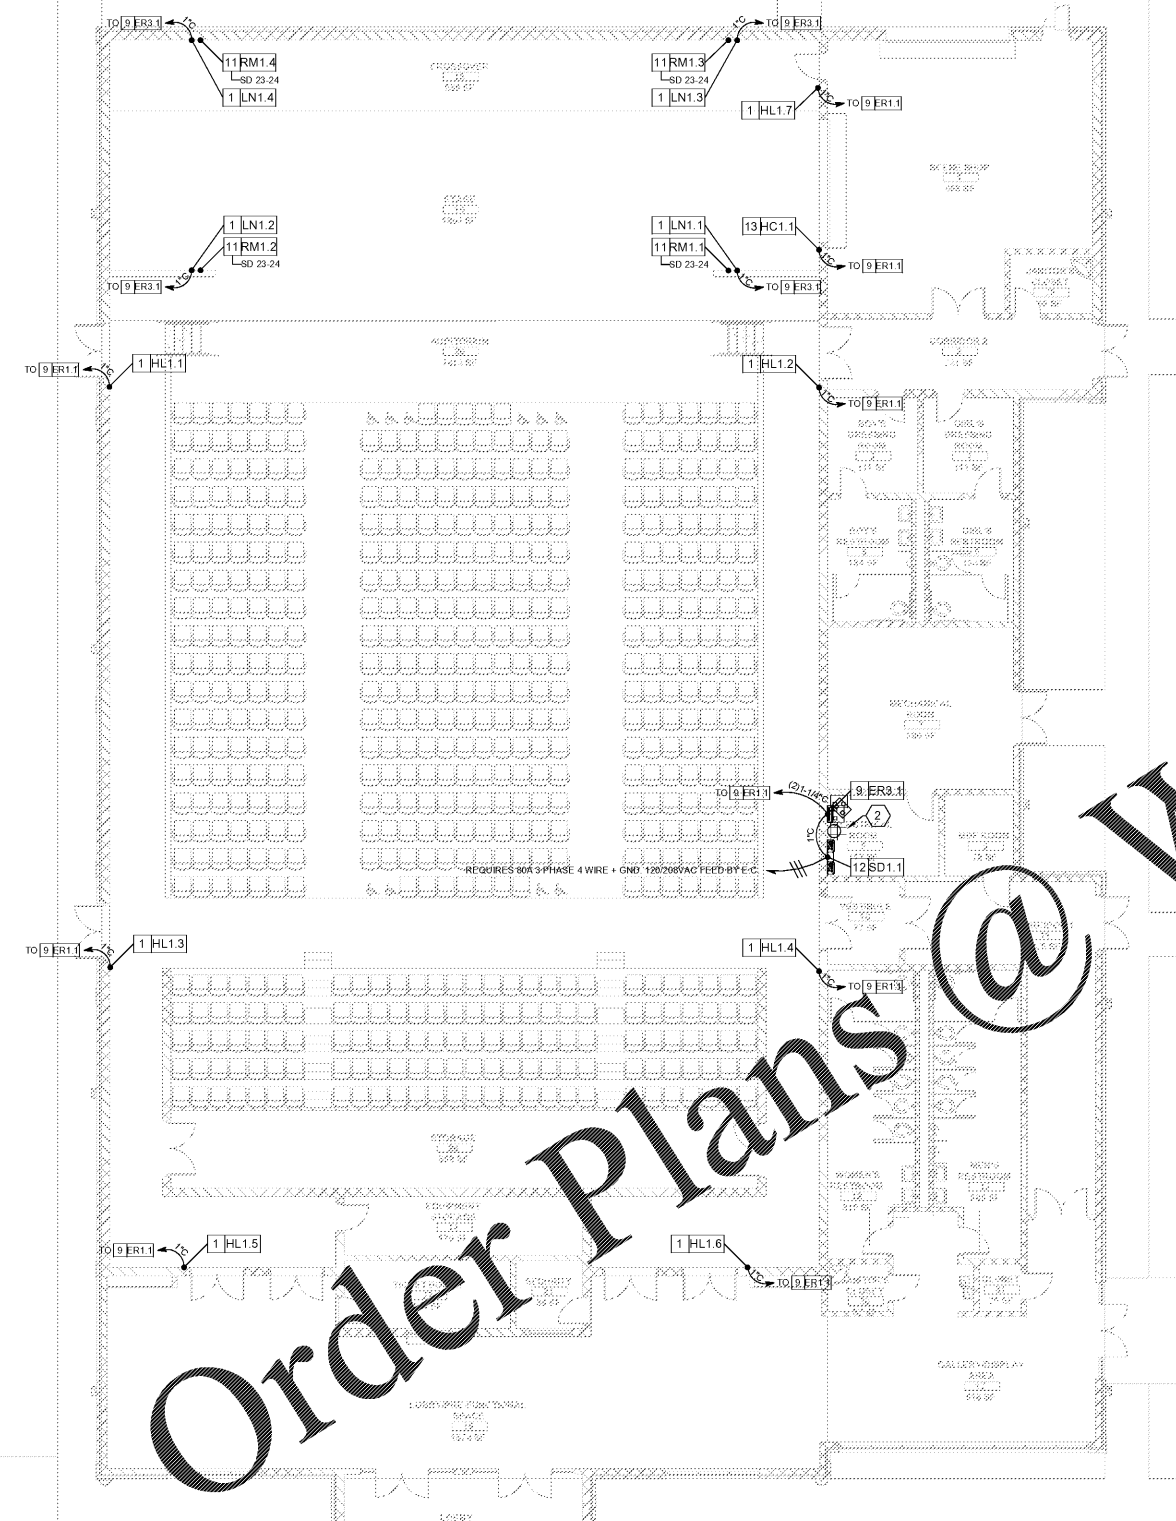

Order Plans @ www.LDILine.com

www.LDILine.com

JOB NAME: BEACH HIGH SCHOOL AUDITORIUM
 3001 Hopkins Street
 Savannah, Georgia 31405
 Chatham County Public Schools System

SHEET NAME: LIGHTING INFRASTRUCTURE FP

J. W. ROBINSON & ASSOCIATES, INC.
 • ARCHITECTS • INTERIOR DESIGNERS • URBAN PLANNERS •
 1020 RALPH DAVID ABERNATHY BLVD., S.W., ATLANTA, GEORGIA 30310
 PHONE: (404) 753-4129 FAX: (404) 753-4435



In Association With

 301 W. Broughton St. #301
 Savannah, GA 30401
 Ph.: 912-232-5561

NO.	DATE	DESCRIPTION	BY	CHKD.
1	SEPT. 4, 2018	100% SCHEMATIC DESIGN		
2	OCT. 29, 2018	100% DESIGN DEVELOPMENT		
3	APRIL 5, 2019	80% CONSTRUCTION DOCS		
4	MAY 15, 2019	100% CONSTRUCTION DOCS		

1 FIRST FLOOR - LIGHTING INFRASTRUCTURE FLOOR PLAN
 1/8" = 1'-0"

2 SECOND FLOOR - LIGHTING INFRASTRUCTURE FLOOR PLAN
 1/8" = 1'-0"

NOT RELEASED FOR CONSTRUCTION
 FACILITY CODE: 625-0312

201801
 SHEET NUMBER
 EPS-1.2