


THIS SHEET PLOTS ON 22" x 34" ANSI D 1/2" = 1'-0" 0 1/2" 1" 2" 3" 4" 5" 6" 7" 8" 9" 10" 11" 12" 13" 14" 15" 16" 17" 18" 19" N M L K J I H G F E D C B A

P:\COMMERCIAL\2016 PROJECT IN-BOX\2016-139 New Restaurant at Durr Field\5. Drawing Info.c. Revit\16139 Durr Field Restrooms - PLMG.rvt
 © Copyright 2016 by Croft & Associates, PC. All rights reserved. This document is property of Croft & Associates, PC. It is to be used only for the specific project referred to or identified herein and is not to be used on other projects, in whole or in part, except by the express written agreement of Croft & Associates, PC.

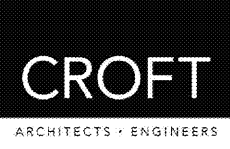

Croft & Associates
 3400 Blue Springs Road, Suite 200
 Kennesaw, Georgia 30144
 770.529.7714 (p) 770.529.7716 (f)
 www.croftandassociates.com



03/28/2018
 In accordance with GA R&R Dept.
 180 §12 - Sealing of Documents

OWNER
CITY OF ACWORTH
 4415 SENATOR RUSSELL AVENUE
 ACWORTH, GEORGIA 30101




DURR FIELD
 4757 - 4805 SCHOOL STREET
 ACWORTH, GEORGIA 30101

0	2018-03-12	ISSUED FOR CONSTRUCTION
	2016-07-22	100% SET
A	2016-07-08	REVIEW
No.	Date	Description
ISSUANCE		


PROJECT NUMBER
16139
 DRAWN: MDJ
 CHECKED: JKM

SHEET TITLE
PLUMBING PLAN


SHEET NO.
P-101

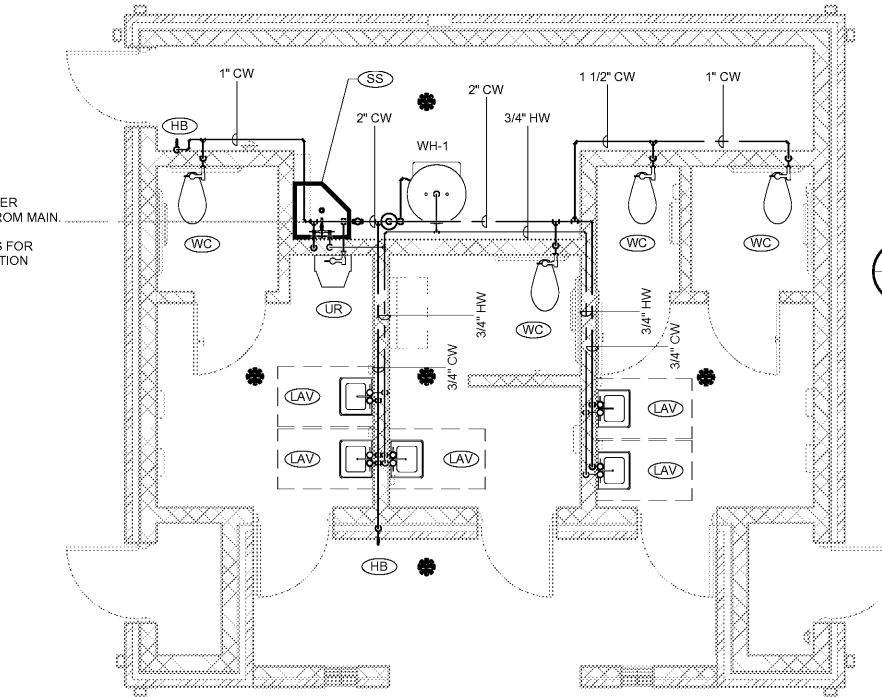


H2 P-101
DOMESTIC WATER PLAN
 1/4" = 1'-0"

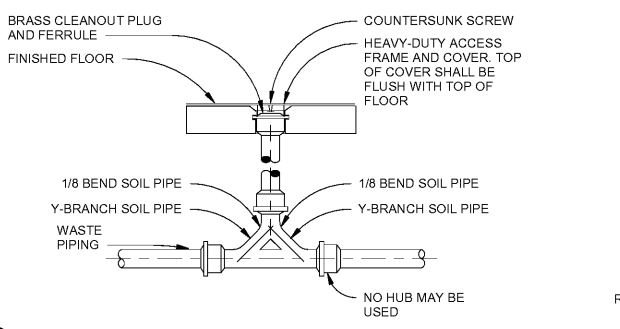


K7 P-101
TYPICAL 2-WAY EXTERIOR CLEANOUT DETAIL
 NOT TO SCALE

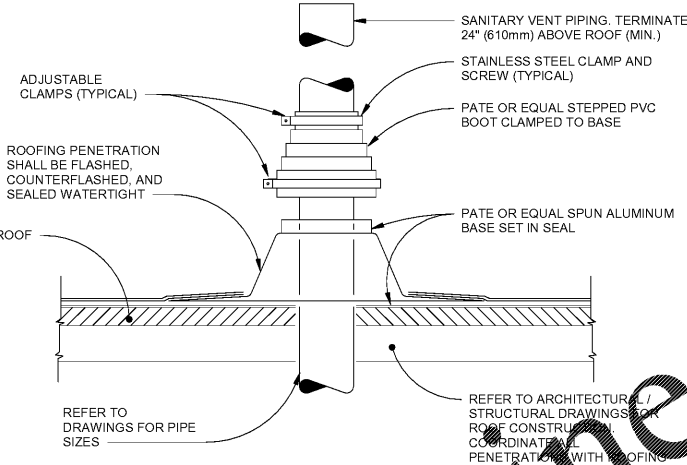


J12 P-101
TYPICAL SANITARY VENT THRU ROOF DETAIL
 NOT TO SCALE

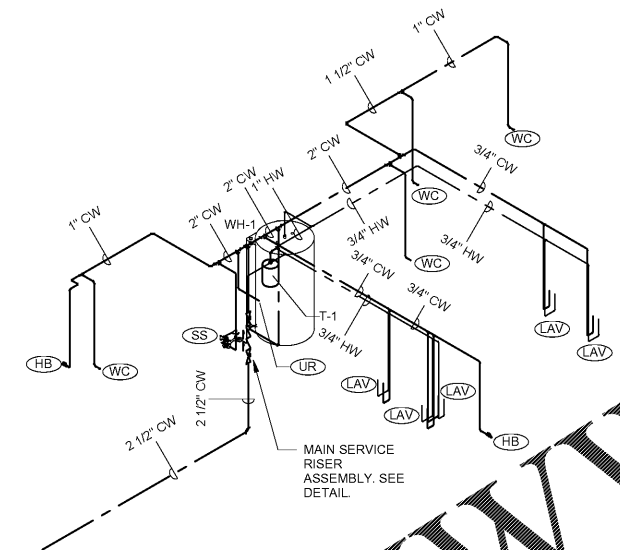


G7 P-101
DOMESTIC WATER RISER

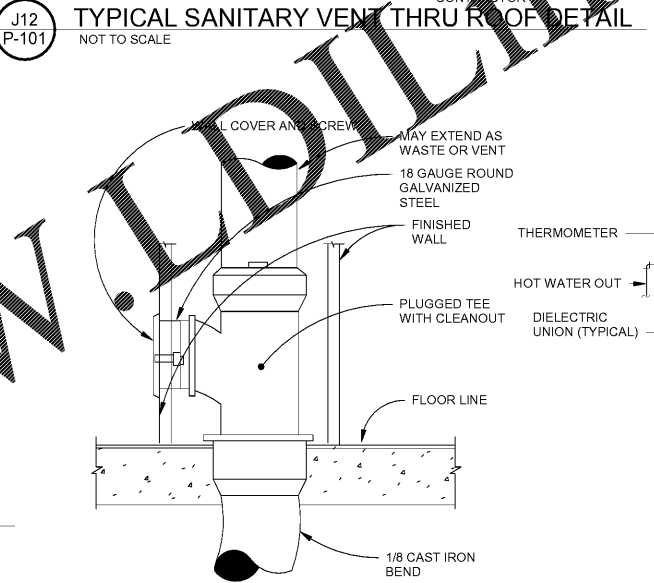


F13 P-101
TYPICAL WALL CLEANOUT DETAIL
 NOT TO SCALE

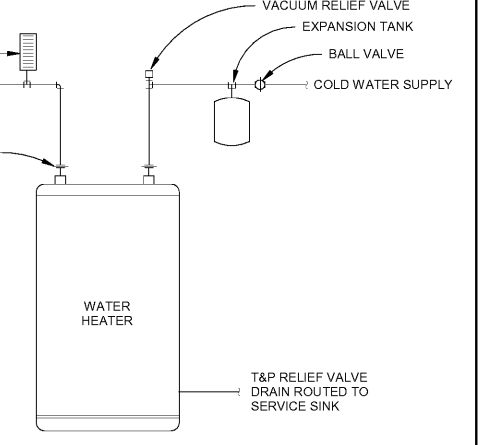


F16 P-101
TANK-TYPE HOT WATER HEATER DETAIL
 NOT TO SCALE

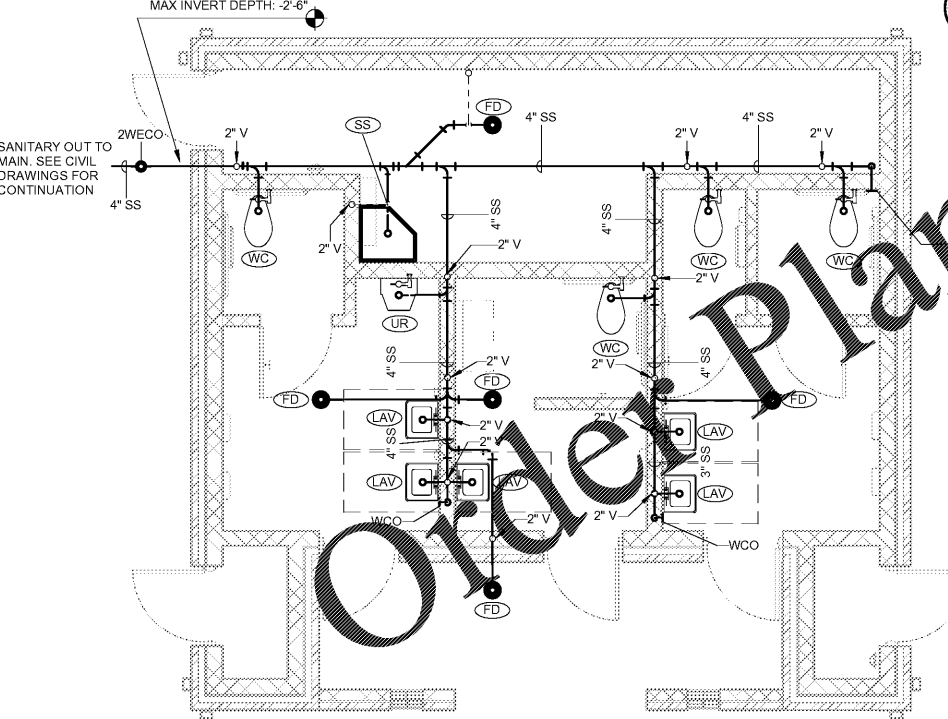


A2 P-101
SANITARY & VENT PLAN
 1/4" = 1'-0"

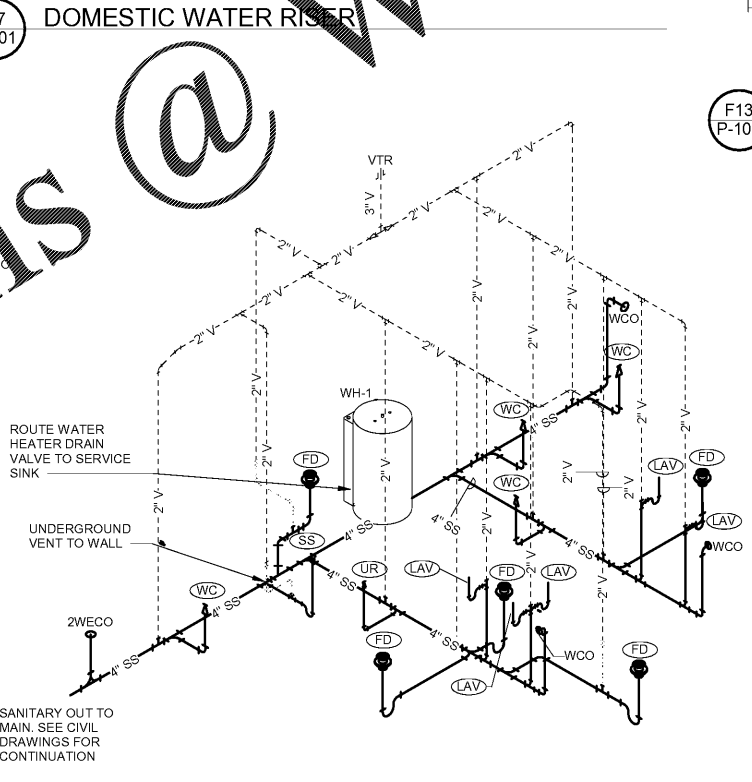


A7 P-101
SANITARY & VENT RISER

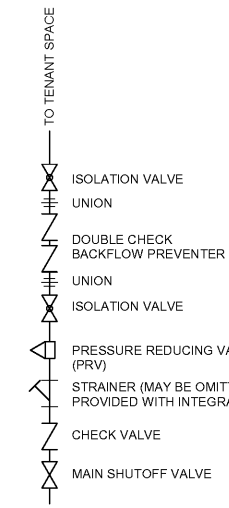

A13 P-101
TYPICAL WATER MAIN SHUTOFF DETAIL
 NOT TO SCALE

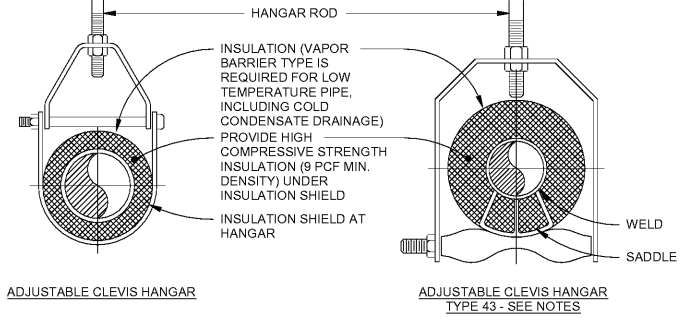

A15 P-101
TYPICAL PIPE HANGER DETAIL
 NOT TO SCALE

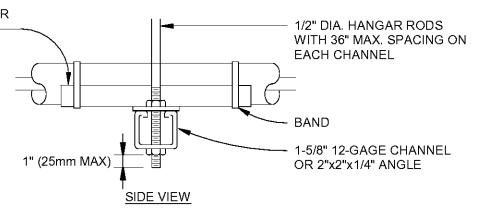

TRAPEZE HANGER FOR UP TO 1000 LB. UNIFORM LOAD