


② REFLECTED CEILING PLAN - FIRST FLOOR - PART C  
3/32" = 1'-0"

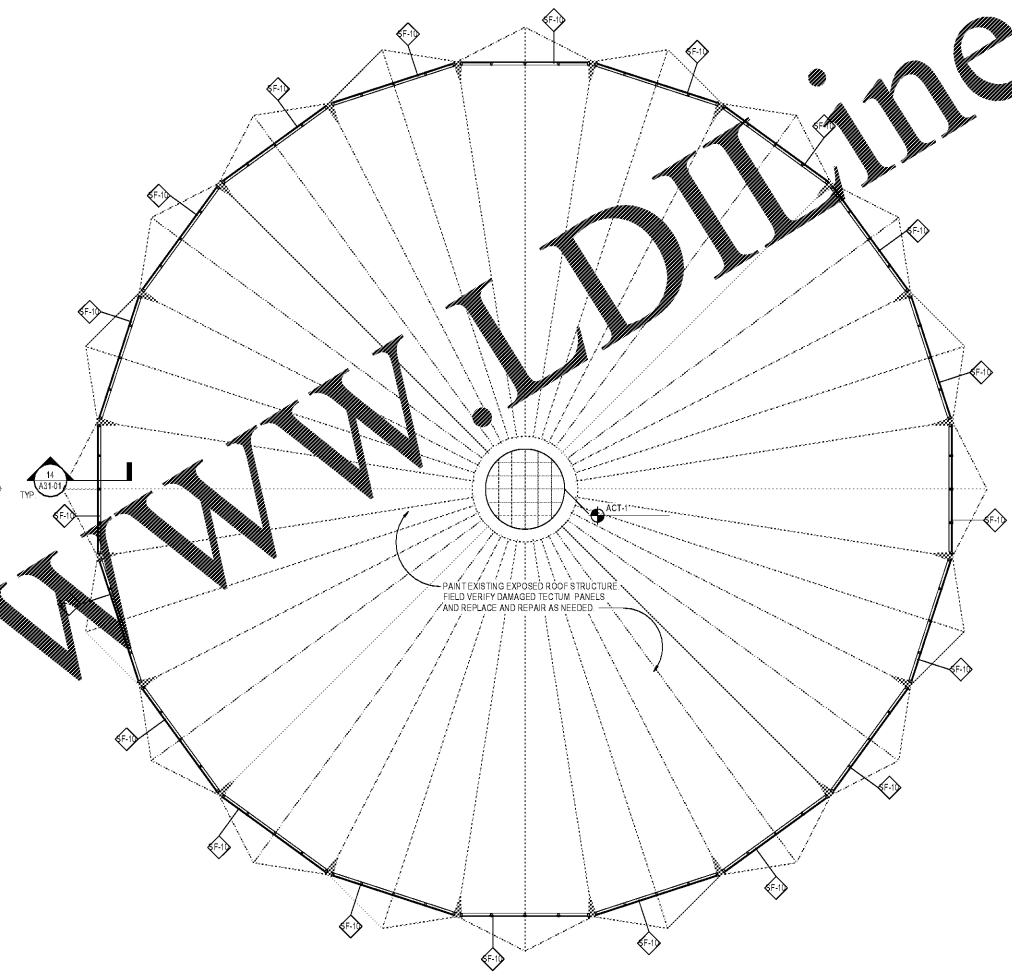

① REFLECTED CEILING PLAN - GYM ROOF  
3/32" = 1'-0"

RCP PLAN GENERAL NOTES

- DESIGN INTENT TO MATCH NEW CEILING HEIGHTS WITH EXISTING CEILING HEIGHTS. FOR AREAS WHERE CEILING HEIGHTS DIFFER FROM EXISTING CONDITIONS, ALL DEVICES AND SPRINKLER HEADS SHALL BE ADJUSTED TO MATCH NEW CEILING HEIGHTS.
- SPRINKLER HEAD LOCATIONS ARE NOT SHOWN ON ARCHITECTURAL REFLECTED CEILING PLANS (BUILDING IS TO BE "FULLY SPRINKLERED") PER NFPA-13 AND OWNER'S INSURANCE COMPANY'S REQUIREMENTS.
- SEE ELECTRICAL DRAWINGS FOR THE LOCATIONS OF CEILING MOUNTED SMOKE DETECTORS, SPRINKLERS, EXIT SIGNAGE, FIRE ALARM DEVICES, WALL MOUNTED EXIT LIGHTS, CLOCKS, ETC.
- REFER TO ENLARGED PLANS, SECTIONS, ELEVATIONS, AND DETAILS FOR ADDITIONAL DIMENSIONS.
- COORDINATE GYPSUM BOARD FURR DOWN HEIGHTS WITH FULL-HEIGHT CABINETS AND INTERIOR ELEVATIONS.
- 18" MINIMUM VERTICAL CLEARANCE SHALL BE MAINTAINED BETWEEN THE BOTTOM OF EXTENDED SPRINKLER HEADS AND THE TOP OF FILES, SHELVING, LOCKERS, ETC.
- THE CONTRACTOR SHALL VERIFY THAT ACCESS PANELS OF TYPE SPECIFIED ARE INSTALLED IN NON-ACCESSIBLE TYPE LOCATIONS. SERVICE ADJUSTMENT TO MECHANICAL PLUMBING OR ELECTRICAL SYSTEMS MAY REQUIRE ACCESS PANELS SHALL BE OF THE RATED EQUAL TO THE RATING OF THE CEILING IN WHICH THEY OCCUR.
- REFER TO INTERIOR FINISH PLANS AND SPECIFICATIONS FOR FINISH MATERIAL INFORMATION.
- PANEL ACCESS PANELS P-1 UNLESS OTHERWISE NOTED.
- ELECTRICAL FOR THE GYM, AV STOR LIGHTING.
- EXISTING EXTERIOR CANOPIES THAT RECEIVE NEW LIGHTS ARE TO BE PAINTED TO MATCH EXISTING COLOR.

RCP LEGEND

- NOT IN SCOPE
- SUSPENDED 2 X 7 ACOUSTICAL CEILING SYSTEM
- SUPPLY AIR GRILLE REFER TO MECHANICAL DRAWINGS FOR ADDITIONAL INFORMATION
- RETURN AIR GRILLE REFER TO MECHANICAL DRAWINGS FOR ADDITIONAL INFORMATION
- EXHAUST AIR GRILLE REFER TO MECHANICAL DRAWINGS FOR ADDITIONAL INFORMATION
- SUPPLY STRIP DIFFUSER RE: MECHANICAL
- CONTROL JOINT
- CEILING DETAIL / SECTION TAG
- 9'-0" AFF. CEILING HEIGHT DESIGNATION PER AREA. WHERE NO HEIGHT IS DESIGNATED, ASSUME MATCH EXISTING HEIGHT
- 9'-0" AFF.(E) EXISTING CEILING (E)
- WALL MOUNTED LIGHT FIXTURE
- GYPSUM BOARD CEILING
- EXPOSED CONCRETE STRUCTURE
- B-1 BINDS TO MATCH EXISTING
- COVE FIXTURES - SEE ELECTRICAL
- EXIT SIGN - SEE ELECTRICAL
- EXIT SIGN W/ ARROW - SEE ELECTRICAL
- EMERGENCY LIGHT FIXTURE
- SMOKE DETECTOR

RCP KEY NOTES

- NO CUT ACT TILES AT PERIMETER
- COORDINATE CEILING WITH STAGE LIGHTING
- PROVIDE PROJECTOR
- EXPOSED STRUCTURE ABOVE CEILING TO BE PAINTED - COLOR TBD
- PROVIDE PROJECTOR - COORDINATE WITH DATA/ELEC
- COORDINATE CEILING OPENING FOR STAGE LIGHTING WITH ELECTRICAL
- NO THROUGH WALL PENETRATIONS

PERKINS + WILL

1315 Peachtree St NE  
Atlanta, GA 30309  
T 404.873.2800  
F 404.873.2823  
www.perkinswill.com

CONSULTANTS

civil  
Breadlove Land Planning  
15 Simpson St NW, Atlanta, GA 30308

structural  
Lizaj+Cass  
1200 Peachtree St NE, Suite 2500, Atlanta, GA 30309

MPE  
Matheson Bai & Associates  
11285 Elkins Rd., Suite F3, Roswell, GA 30076

LANDSCAPING  
Perkins+Wili  
1315 Peachtree St NE, Atlanta, GA 30309

FF&A  
Camacho  
3103 Medlock Bridge Road, Norcross, GA 30071

OWNER  
KIPP Metro Atlanta Schools  
1445 Maynard Road NW, Atlanta, GA 30331

PROJECT


CONTRACTOR

RELEASED FOR CONSTRUCTION 06/07/2019

KIPP ATLANTA COLLEGIATE - Addition and Renovations  
98 Anderson Ave NW  
Atlanta GA 30314



KEYPLAN

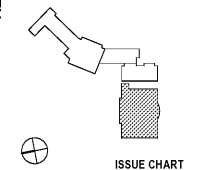

ISSUE CHART

DATE	REVISION	DATE
8/7/2019 5:30:04 PM		

Job Number 801660.000  
Drawn Author  
Checked Checker  
Approved Approver

TITLE

REFLECTED CEILING PLAN - FIRST FLOOR - PART C

SHEET NUMBER

A12-01C  
Copyright © 2019 Perkins+Will