


Order Plans @ [www.LDILine.com](http://www.LDILine.com)

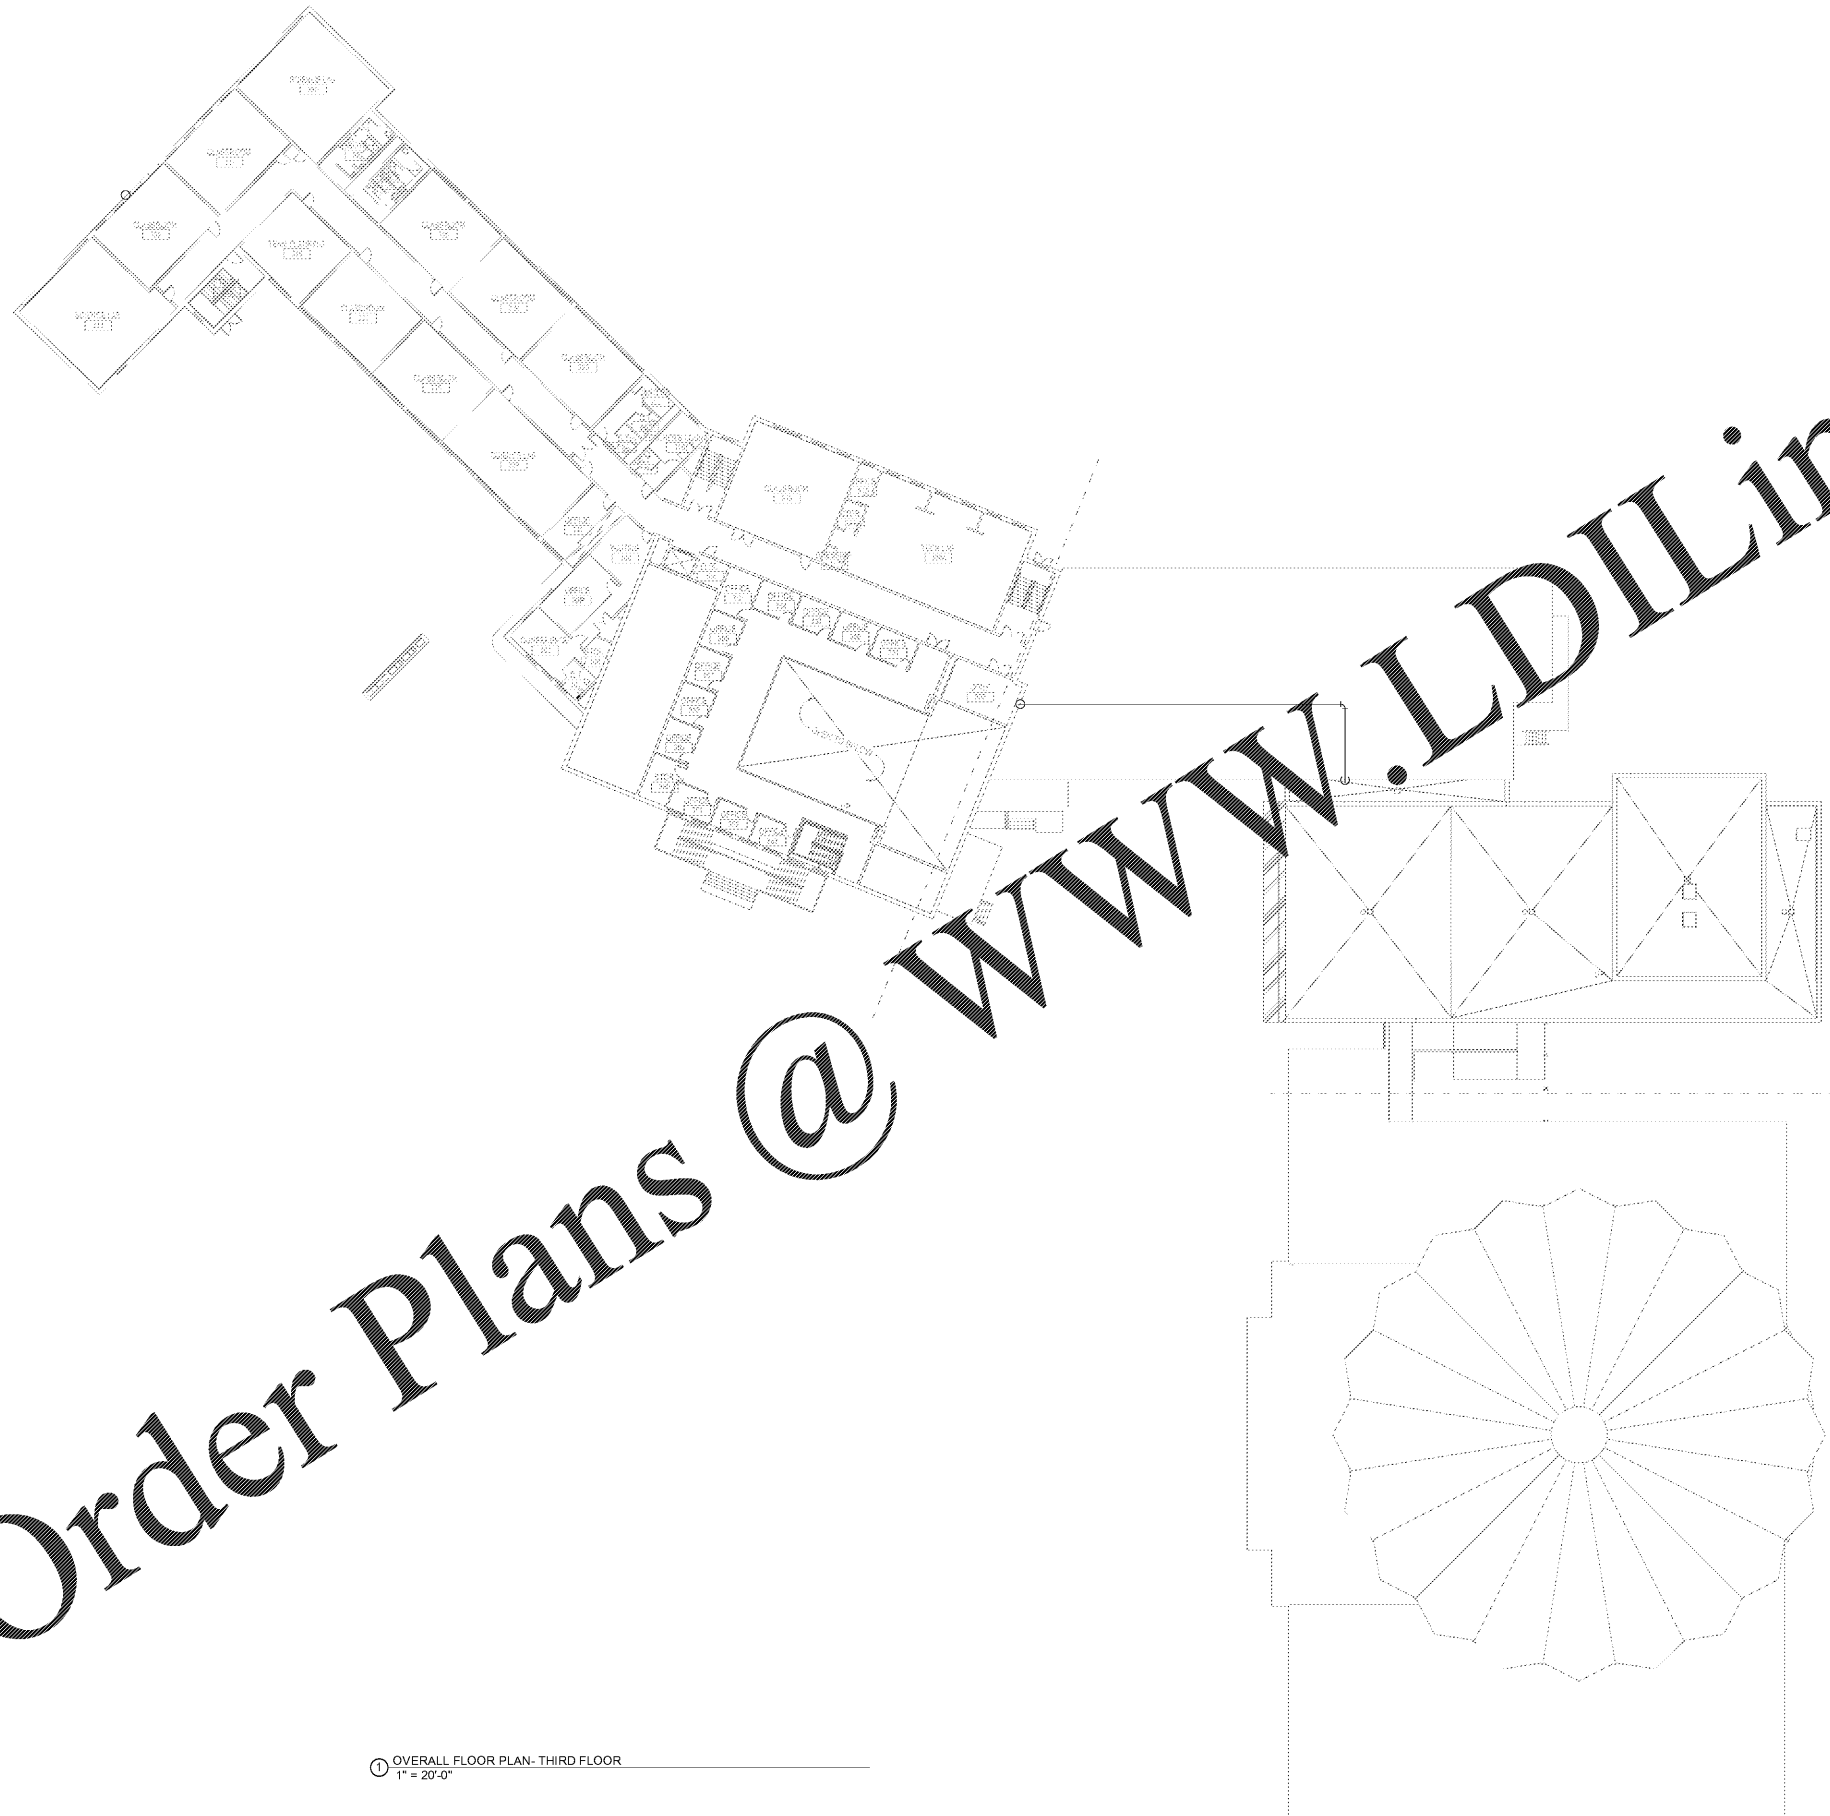

1 OVERALL FLOOR PLAN- THIRD FLOOR  
1" = 20'-0"

**PERKINS  
+ WILL**

Address 1  
Address 2  
Address 3  
City, State ZIP  
1907 854 3210  
1312-26-0789  
[www.perkinswill.com](http://www.perkinswill.com)



PROJECT

RELEASED FOR CONSTRUCTION 06/07/2019

**KIPP ATLANTA  
COLLEGIATE - Addition  
and Renovations**  
98 Anderson Ave NW  
Atlanta GA 30314

KEYPLAN

ISSUE CHART

DATE	ISSUE	DATE
Job Number	BR	
Drawn	MK	
Checked	SM	
Approved		
TITLE		

**OVERALL PLUMBING  
PLAN - THIRD FLOOR**

SHEET NUMBER

**P10-03**



MBA# 19002  
MATHESON BALL & ASSOCIATES, INC.  
11288 ELKING RD. SUITE F-3  
ROSWELL, GEORGIA 30076  
PHONE: (770) 751-1073  
[WWW.MATHESONBALL.COM](http://WWW.MATHESONBALL.COM)

Copyright © 2019 Perkins+Will