



Geary Engineering
 5502 Walsh Lane Suite 102
 Rogers, AR. 72758
 Phone: (479) 464-8006
 E-mail: tgeary@gearyeng.com
 Web: www.gearyeng.com

THESE DRAWINGS ARE PRELIMINARY IN NATURE AND INTENDED FOR REVIEW AND PERMITTING. DRAWINGS ARE NOT TO BE USED FOR CONSTRUCTION WITHOUT ARCHITECT'S AND ENGINEER'S SIGNATURE AND THEIR DATE OF ISSUE FOR CONSTRUCTION.




9726 E. 42nd St. SUITE 153
 TULSA, OK 74146
 918.640.6800
 JHNSANFORD@AOL.COM


Copyright 2019 John Sanford
 JOHN SANFORD,
 AIA, NCARB
 TN LICENSE #106056

NOT VALID FOR CONSTRUCTION UNLESS SIGNED IN THIS BLOCK


NOTE:
 AIR DEVICES AND DUCTWORK THAT PENETRATE RATED FLOOR/CEILING ASSEMBLY ON FOURTH FLOOR SHALL BE PROVIDED WITH FIRE DAMPERS. DAMPERS FOR DEVICES SHALL BE RUSKIN MODEL CFD7T (FOR WOOD TRUSSES) OR LISTED EQUAL. DAMPERS FOR DUCTWORK SHALL BE RUSKIN RD2 OR LISTED EQUAL. BOTH SHALL BE UL555C RATED.

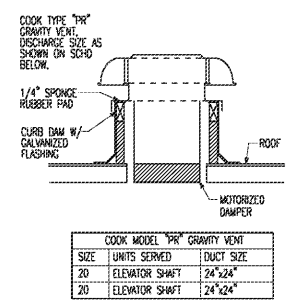


5 Exhaust Air Venting (EV-1)
 No Scale

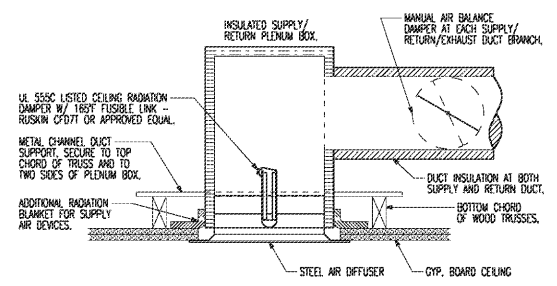


4 Ceiling Diffuser Fire Damper
 No Scale (Wood Truss & Cyp. Board)

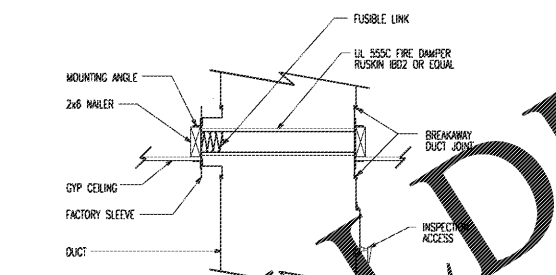

3 Horizontal Fire Damper Installation
 No Scale

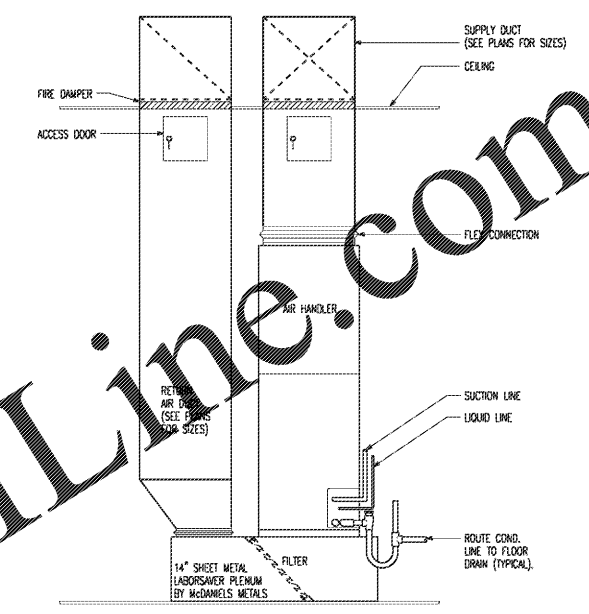

2 Air Handler Elevation
 No Scale (Typical)

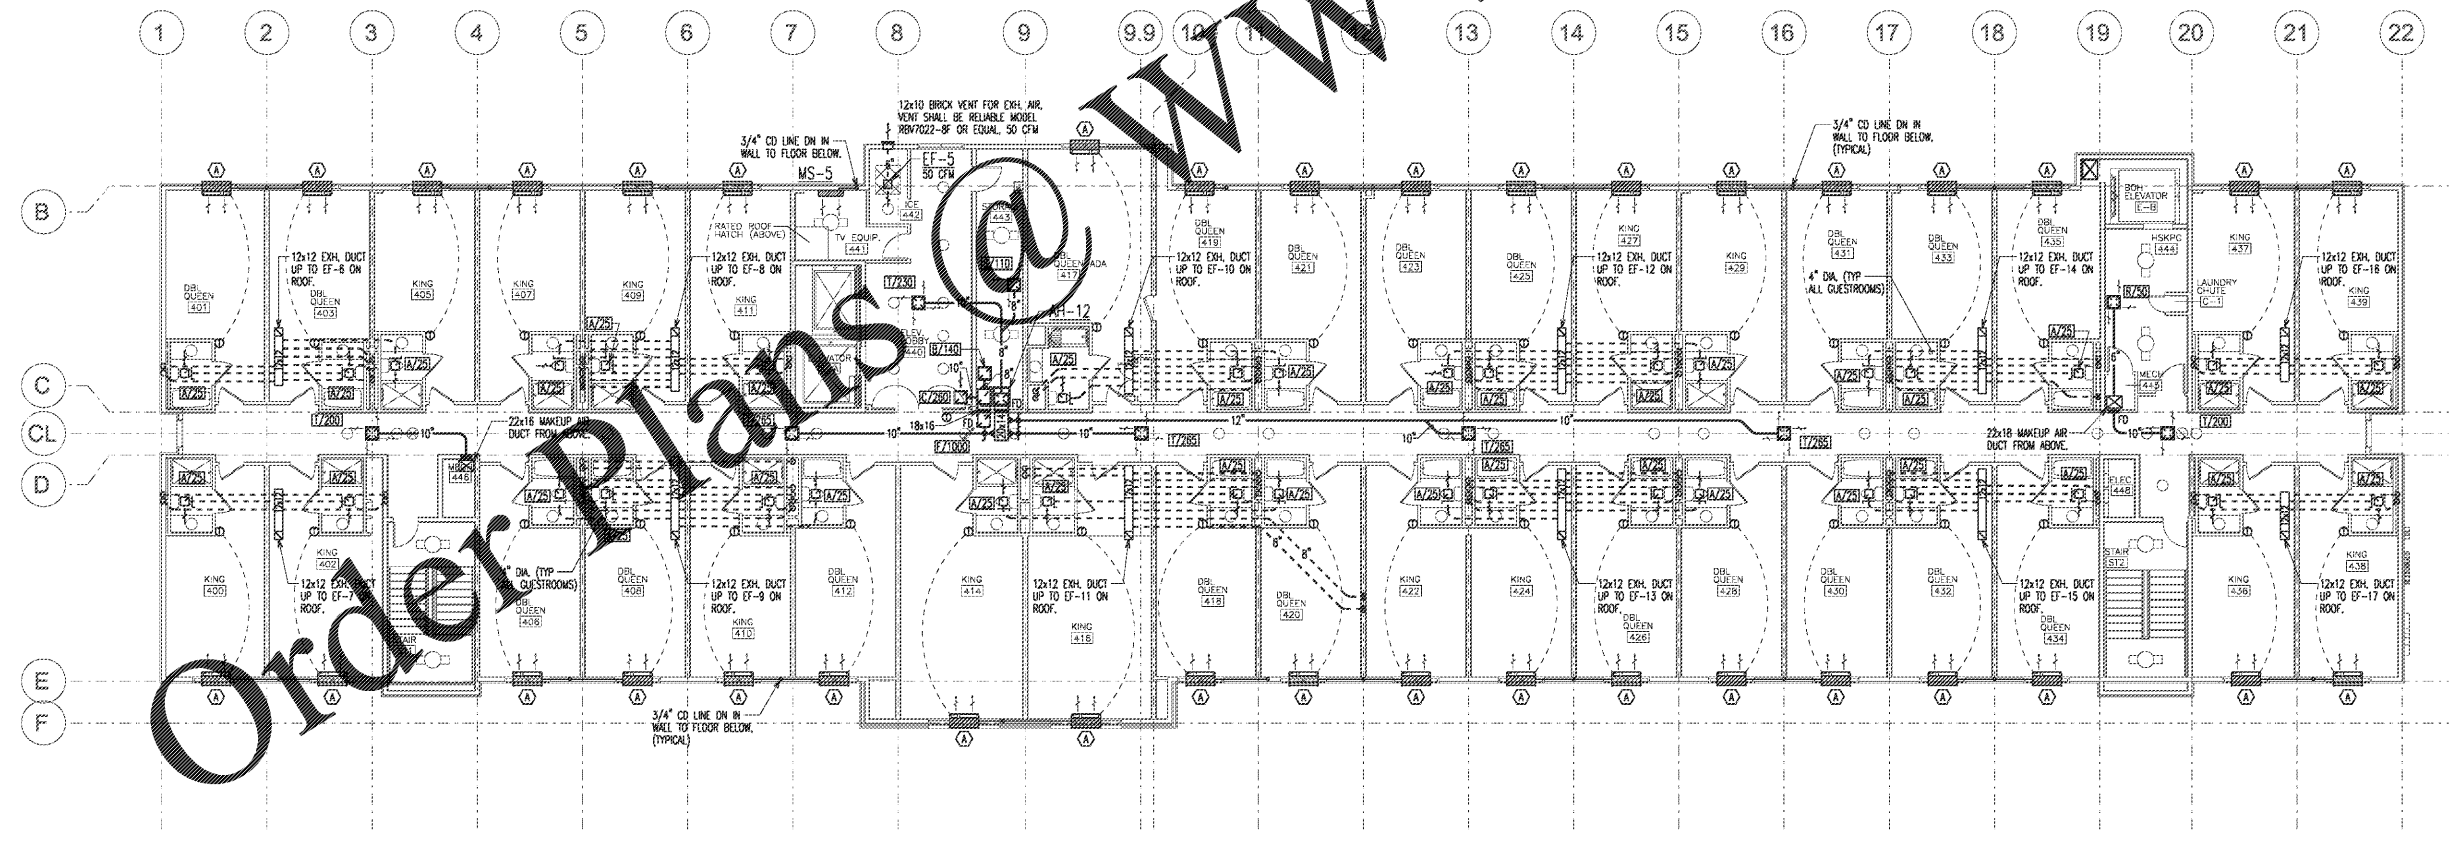

1 Mechanical Floor Plan - Fourth Floor
 3/32" = 1'-0"

PROPOSED HOLIDAY INN LI9383
 215 CRACKER BARREL DR., CLARKSVILLE, TN
 MONTGOMERY COUNTY, TENNESSEE

PERMIT NO: _____
 GE18002

No.	Description	Date

SHEET

M104
 4th FLOOR PLAN

© 2019 JSA ARCHITECTS, ALL RIGHTS RESERVED. THESE DRAWINGS ARE THE PROPERTY OF JSA ARCHITECTS AND SHALL REMAIN THE PROPERTY OF JSA ARCHITECTS. ANY REUSE, REPRODUCTION, MODIFICATION AND/OR DISTRIBUTION OF THESE DRAWINGS WITHOUT THE WRITTEN PERMISSION OF JSA ARCHITECTS IS PROHIBITED. ALL THIRD PARTY INFORMATION IS THE PROPERTY OF THE RESPECTIVE OWNERS AND IS NOT TO BE USED FOR ANY OTHER PROJECTS WITHOUT THE WRITTEN PERMISSION OF THE RESPECTIVE OWNERS.