



Geary Engineering  
 5502 Walsh Lane Suite 102  
 Rogers, AR. 72758  
 Phone: (479) 464-8006  
 E-mail: tgeary@gearyeng.com  
 Web: www.gearyeng.com

THESE DRAWINGS ARE PRELIMINARY IN NATURE AND INTENDED FOR REVIEW AND PERMITTING. DRAWINGS ARE NOT TO BE USED FOR CONSTRUCTION WITHOUT ARCHITECT'S AND ENGINEER'S SIGNATURE AND THEIR DATE OF ISSUE FOR CONSTRUCTION.



9726 E. 42nd St. SUITE 153  
 TULSA, OK 74146  
 918.640.6800  
 JHNSANFORD@AOL.COM

Copyright 2019 John Sanford  
 JOHN SANFORD,  
 AIA, NCARB  
 TN LICENSE #106056

NOT VALID FOR CONSTRUCTION UNLESS SIGNED IN THIS BLOCK

PROPOSED HOLIDAY INN LI9383  
 215 CRACKER BARREL DR., CLARKSVILLE, TN  
 MONTGOMERY COUNTY, TENNESSEE

PERMIT NO: \_\_\_\_\_

GE18002


No.	Description	Date

SHEET

E101  
 LIGHTING &  
 POWER FLOOR  
 PLAN - 1ST FLOOR

ELECTRICAL SYMBOLS		ELECTRICAL SYMBOLS	
(SYMBOLS APPLY ONLY WHEN USED ON DRAWINGS)			
SYMBOLS	DESCRIPTION	SYMBOLS	DESCRIPTION
	FLUORESCENT LIGHTING FIXTURE WITH FIXTURE TYPE.		HOME RUN TO PANELBOARD. ONE CIRCUIT PER ARROWHEAD AS SHOWN. CONNECT TO CIRCUIT AS LABELED.
	NIGHTLIGHT FLUORESCENT LIGHTING FIXTURE WITH FIXTURE TYPE.		ELECTRICAL CONDUIT OUTSIDE OF BUILDING.
	WALL MOUNTED/CEILING MOUNTED FIXTURE WITH FIXTURE NUMBER.		JUNCTION BOX.
	WALL MOUNTED EXIT/CEILING MOUNTED EXIT.		POWER POLE.
	WALL MOUNTED EMERGENCY LIGHT.		HEAT DETECTOR, MOUNT ON CEILING.
	SINGLE POLE TOGGLE SWITCH: 20A, 120/277V / DIMMER SWITCH/KEYED SWITCH.		SMOKE DETECTOR.
	THREE WAY/FOUR WAY TOGGLE SWITCH: 20A, 120/277V.		SMOKE DUCT DETECTOR INSTALLED UPSTREAM OF OUTSIDE AIR CONNECTION. PROVIDED AND INSTALLED BY FIRE ALARM CONTRACTOR.
	PHOTOCELL, MOUNTED UNDER SOffit.		HORN W/ STROBE LIGHT. SYMBOL & CANDELA AS SPECIFIED OR AS REQUIRED PER CODE.
	WALL MOUNTED/CEILING MOUNTED/FLOOR MOUNTED DUPLEX RECEPTACLE: 2P, 3W, 20A, 120V GROUNDING TYPE.		STROBE LIGHT. CANDELA AS SPECIFIED OR AS REQUIRED PER CODE.
	WALL MOUNTED/CEILING MOUNTED/FLOOR MOUNTED QUADRUPLEX RECEPTACLE: 2P, 3W, 20A, 120V GROUNDING TYPE.		FIRE ALARM PULL STATION.
	240V RECEPTACLE.		MAGNETIC DOOR HOLDER.
	WALL MOUNTED/FLOOR MOUNTED TELEPHONE OUTLET. 3/4" ENT TO AEM CEILING TERMINATED WITH PLASTIC BUSHING.		FIRE ALARM MASTER PANEL.
	3/4" ENT TO AEM CEILING TERMINATED WITH PLASTIC BUSHING.		FIRE ALARM REMOTE ANNUNCIATOR PANEL.
	WALL MOUNTED/FLOOR MOUNTED TELEPHONE/DATA OUTLET. 3/4" ENT TO AEM CLG TERMINATED WITH PLASTIC BUSHING.		TAMPER SWITCH FOR SPRINKLER SYSTEM.
	FLOOR MOUNTED RECEPTACLE/TELEPHONE & DATA.		FLOW SWITCH FOR SPRINKLER SYSTEM.
	COAXIAL CABLE ACCESS. 3/4" ENT CONDUIT TO AEM CEILING TERMINATED WITH PLASTIC BUSHING.	ABBREVIATIONS AND SUBSCRIPTS	
	WALL MOUNTED THERMOSTAT. 3/4" ENT TO AEM CEILING TERMINATED WITH PLASTIC BUSHING.	AC	ABOVE COUNTER
	DISCONNECT SWITCH. 30A UNLESS OTHERWISE NOTED. FUSIBLE IF FUSE DESCRIPTION IS SHOWN. VOLTAGE RATING AND NUMBER OF POLES AS REQUIRED.	C	CONDUIT
	DIRECT CONNECTION TO EQUIPMENT.	EMC	ELECTRIC WATER COOLER
	ELECTRIC MOTOR.	FUT	FUTURE
	FLUSH MOUNTED/SURFACE MOUNTED PANELBOARD.	GFI	GROUND FAULT INTERRUPTER
	WIRING CONCEALED IN CEILING OR WALL.	GR	GROUND
	WIRING CONCEALED IN FLOOR.	HD	HAND DRYER
		IC	ISOLATED CORD
		MDP	MAIN DISTRIBUTION PANEL
		MSB	MAIN SWITCHBOARD
		N	NEUTRAL
		N.S.	NOT TO SCALE
		T.S.	TELEPHONE SWITCH
		TMB	TELEPHONE MOUNTING BOARD
		TR	TYPICAL
		UC	UNDER COUNTER
		UW	UNIT WEAVER
		W	WIRE
		WH	WATER HEATER
		WP	WEATHERPROOF

KEYED LIGHTING NOTES	
	SWITCHED AT PANEL.
	SWITCHED AT SWITCH BANK. COORDINATE LOCATION WITH OWNER.
	EXTERIOR LIGHTING TO BE SWITCHED BY PHOTOCELL ON ROOF.

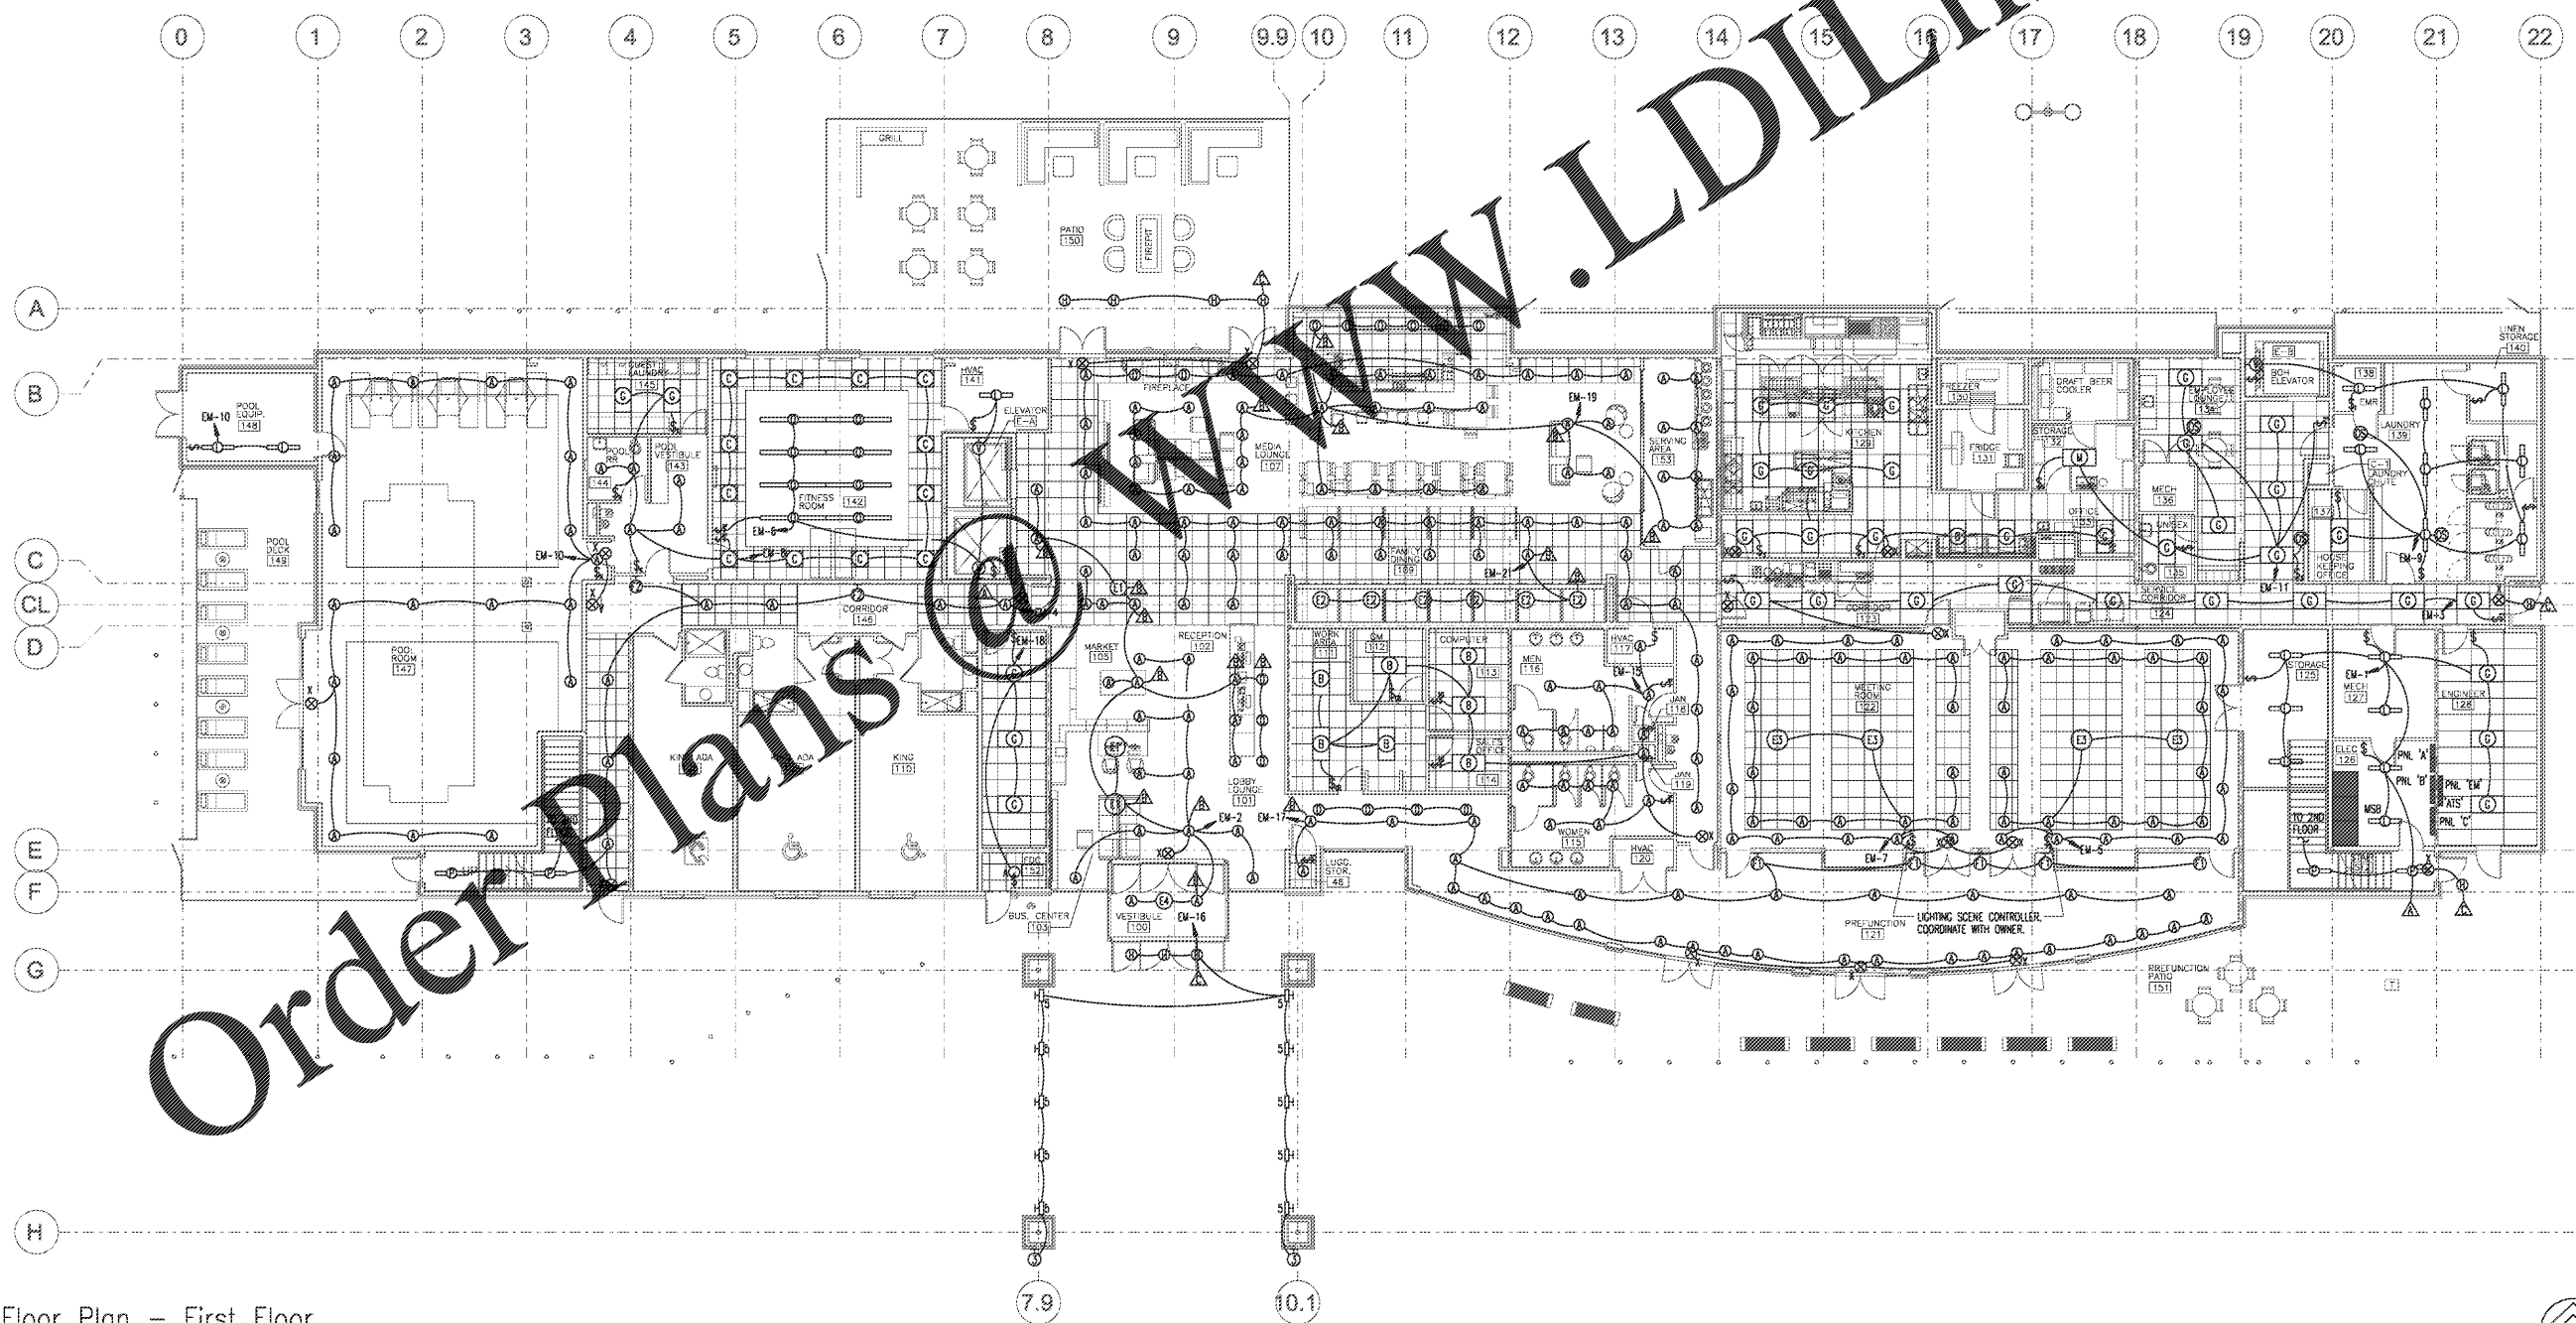

1 Lighting Floor Plan - First Floor  
 3/32"=1'-0"

