 




Key Plan



Professional Seal

**NOT FOR
 CONSTRUCTION**

No.	Description	Date
1	ED - GMP	2019-07-03

Project No: 18.16013.00
 Sheet Title

**LEVEL 3 REFLECTED
 CEILING PLAN - EAST**

Original is 30 x 42. Do not scale contents of this drawing
 Sheet Number

A303B

RCP LEGEND

MATERIALS

- 2 x 2' GRID AND TILE SYSTEM - SEE SPECIFICATIONS
- 2 x 4' GRID AND ACOUSTICAL TILE SYSTEM - SEE SPECIFICATIONS
- GYPSUM BOARD CEILING AS INDICATED ON PLAN. SEE FINISH PLAN FOR PAINT SPECIFICATIONS
- WOOD SLAT SUSPENDED CEILING SYSTEM
- UNDERSIDE OF WOOD VENEER PORTAL
- GSI: INSULATED GYPSUM BOARD SOFFIT
- EXTERIOR STUCCO

ANNOTATIONS

- 8'-0" RECESSED CEILING HEIGHT AS INDICATED ON PLAN UON.

LIGHT FIXTURES

- 2 x 2' RECESSED SEMI-INDIRECT LUMINAIRE
- 2 x 4' RECESSED SEMI-INDIRECT LUMINAIRE
- RECESSED LINEAR LUMINAIRE - REFER TO ELEC DRAWINGS FOR LENGTH AND MOUNTING HEIGHT
- LINEAR LED STRIP LIGHT
- RECESSED DOWNLIGHT - ROUND
- RECESSED DOWNLIGHT - SQUARE
- COVE LIGHT
- CEILING SURFACE MOUNTED STRIP LIGHT
- PENDANT
- PENDANT MTD DIRECT / INDIRECT LED
- UNDER CABINET
- UPLIGHT STRIP

SHADES

- WINDOW SHADES - MOTORIZED
- WINDOW SHADES - MANUAL

POWER & TELEDATA


- FF FURNITURE FEED, POWER POLE AS INDICATED
- OS OCCUPANCY SENSOR
- AS AUDIO SPEAKER
- P PROJECTOR
- EPS PROJECTION SCREEN - ELECTRONIC
- MPS PROJECTION SCREEN - MANUAL

LIFE SAFETY

- EXIT SIGN, ARROW INDICATES PATH OF TRAVEL
- SMOKE DETECTOR
- LIFE SAFETY SPEAKER STROBE
- LIFE SAFETY SPEAKER
- LIFE SAFETY STROBE
- SPRINKLER

KEY NOTES

- THESE NOTES ARE FOR THE PURPOSE OF DD COORDINATION ONLY
- KEY ROOMS TO HAVE 2 X 2' ACOUSTICAL CEILING TILE, TWO 2 X 4' RECESSED LUMINAIRE UON.
 - COORDINATE LIGHTING FOR ALL SPECIALTY KEY ROOMS
 * LIGHT FIXTURES IN IMAGING AND EYE CLINICS TO HAVE DIMMABLE CAPABILITIES
 - COORDINATE ANY SPECIFIC EQUIPMENT WITH LIGHTING IMPLICATIONS (I.E. MEDICAL INTENSIVE ROOMS) WITH APPROPRIATE CONSULTANTS
 - PERIMETER LIGHTING AT CORRIDORS TO ILLUMINATE THE PATIENT SIDE AS A WAY FINDING METHOD
 - COORDINATE SPOT LED FIXTURES AT NURSE STATIONS AND IMPORTANT LANDMARKS
 - PARKING LEVEL FIXTURES ARE SHOWN FOR LOCATION ONLY. REFER TO ELECTRICAL LIGHTING PLANS FOR QUANTITIES AND SPECIFICATIONS.

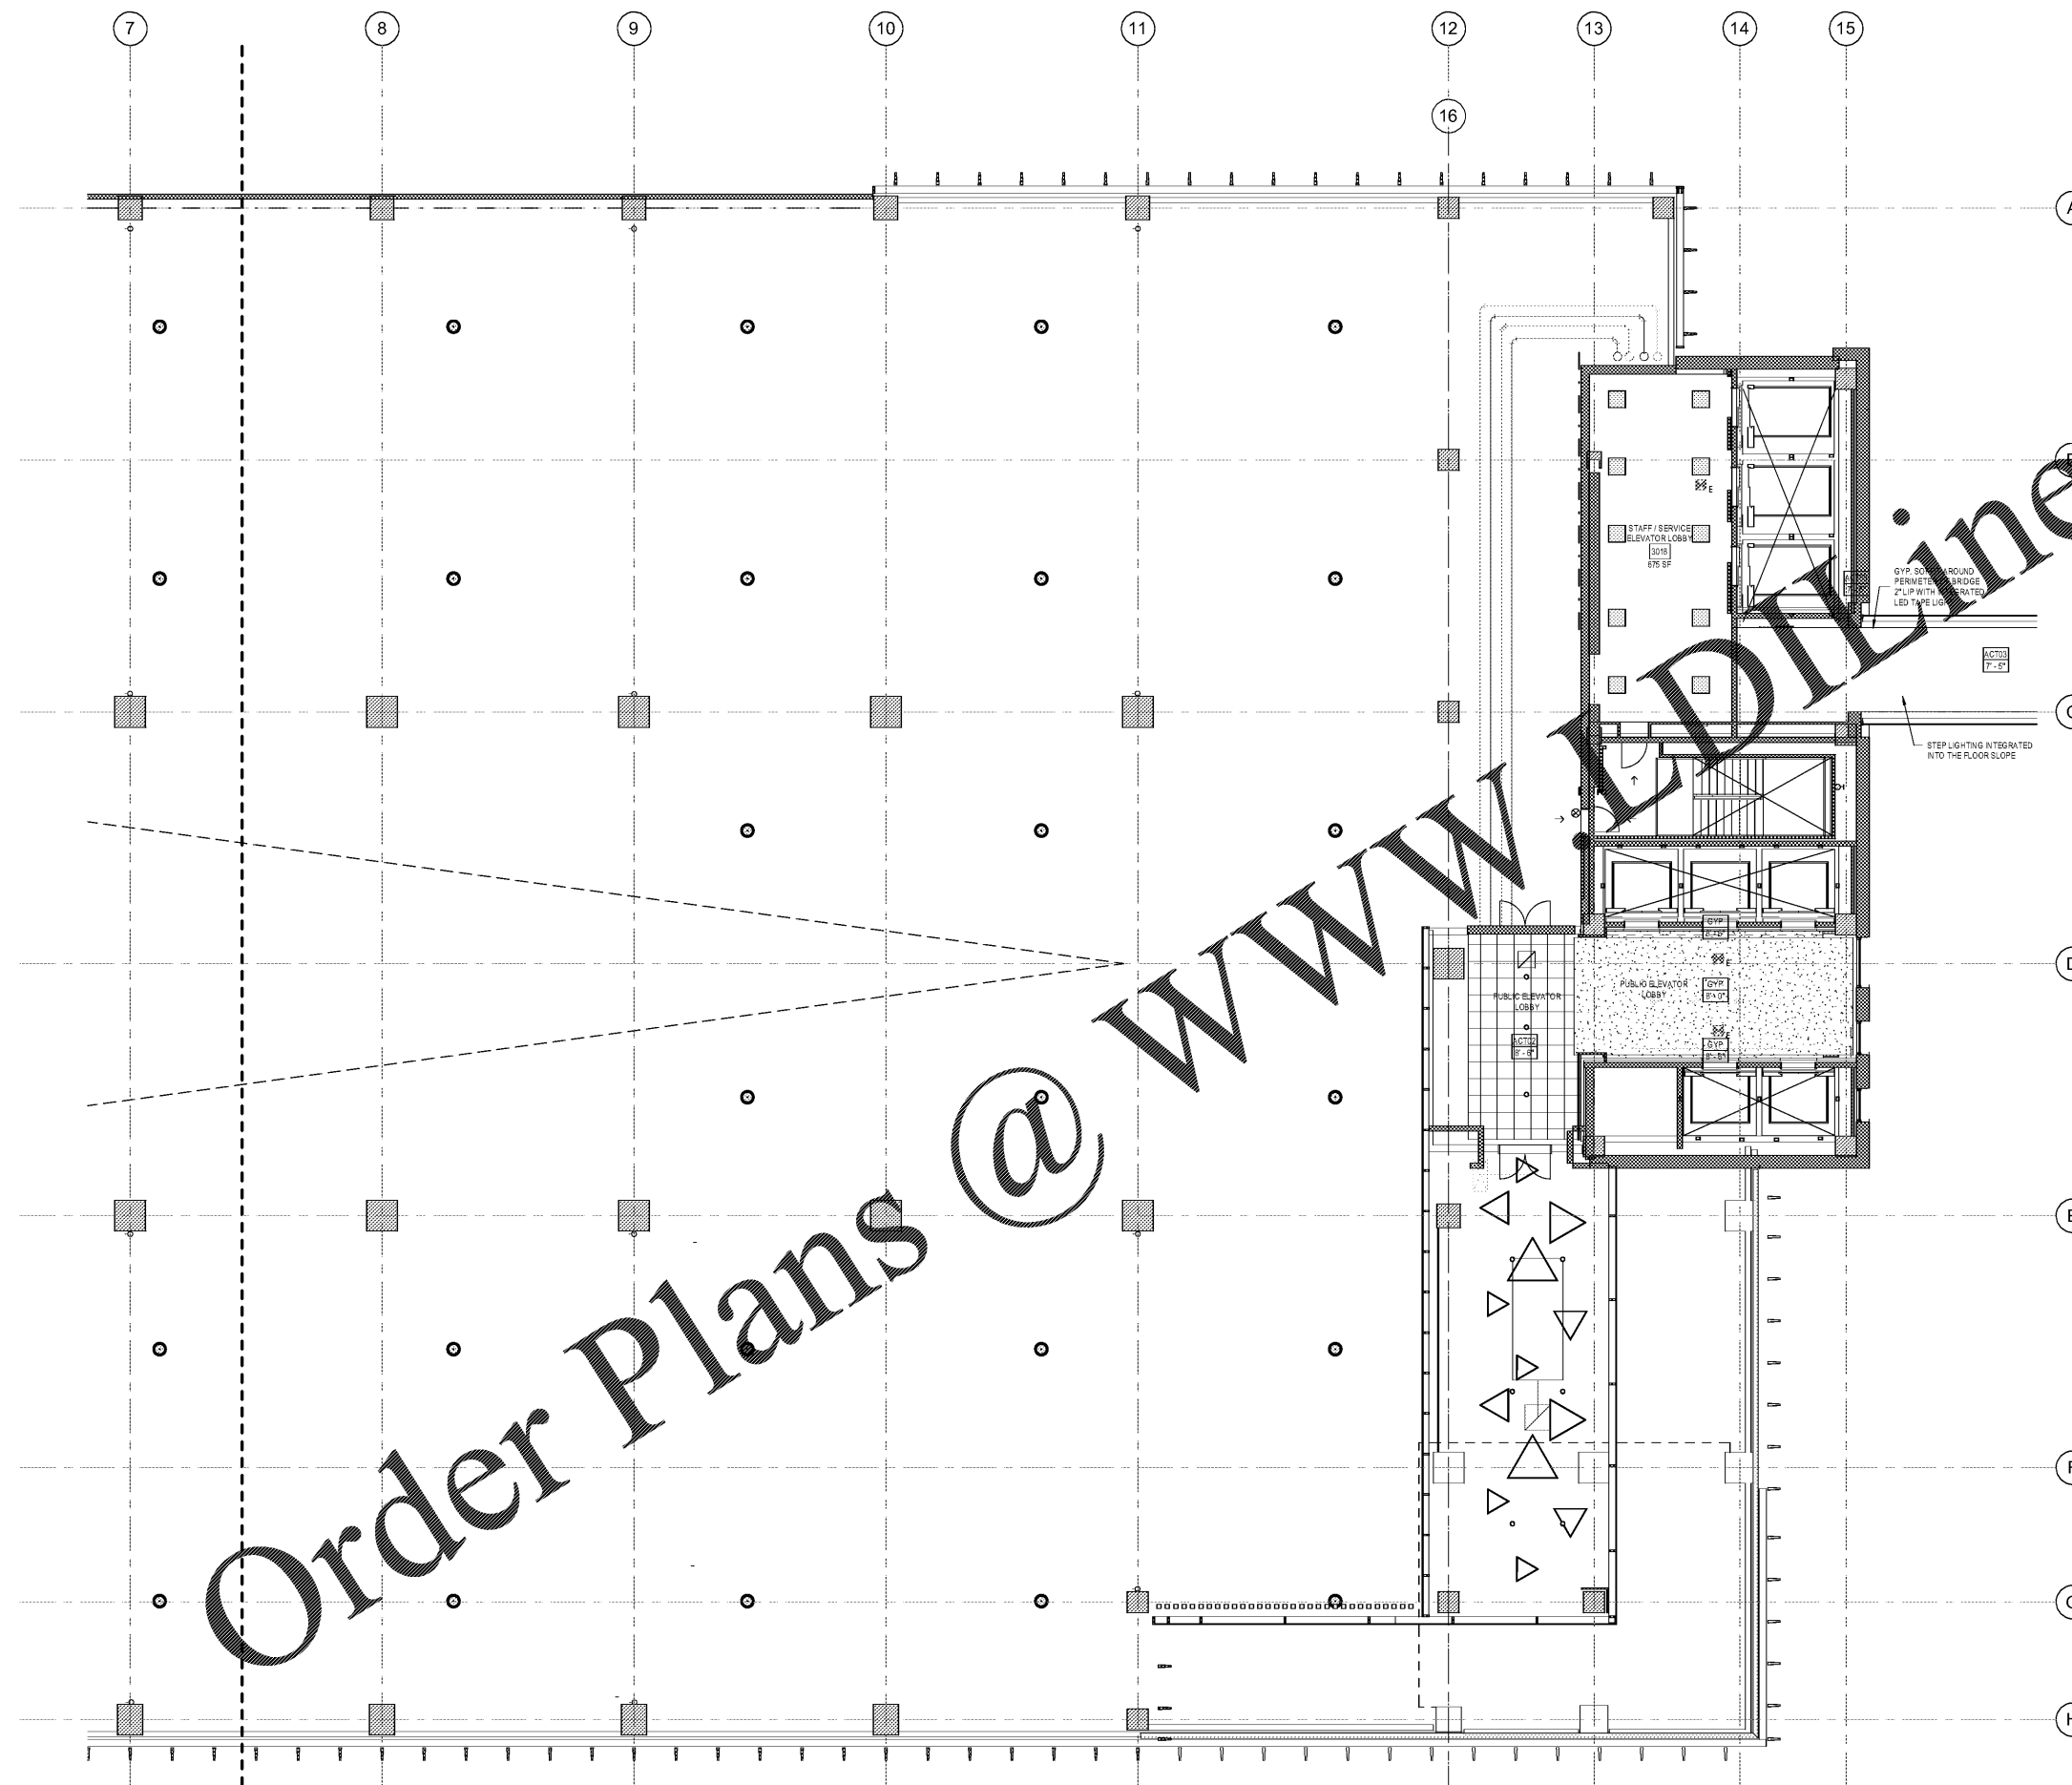

1 REFLECTED CEILING PLAN - LEVEL 3 - EAST
 1/8" = 1'-0"