




15 RECEIVING - WEST.
3/8" = 1'-0"

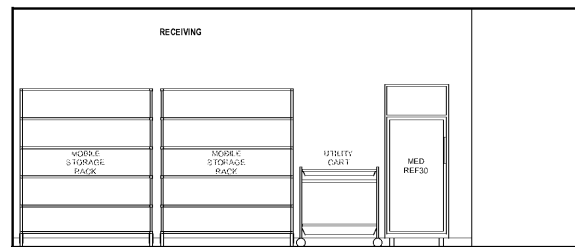


14 RETAIL PHARMACY - RECEIVING - SOUTH.
3/8" = 1'-0"

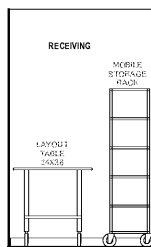


13 RECEIVING - EAST.
3/8" = 1'-0"

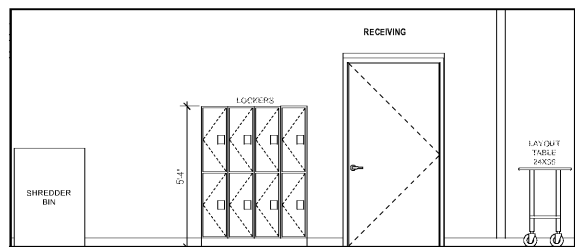


12 RETAIL PHARMACY - RECEIVING NORTH
3/8" = 1'-0"

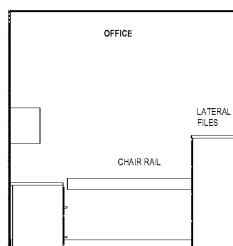


11 RETAIL PHARMACY - OFFICE WEST
3/8" = 1'-0"

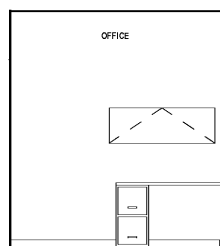


10 RETAIL PHARMACY - OFFICE SOUTH
3/8" = 1'-0"

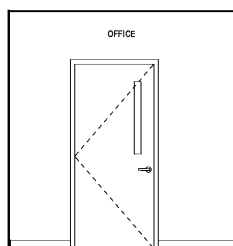


9 RETAIL PHARMACY - OFFICE EAST
3/8" = 1'-0"

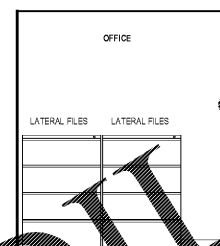


8 RETAIL PHARMACY - OFFICE NORTH.
3/8" = 1'-0"

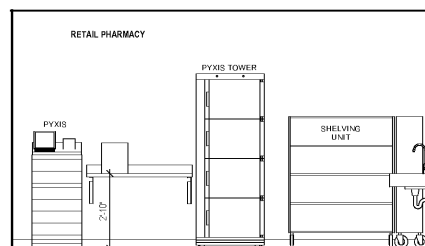


7 RETAIL PHARMACY - WEST.
3/8" = 1'-0"

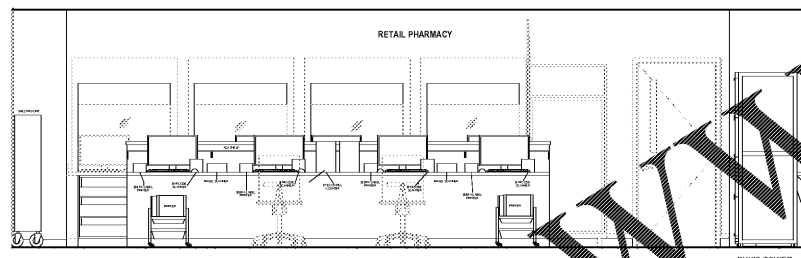


6 RETAIL PHARMACY - SOUTH. AT VERIFY / REFILL
3/8" = 1'-0"

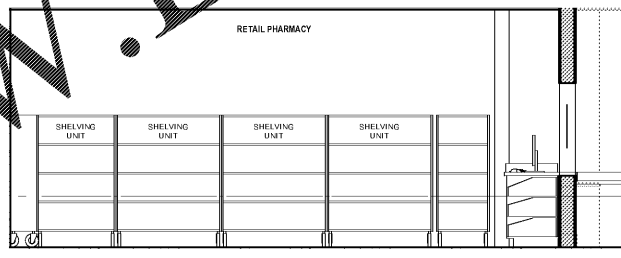


5 RETAIL PHARMACY - EAST.
3/8" = 1'-0"

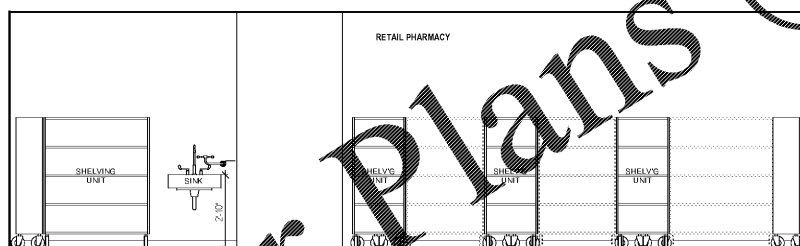


4 RETAIL PHARMACY - NORTH.
3/8" = 1'-0"

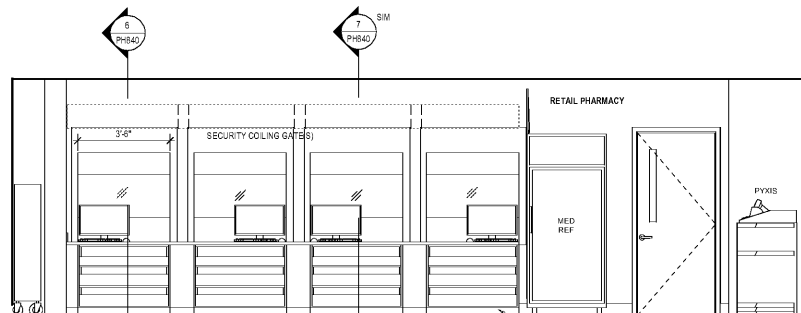

3 RETAIL PHARM. SOUTH AT COUNTER
3/8" = 1'-0"

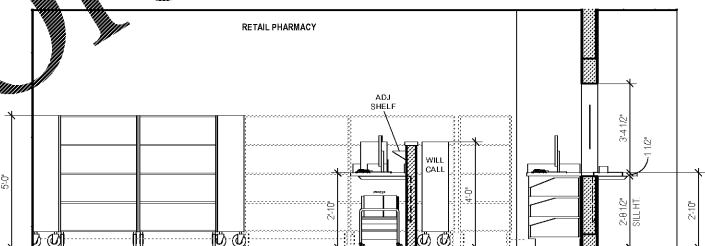

2 RETAIL PHARM. EAST AT VERIFY / REFILL
3/8" = 1'-0"

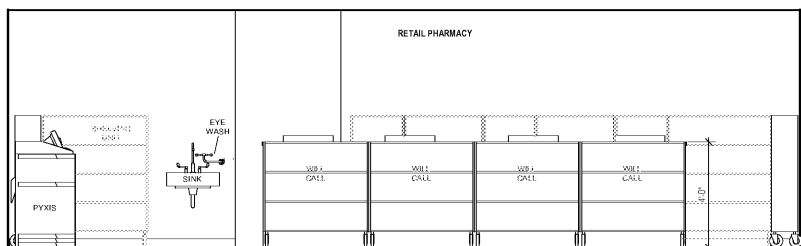

1 RETAIL PHARMACY EAST AT WILL CALL SHELVES
3/8" = 1'-0"

GENERAL NOTES - INTERIOR ELEVATIONS

- A. COORDINATE ALL WORK, DEMO & NEW WITH PME DRAWINGS - SEE PME DRAWINGS FOR OTHER REQUIREMENTS NOT SHOWN ON INTERIOR ELEVATIONS. NOTIFY ARCHITECT OF DISCREPANCIES FOR CLARIFICATION.
- B. PATCH & REPAIR EXISTING WALLS TO REMAIN AS NECESSARY.
- C. SEE DOOR AND WINDOW SCHEDULES FOR GLAZING TYPES.
- D. SEE FINISH SCHEDULE FOR FINISH INFORMATION.
- E. SEE EQUIPMENT PLAN FOR ALL EQUIPMENT INFORMATION. COORDINATE WITH EQUIPMENT VENDOR TO ENSURE PROPER SPACE ALLOCATION AND ALL ITEMS NEEDED FOR INSTALLATION OF EQUIPMENT.
- F. PATCH & REPAIR EXISTING WALLS TO REMAIN AS NECESSARY.
- G. ALL BASE CABINETS ARE 24" DEEP U.N.O.
- H. ALL EXPOSED ENDS OF CASEWORK AND INSIDE FACES OF OPEN CASEWORK ARE TO BE FINISHED WITH THE SAME FINISH AS THE FACE OF CABINET. CASEWORK MANUFACTURER SHALL VERIFY / MEASURE ALL FIELD CONDITIONS PRIOR TO FABRICATION OF CASEWORK. COUNTERTOPS, ANY ALTERATIONS TO THE CASEWORK AS THE RESULT OF FIELD CONDITIONS SHALL BE APPROVED BY THE ARCHITECT AND OWNER PRIOR TO FABRICATION. CONTRACTOR MANUFACTURER SHALL COORDINATE WITH CONTRACTOR INSTALLATION OF BLOCKING AND SUPPORT BRACKETS.
- I. ALL DIMENSIONS SHOWN ARE TO FACE OF FINISH.
- J. ALL MOUNTING HEIGHTS ARE ABOVE FINISH FLOOR (A.F.F.).
- K. ALL FULL HEIGHT CABINETS ARE 24" DEEP U.N.O.
- L. ALL COUNTERTOPS ARE TO INCLUDE A CONTINUOUS MATCHING 4" BACKSPASH U.N.O. ALL BACKSPASHES ASSUMED TO INCLUDE SPIDERPLATES AT ADJOINING WALLS AND/OR OTHER VERTICAL INTERSECTIONS.
- M. ALL OUTBOARD EXPOSED CORNERS OF COUNTERTOPS ARE TO BE 1 1/2" RADIUS U.N.O.
- N. GENERAL CONTRACTOR IS RESPONSIBLE FOR PROVIDING IN-WALL BLOCKING ADEQUATE FOR THE SUPPORT OF ALL COUNTERTOPS HEREIN. IN ADDITION, THE CONTRACTOR SHALL PROVIDE ADEQUATE WALL BRACING FOR ALL FINISH CABINETS OR ALL FINISH COMPONENTS INCLUDING BUT NOT LIMITED TO WALL MOUNTED DISPENSERS, CUSTOM GRAPHIC PANELS, BANKERS' TRAYS, AND CUSTOM COUNTERTOPS AS RIGIDLY ATTACHED TO WALL ASSEMBLIES OR OTHER STRUCTURAL COMPONENTS. SEE SPECIFICATIONS FOR BLOCKING REQUIREMENTS. NOTE: SPECIFICATIONS SHALL BE TAKEN AS FULL ACCOUNTING.
- O. GENERAL CONTRACTOR SHALL VERIFY THAT ALL BLOCKING IS IN PLACE AND DATA POINTS ARE CORRECTLY NOT BE SHOWN.
- P. PROVIDE ACCESS CABINETS, LOCATIONS TO BE IDENTIFIED IN THE FIELD. ACCESS CABINETS SHALL BE 18" WIDE AND 24" HIGH.
- Q. ELECTRIC OUTLETS ARE TO BE 18" A.F.F. AND CENTERED IN SPACES U.N.O. SEE DRAWINGS.
- R. LIGHT SWITCHES ARE TO BE CENTERED IN SPACE AND 3'-4" A.F.F. U.N.O. - SEE DRAWINGS.
- S. PROVIDE BLIND CABINETS WHERE APPLICABLE.
- T. PROVIDE SCREENED FILLERS BETWEEN ALL WALLS AND CABINET ENDS U.N.O. PROVIDE MINIMUM 2" FILLERS BETWEEN THE CORNER CABINETS IN AN "L" SHAPE CONFIGURATION.
- U. PROVIDE CORNER CLOSURE PIECE UNDER THE WALL CABINETS IN AN "L" SHAPE CONFIGURATION.
- V. PROVIDE FINISH END/SIDES FOR ALL EXPOSED END CABINETS.

CODED NOTES - INTERIOR ELEVATIONS

1. COUNTER MOUNTED SINK - SEE PLUMBING DRAWINGS.
2. WALL MOUNTED SINK - SEE PLUMBING DRAWINGS.
3. P-LAM ADA PLUMBING GUARD - SEE DETAIL.
4. INTEGRATED INSULATION PROTECTION BELOW SINK - SEE PME DRAWINGS.
5. PAPER TOWEL DISPENSER, O.F.C.I. - SEE MOUNTING HEIGHTS.
6. WALL MOUNTED SOAP DISPENSER, O.F.C.I. - SEE MOUNTING HEIGHTS.
7. HAND GEL DISPENSER, O.F.C.I. - SEE MOUNTING HEIGHTS.
8. DESK TOP PHONE - SEE PME DRAWINGS.
9. EXISTING RELOCATED EQUIPMENT TO REMAIN - SEE EQUIPMENT DRAWINGS.
10. NEW EQUIPMENT - SEE EQUIPMENT DRAWINGS.
11. PYXIS MAIN EQUIPMENT TERMINAL - SEE EQUIPMENT DRAWINGS.
12. PYXIS EQUIPMENT - SEE EQUIPMENT DRAWINGS.
13. CLINICAL REFRIGERATOR - SEE EQUIPMENT DRAWINGS.
14. CLINICAL FREEZER - SEE EQUIPMENT DRAWINGS.
15. 30" REFRIGERATOR - SEE EQUIPMENT DRAWINGS.
16. 12" X 12" STACKED PURSE LOCKERS - SEE EQUIPMENT DRAWINGS.
17. PNEUMATIC TUBE STATION - SEE EQUIPMENT DRAWINGS.
18. LIGHT FIXTURE LOCATION - SEE PME DRAWINGS.
19. LIGHT SWITCH LOCATION - SEE PME DRAWINGS.
20. PLUMBING FIXTURE - SEE PME DRAWINGS.
21. POWER OUTLET/DATA CONNECTION LOCATION - SEE PME DRAWINGS.
22. FIRE EXTINGUISHER CABINET.
23. BASE AS SPECIFIED - SEE FINISH SCHEDULE.
24. P-LAM CABINETRY WITH LOCKS ON ALL DOORS AND DRAWERS - SEE FINISH SCHEDULE.
25. P-LAM COUNTERTOP (PL-1) WITH BACKSPASH - SEE FINISH SCHEDULE. PROVIDE GRIPSTRIPS AS NEEDED AND VERIFY LOCATION(S) WITH OWNER PRIOR TO MANUFACTURING.
26. APRON TO MATCH COUNTERTOP FINISH/MATERIAL.
27. TRANSACTION COUNTERTOP - SEE FINISH SCHEDULE.
28. P-LAM WALL CABINETRY WITH BLOCKING - SEE CASEWORK DETAILS.
29. P-LAM FILLER PANELS - SEE FINISH SCHEDULE.
30. P-LAM END PANEL SUPPORT - SEE FINISH SCHEDULE.
31. LINE OF PLASTIC LAMINATED SLOPED TOP - SEE CASEWORK DETAILS.
32. LINE OF SLOTT - SEE REFLECTED CEILING PLANS.
33. DASHED LINE OF FINISH DRAWERS - SEE FURNITURE SPECIFICATIONS.
34. CONCEALED STEEL ANGLE MOUNTING BRACKET - SEE SECTION DETAIL.
35. SURFACE MOUNTED STEEL COUNTERTOP SUPPORT BRACKET - SEE SECTION DETAIL.
36. SHELF AND ROD (PL-1) - SEE DETAIL.
37. ADA SHELF AND ROD (PL-1) - SEE DETAIL.
38. RIGID SHEET WALL PROTECTION (WP-1) - SEE FINISH SCHEDULE.
39. CORNER GUARD - SEE FINISH SCHEDULE.



Project
CASS Pharmacies

88 Jesse Hill Drive
Atlanta, GA 30303

 
Prepared For
GRADY HEALTH SYSTEM



Helmut J. Obata & Katsuhisa, Inc.
133 Peachtree Street, NE, Suite 4800
Atlanta, GA 30303 USA
T+1 404 439 9000 F+1 404 439 9001

All reproduction & intellectual property rights reserved © 2019
In Association with

Key Plan



Professional Seals

NOT FOR CONSTRUCTION

No.	Description	Date
1	DD - GMP	2019-07-03

Project No: 18534.01
Sheet Title

INTERIOR ELEVATIONS
AND DETAILS - RETAIL
PHARMACY

Original is 30" x 42". Do not scale contents of this drawing.
Sheet Number

PH914