

PLUMBING KEYNOTES



Project
**THE CENTER FOR
ADVANCED SURGICAL
SERVICES (CASS)**
88 JESSE HILL DRIVE
ATLANTA, GA 30303

Prepared For
GRADY HEALTH SYSTEM
80 JESSE HILL DR, SE
ATLANTA, GA 30303



Helmut, Obata & Kassabaum, Inc.
191 Peachtree Street, NE, Suite 2250
Atlanta, GA 30303 USA
Tel: 404-438-9000 Fax: 404-438-9001

All reproduction & intellectual property rights reserved © 2019



Key Plan



Professional Seal
Roosevelt Powell, P.E.
Georgia License #PE21562

**NOT FOR
CONSTRUCTION**

No. Description Date

1 DD-GMP 2019-07-01

1 SCHEMATIC DESIGN 2019-11-21

2 SCHEMATIC DESIGN-UPDATE 2019-03-19


Project No: **18.16013.00**

Sheet Title
**LEVEL 2 FLOOR PLAN -
WEST - PLUMBING**

Original is 30 x 42. Do not scale contents of this drawing.

Sheet Number

P112A

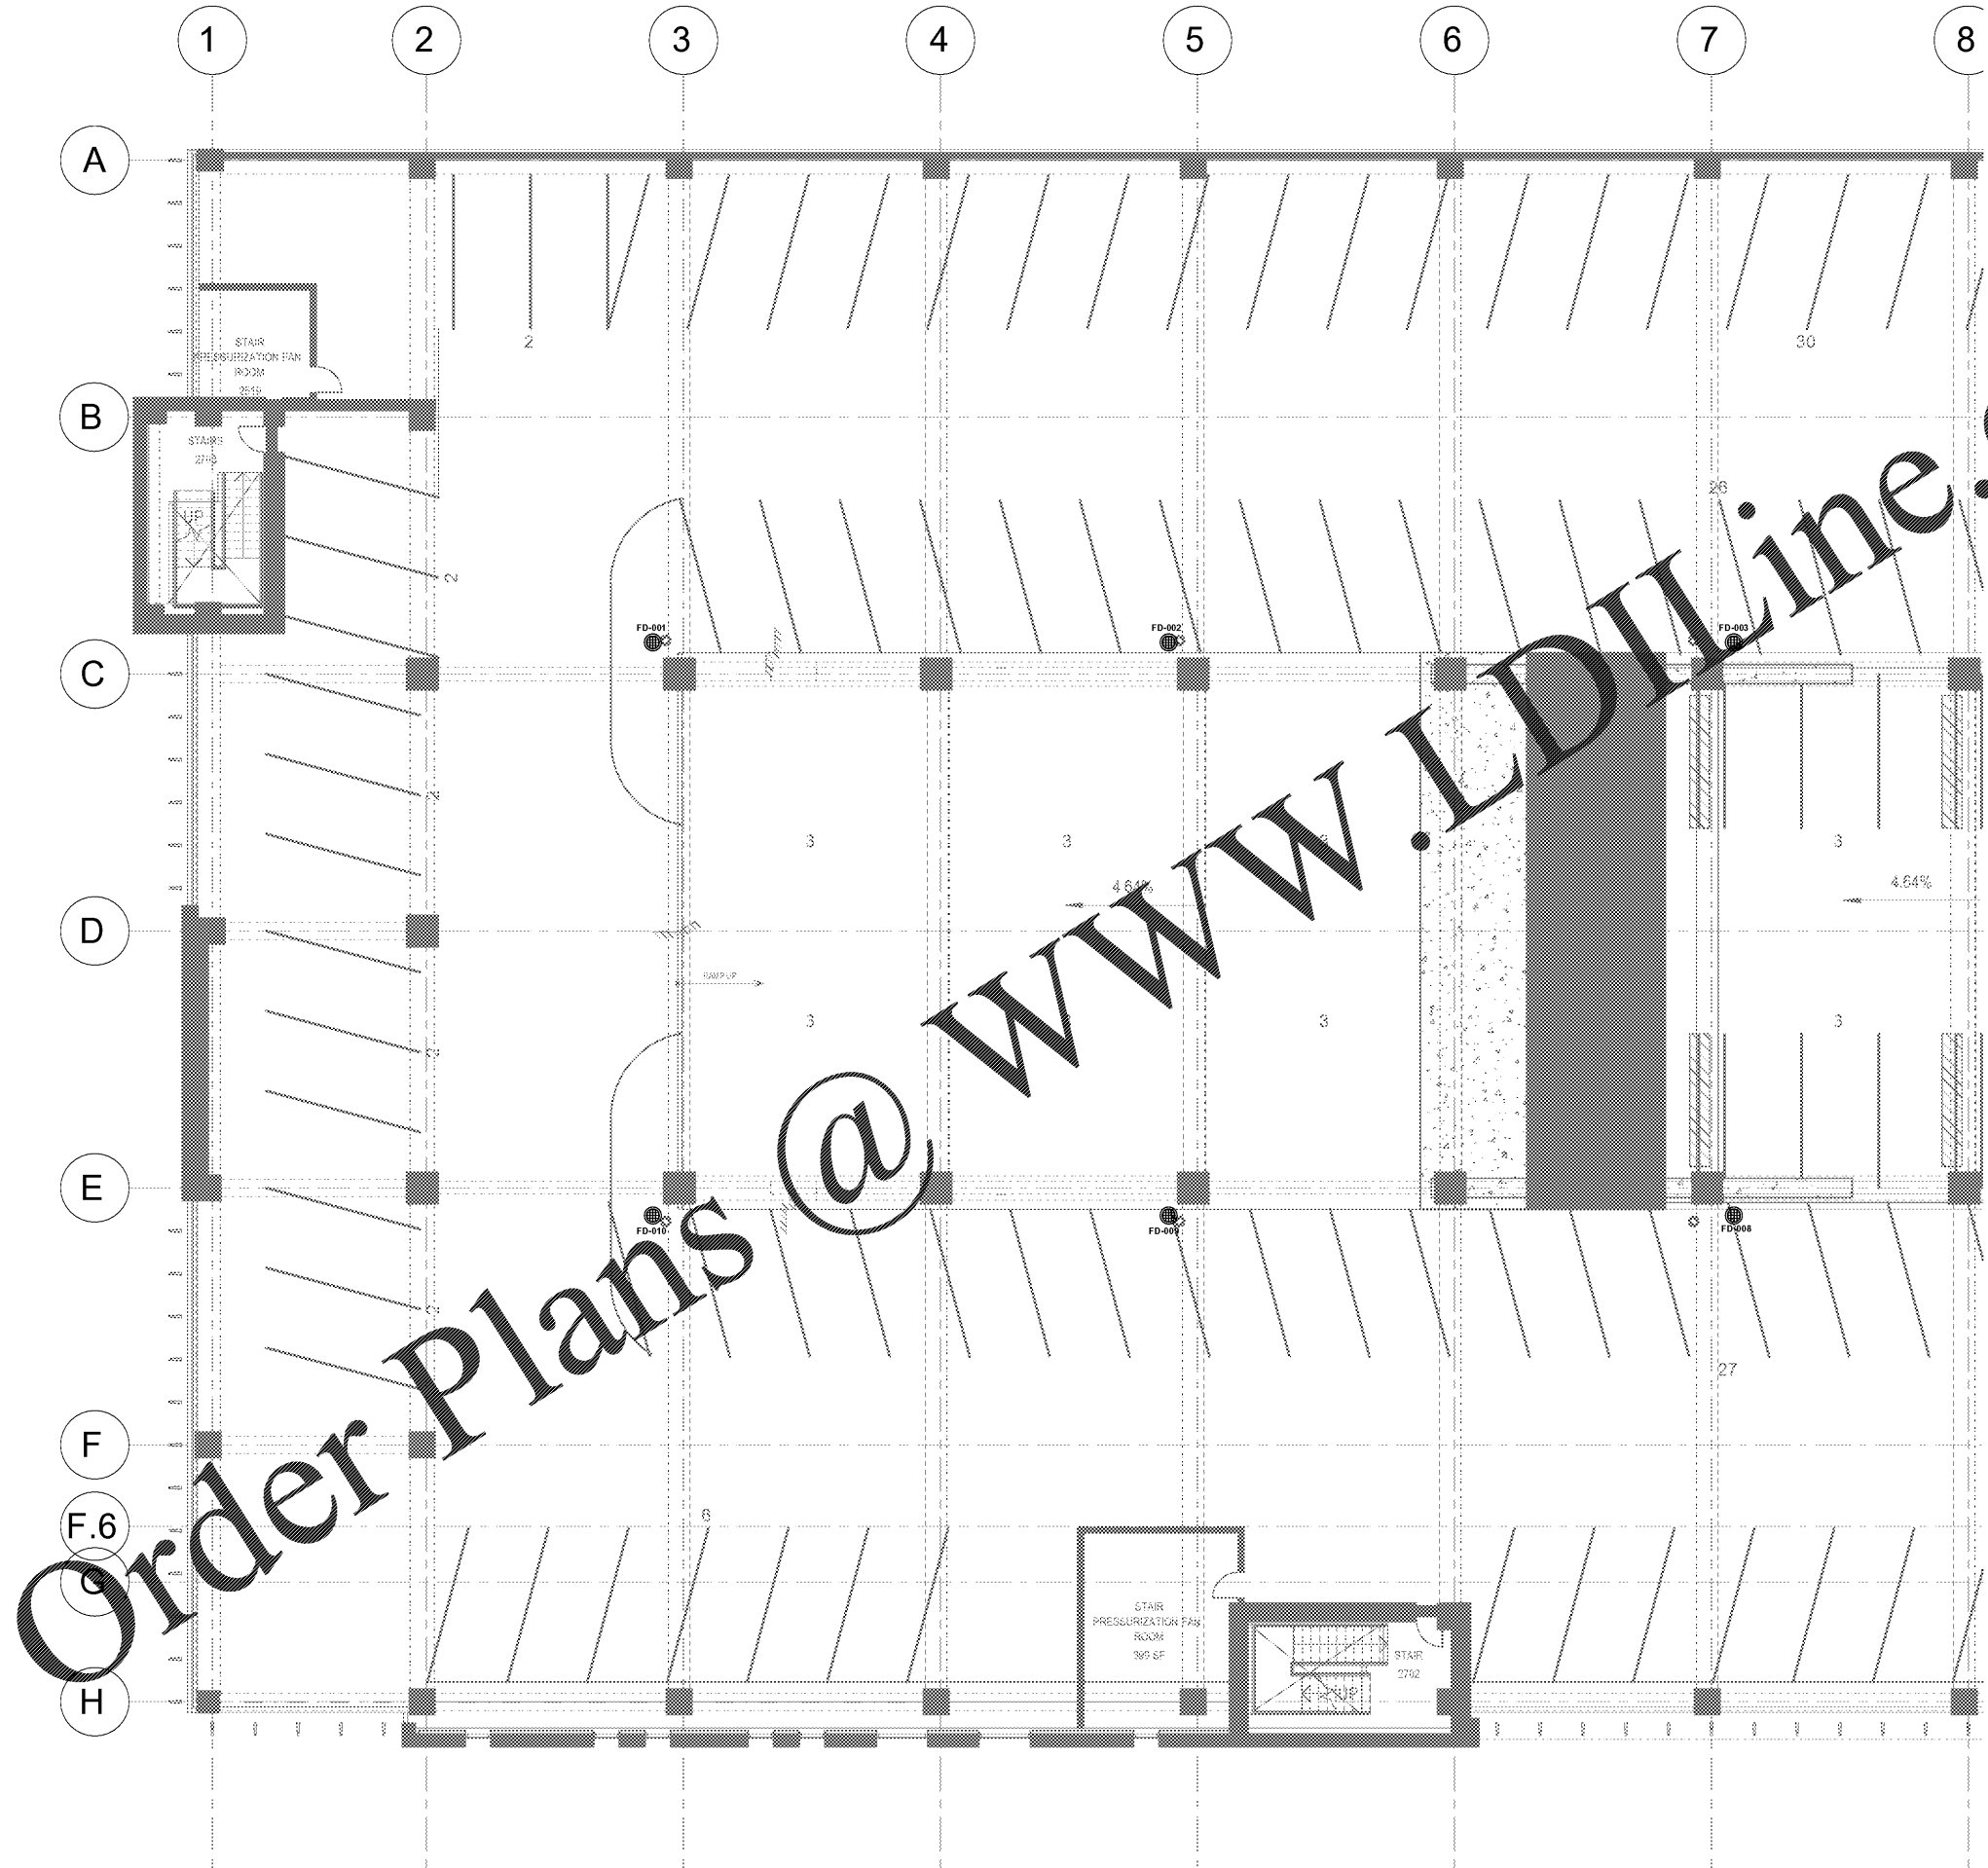

1 FLOOR PLAN - LEVEL 2 - WEST - PLUMBING
1/8" = 1'-0"

Order Plans @ www.LDOnline.com