

Project
**THE CENTER FOR
ADVANCED SURGICAL
SERVICES (CASS)**
88 JESSE HILL DRIVE
ATLANTA, GA 30303

Prepared For
GRADY HEALTH SYSTEM
80 JESSE HILL DR. SE
ATLANTA, GA 30303

 


Helium, Obata & Kassabaum, Inc.
191 Peachtree Street, NE, Suite 2250
Atlanta, GA 30303 USA
T+1 404 439 9000 F+1 404 439 9001

All reproduction & intellectual property rights reserved ©
2019.
In Association with

TLC ENGINEERING
254 S. Orange Avenue
Suite 1400
Orlando, FL 32801
P: 407.841.0392
CDA PEF02280
www.tlc-engineering.com
TLC No. 118548
TPOUS, L167296, C285A19

Key Plan



Professional Seal
Emory Neal Boothe, P.E.
Georgia License #PE039005

**NOT FOR
CONSTRUCTION**


No.	Description	Date
1	ED - GMP	2019-07-03

Project No: 18.16013.00
Sheet Title

**SITE PLAN -
ELECTRICAL**

Original is 20 x 42. Do not scale contents of this drawing.
Sheet Number

E100

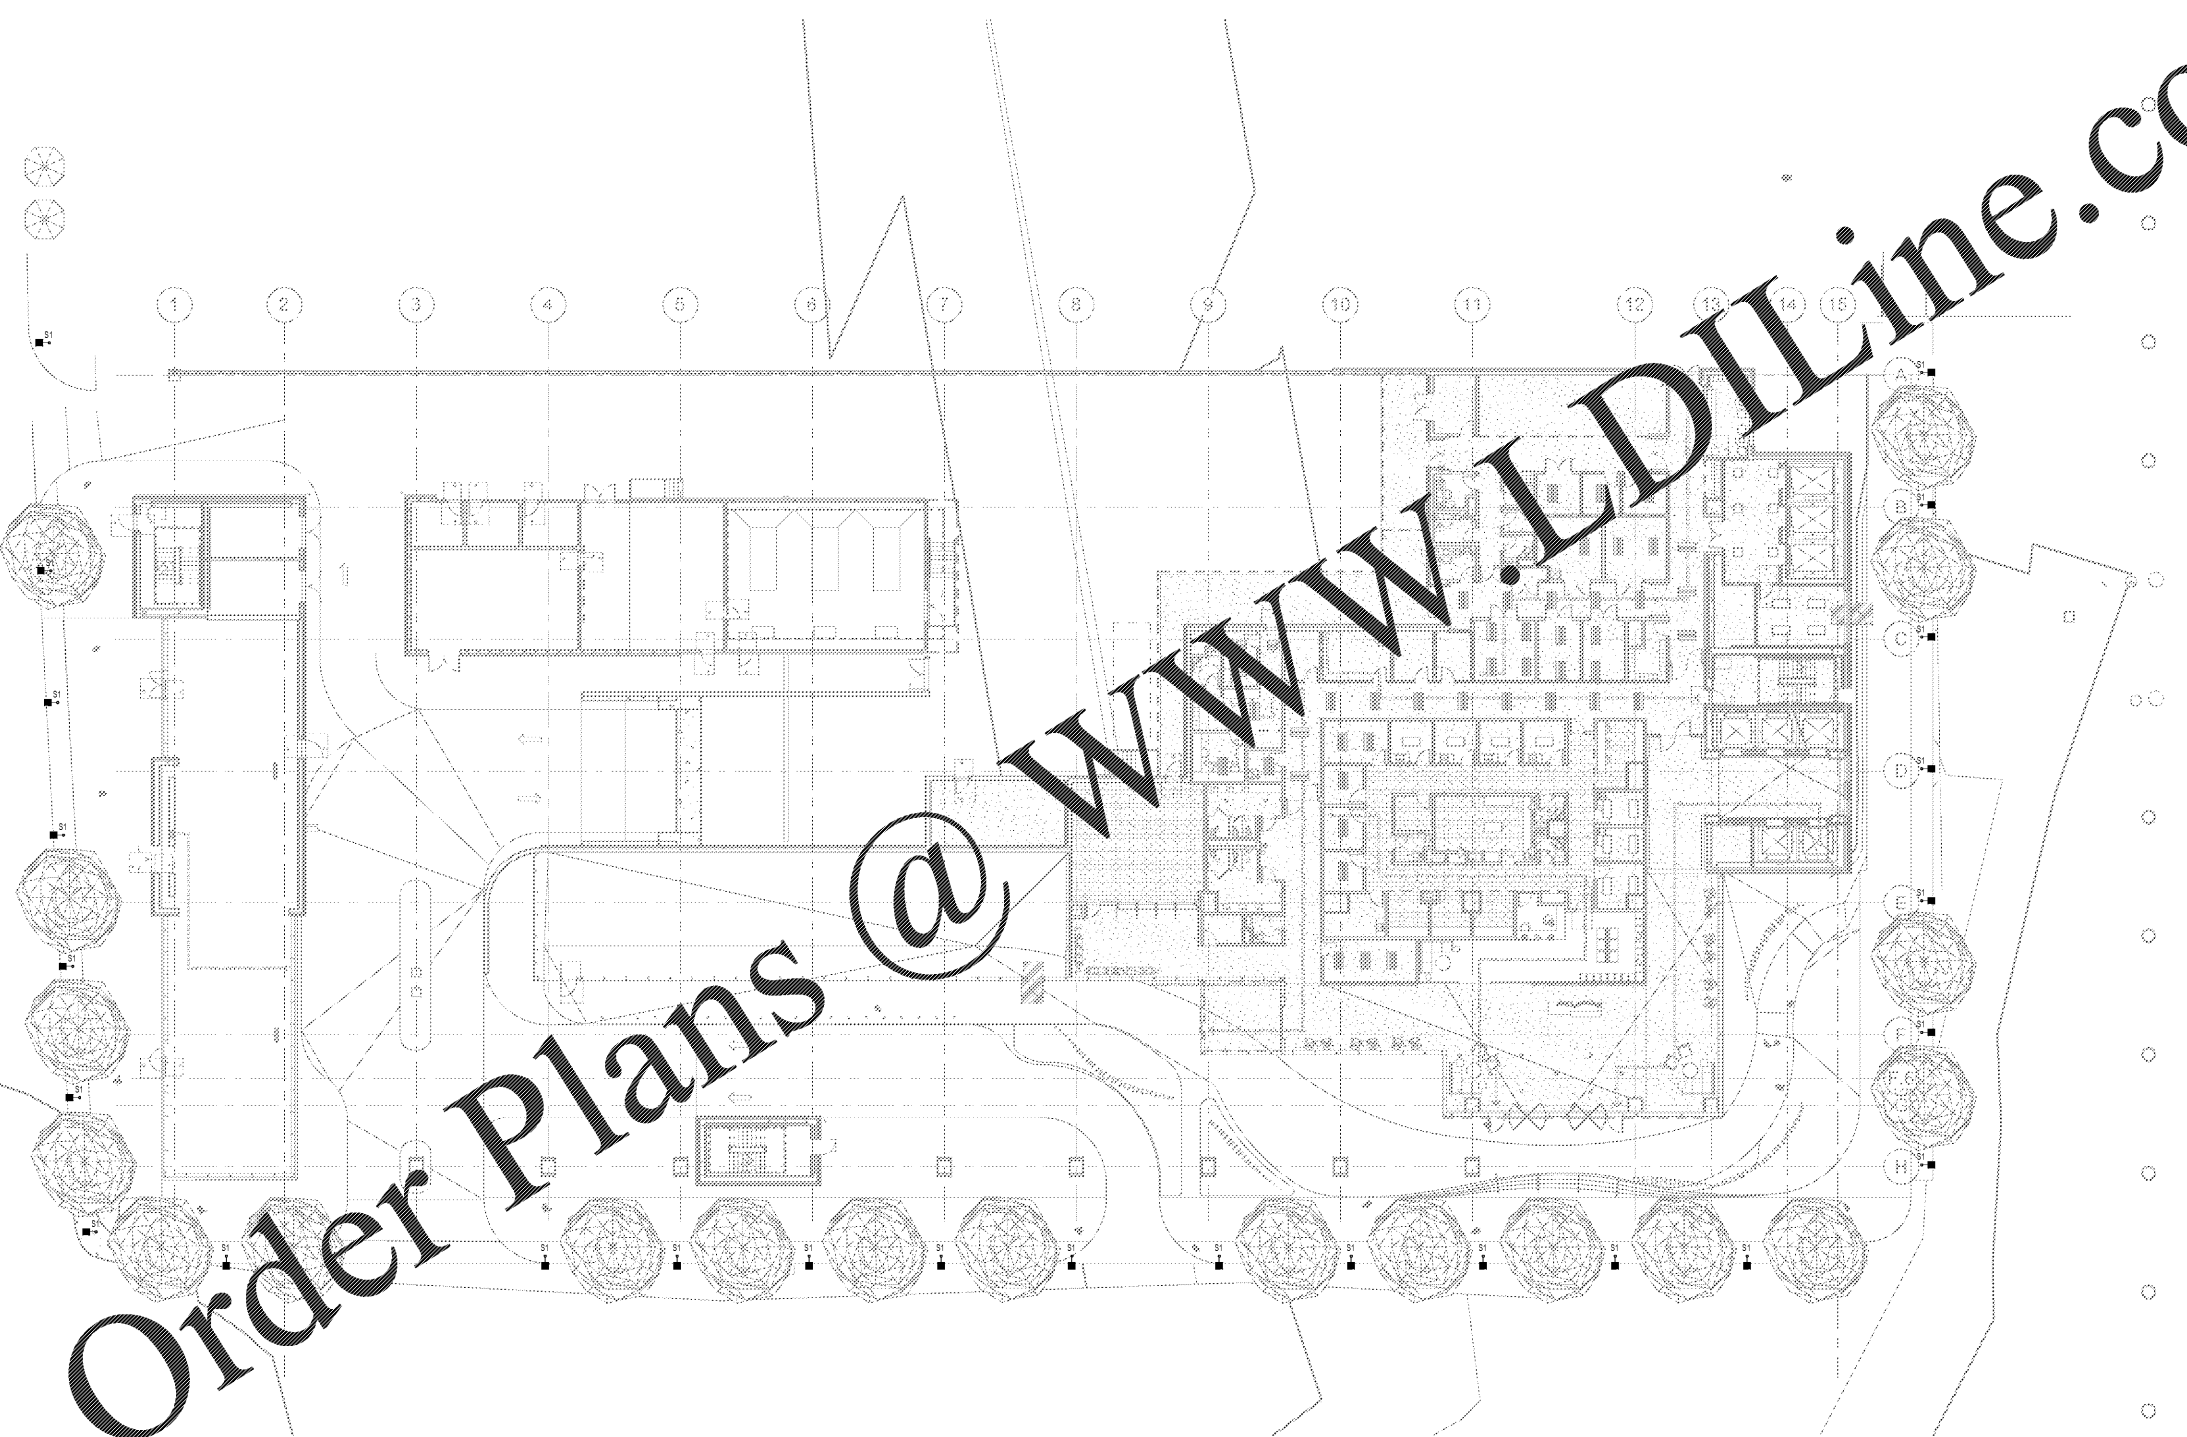

1 SITE PLAN - ELECTRICAL
1/16" = 1'-0"

Order Plans @ WWW.LDILine.com