



Project
**THE CENTER FOR
ADVANCED SURGICAL
SERVICES (CASS)**
88 JESSE HILL DRIVE
ATLANTA, GA 30303


Prepared For
GRADY HEALTH SYSTEM
80 JESSE HILL DR. SE
ATLANTA, GA 30303



Hellmuth, Obata & Kassabaum, Inc.
191 Peachtree Street, NE, Suite 2250
Atlanta, GA 30303 USA
T+1 404 439 9000 F+1 404 439 9001

All reproduction & intellectual property rights reserved ©
2019.

In Association with
TLC ENGINEERING
255 S. Orange Avenue
Suite 1500
Orlando, FL 32801
P: 407.841.0050
www.tlcengineering.com
CCA PE#002960
TLC No. 118549
TPO/MS, L18220K, CASSA19

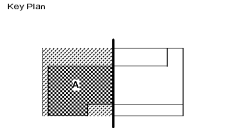

Professional Seal
Emory Neal Boothe, P.E.
Georgia License #PE039005

**NOT FOR
CONSTRUCTION**


| No. | Description | Date |
|-----|-------------|------------|
| 1 | DD - GMP | 2019-07-05 |

Project No: 18-16013.00
Sheet Title
**LEVEL 3 FLOOR PLAN -
WEST - POWER**

Original is 30 x 42. Do not scale contents of this drawing.
Sheet Number
E203A

- GENERAL POWER PLAN NOTES:**
1. VERIFY AND COORDINATE EXACT ELECTRICAL REQUIREMENTS OF ALL EQUIPMENT WITH MANUFACTURER'S RECOMMENDATIONS PRIOR TO INSTALLATION OF EQUIPMENT. MODIFY LAYOUT AS REQUIRED PER MANUFACTURER'S SPACE REQUIREMENTS.
 2. REFER TO ARCHITECTURAL ELEVATIONS AND CASEWORK DRAWINGS FOR FINAL MOUNTING HEIGHTS AND INSTALLATION REQUIREMENTS OF ALL DEVICES. UNLESS NOTED OTHERWISE, ARCHITECTURAL ELEVATIONS SHALL DICTATE MOUNTING HEIGHTS OF ALL FIXTURES AND DEVICES.
 3. COORDINATE FINAL LOCATIONS OF ALL DIVISION 23 EQUIPMENT IN FIELD WITH DIVISION 23 EQUIPMENT. FIELD LOCATIONS SHALL DICTATE.
 4. COORDINATE MOUNTING HEIGHTS AND LOCATIONS OF ALL DEVICES WITH ARCHITECTURAL ELEVATIONS AND CASEWORK.
 5. CRITICAL BRANCH WIRING FROM ANY PANEL DOWNSTREAM OF AUTOMATIC TRANSFER SWITCHES ATS-01 AND ATS-02 SHALL NOT BE ON THE SAME RACEWAY. CONTRACTOR SHALL MAINTAIN SEPARATION OF THESE TRANSFER SWITCHES AND THEIR DISTRIBUTION ALL THE WAY TO THE LOADS.

REFER TO R. POWELL & ASSOCIATES DRAWINGS FOR WORK IN THIS AREA.

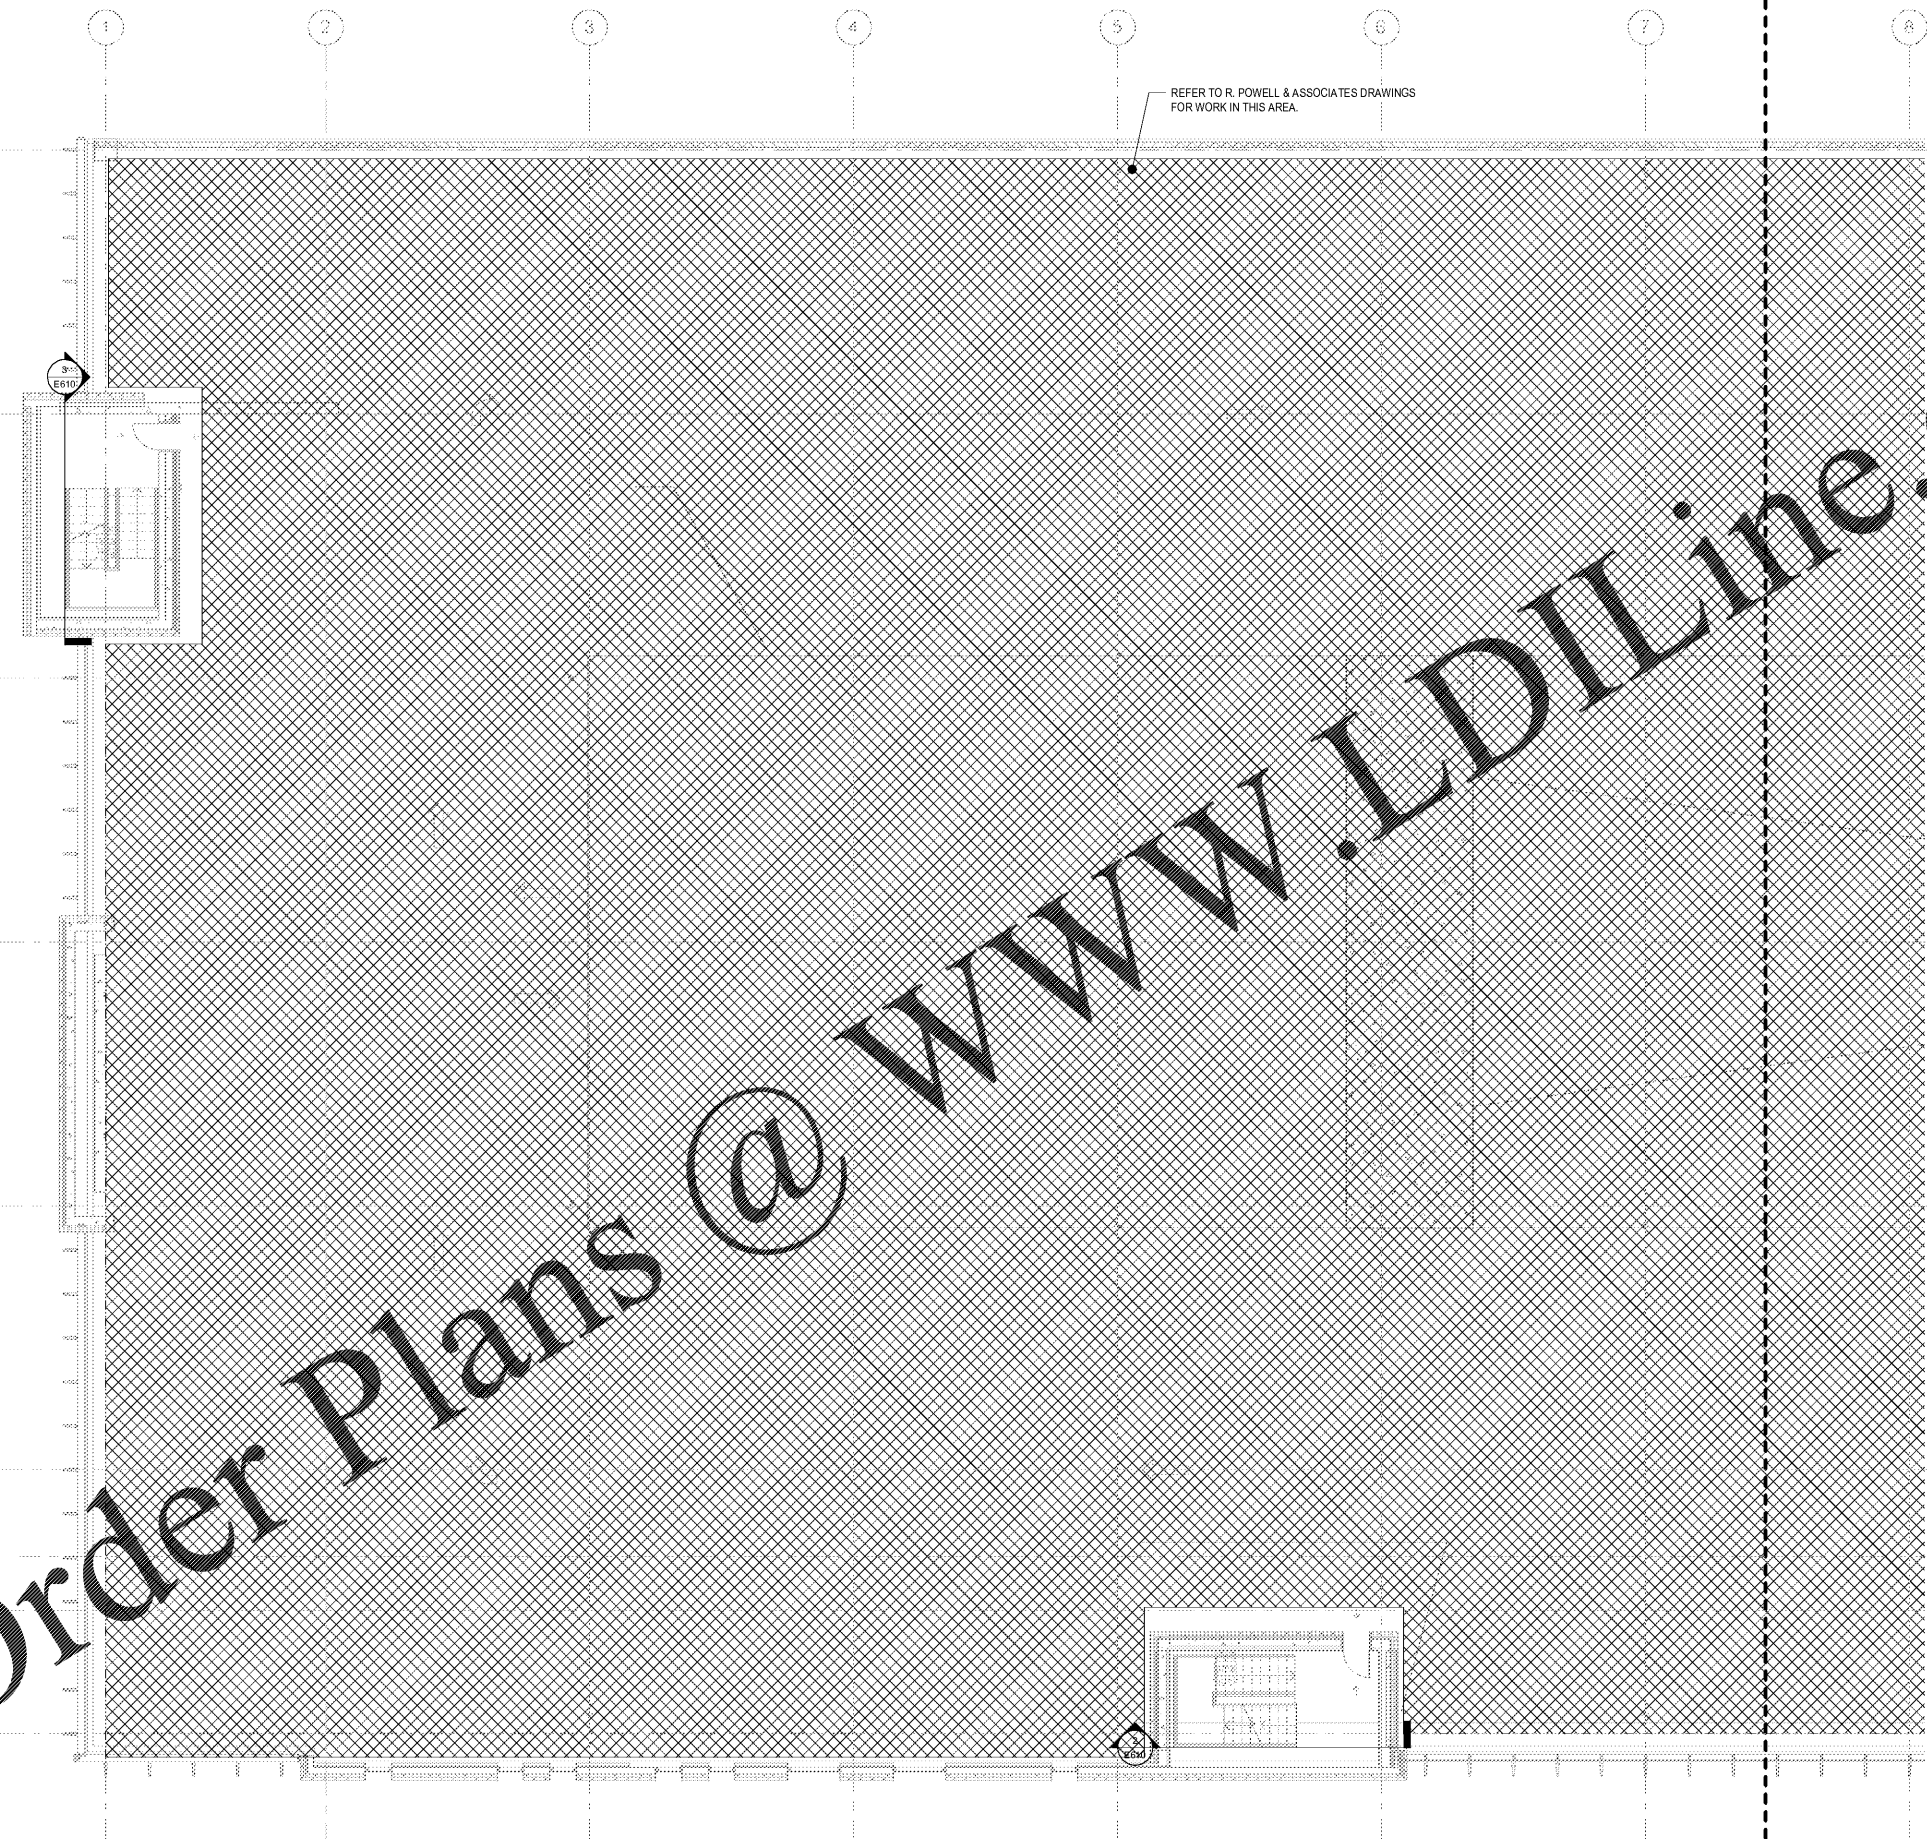

Order Plans @ www.LDILLINE.com

1 FLOOR PLAN - LEVEL 3 - WEST - POWER
1/8" = 1'-0"