



 
Project
**THE CENTER FOR
 ADVANCED SURGICAL
 SERVICES (CASS)**
 88 JESSE HILL DRIVE
 ATLANTA, GA 30303

Prepared For
GRADY HEALTH SYSTEM
 80 JESSE HILL DR. SE
 ATLANTA, GA 30303




Hellmuth, Obata & Kassabaum, Inc.
 191 Peachtree Street, NE, Suite 2250
 Atlanta, GA 30303 USA
 T+1 404 439 9000 F+1 404 439 9001

All reproduction & intellectual property rights reserved ©
 2019
 In Association with



Key Plan

 

Professional Seal
 Emory Neal Boothe, P.E.
 Georgia License #PE039005

**NOT FOR
 CONSTRUCTION**


No.	Description	Date
1	DD - GMP	2019-07-03

Project No: 18.16013.00
 Sheet Title

**LEVEL 2 FLOOR PLAN -
 WEST - LIGHTING**

Original is 30 x 42. Do not scale contents of this drawing.
 Sheet Number

E302A

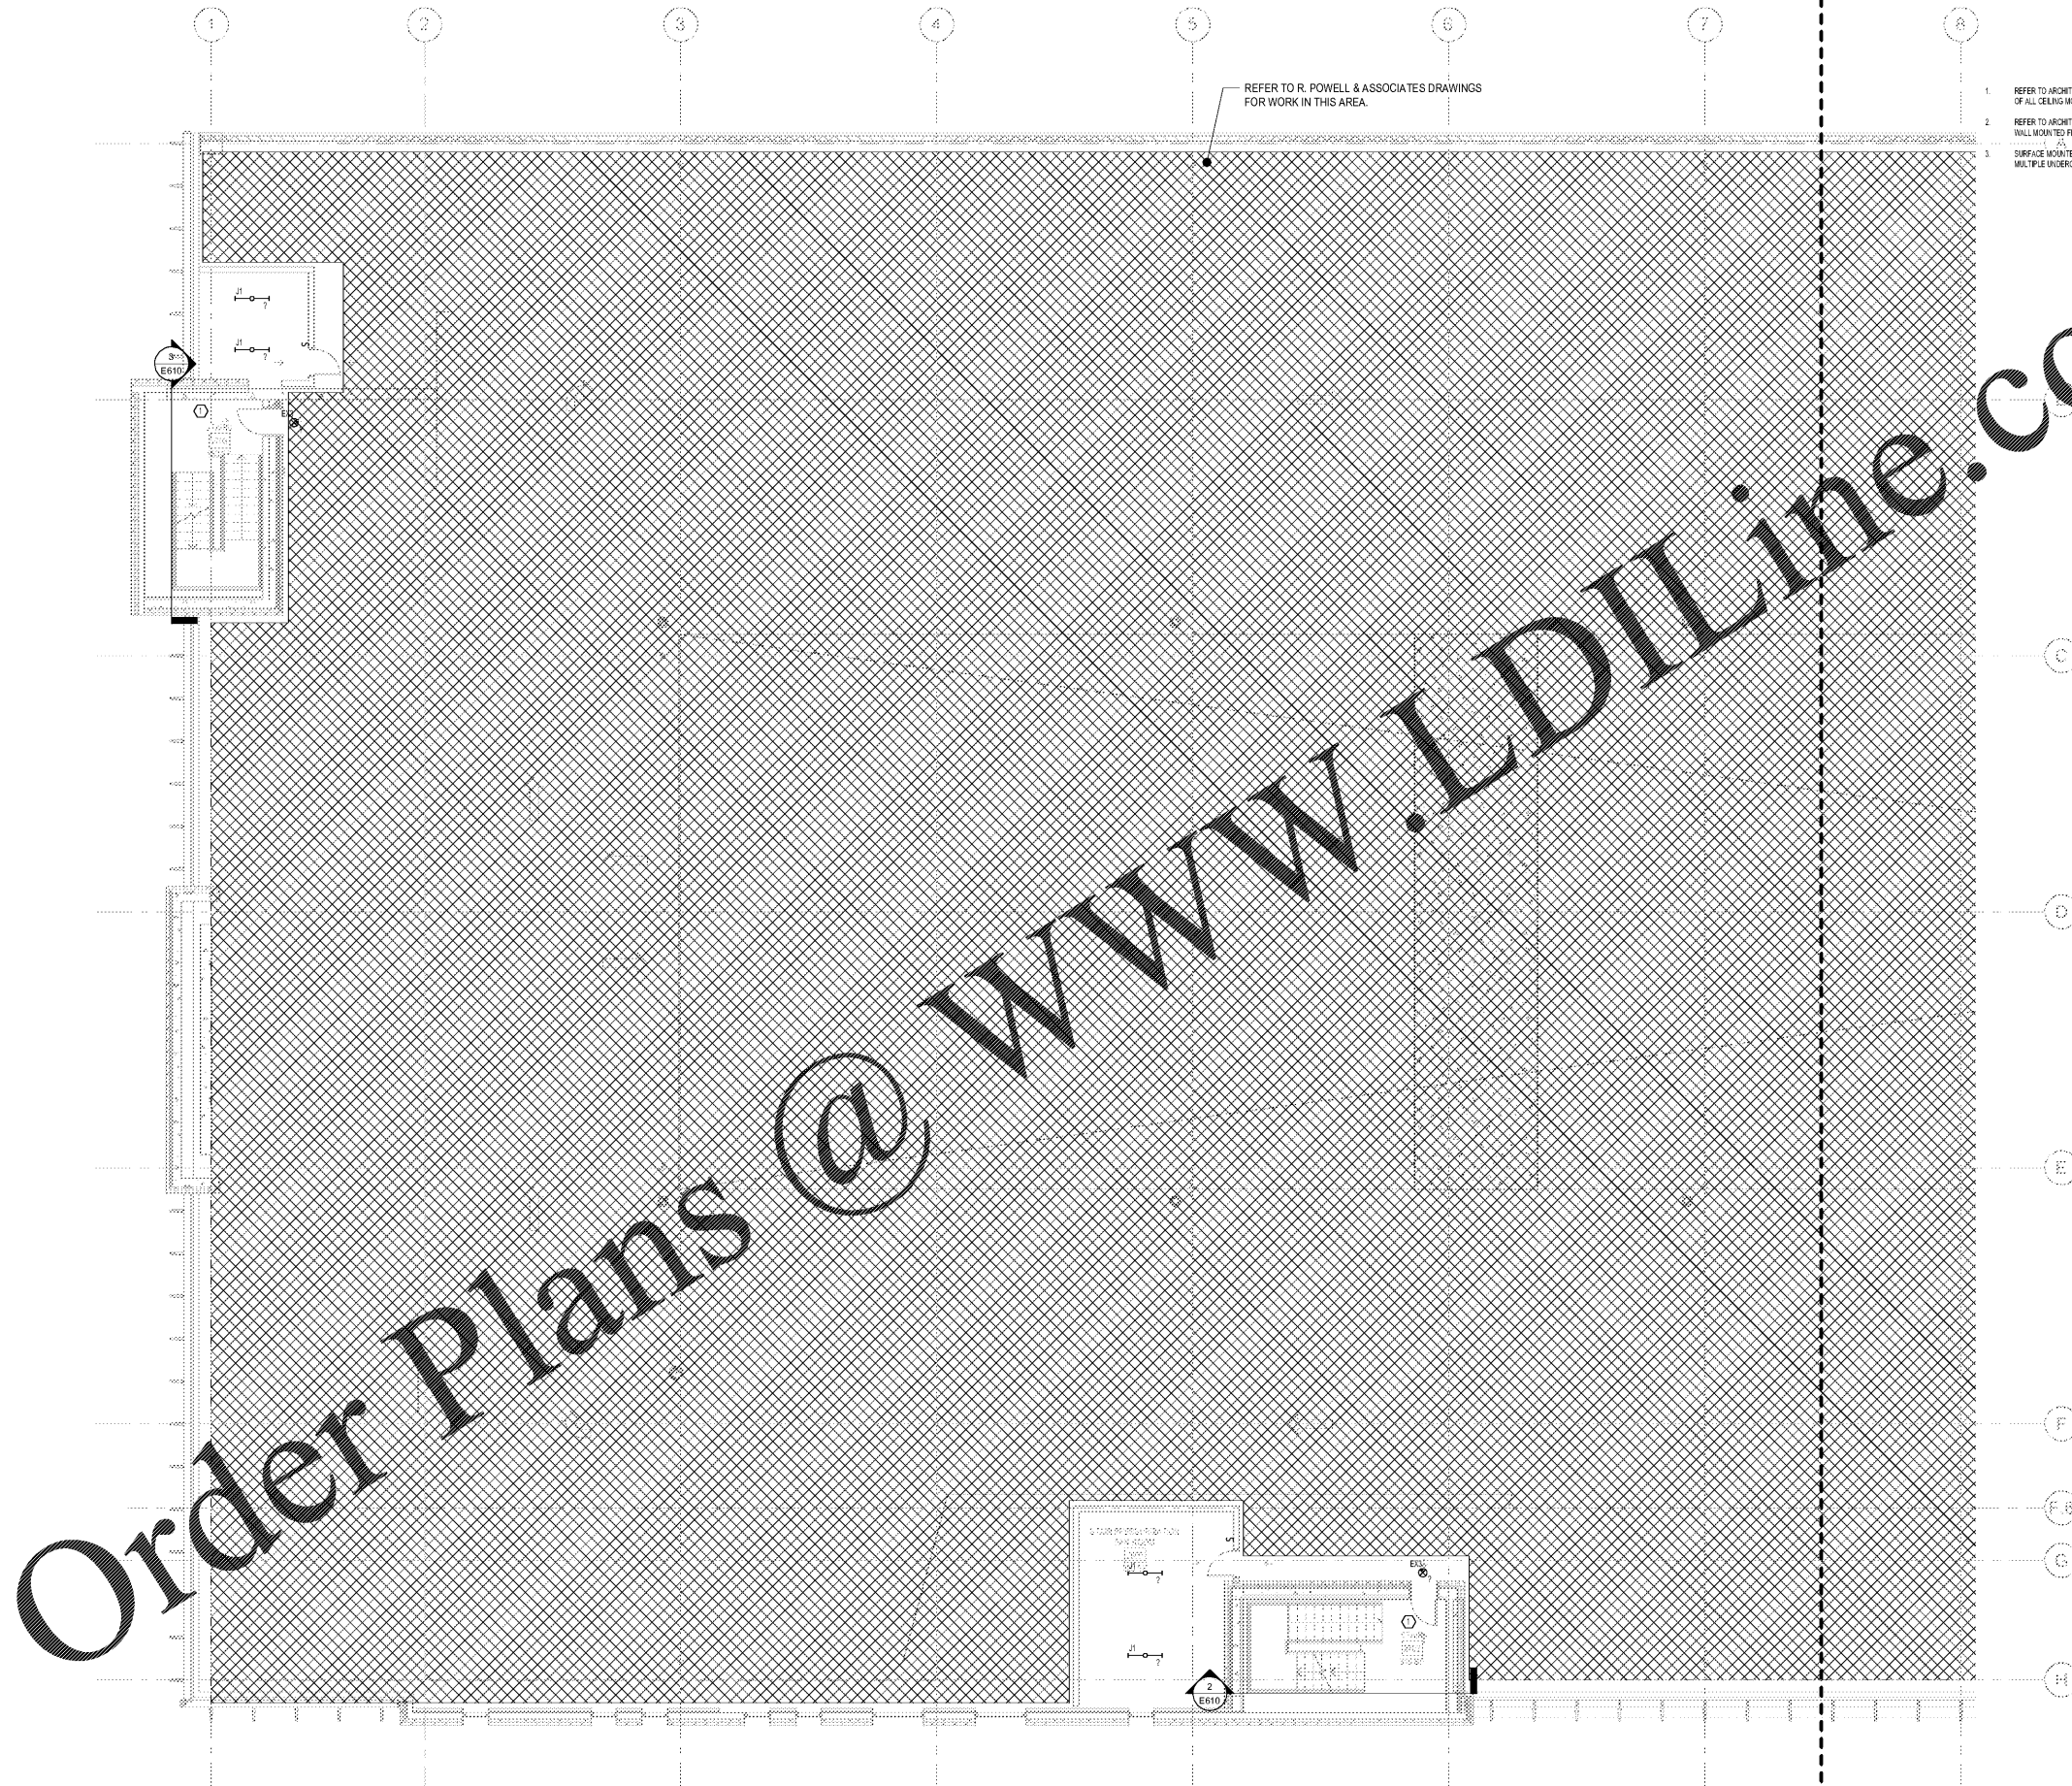

REFER TO R. POWELL & ASSOCIATES DRAWINGS
 FOR WORK IN THIS AREA.

- GENERAL LIGHTING PLAN NOTES:**
- REFER TO ARCHITECTURAL CEILING PLANS FOR FINAL PLACEMENT AND LOCATION OF ALL CEILING MOUNTED LIGHT FIXTURES.
 - REFER TO ARCHITECTURAL ELEVATIONS FOR FINAL MOUNTING HEIGHTS OF ALL WALL MOUNTED FIXTURES.
 - SURFACE MOUNTED RACKWAY IS NOT PERMITTED FOR INTERCONNECTIONS BETWEEN MULTIPLE UNDERCABINET LIGHT FIXTURES. BACKFEED ALL FIXTURES.

REFER TO SHEET 18.16013.01 FOR WALL
 SWITCHING INFORMATION.

1 FLOOR PLAN - LEVEL 2 - WEST - LIGHTING
 1/8" = 1'-0"