

Order Plans @ WWW.JDIDLINE.COM

- GENERAL LIGHTING PLAN NOTES
1. REFER TO ARCHITECTURAL CEILING PLANS FOR FINAL PLACEMENT AND LOCATION OF ALL CEILING MOUNTED LIGHT FIXTURES.
 2. REFER TO ARCHITECTURAL ELEVATIONS FOR FINAL MOUNTING HEIGHTS OF ALL WALL MOUNTED FIXTURES.
 3. SURFACE MOUNTED RAYWAY IS NOT PERMITTED FOR INTERCONNECTIONS BETWEEN MULTIPLE UNDERCABINET LIGHT FIXTURES. BACKFEED ALL FIXTURES.



Project
**THE CENTER FOR
 ADVANCED SURGICAL
 SERVICES (CASS)**
 88 JESSE HILL DRIVE
 ATLANTA, GA 30303

Prepared For
GRADY HEALTH SYSTEM
 80 JESSE HILL DR. SE
 ATLANTA, GA 30303




Hellmuth, Obata & Kassabaum, Inc.
 191 Peachtree Street, NE, Suite 2250
 Atlanta, GA 30303 USA
 T+1 404 439 9000 F+1 404 439 9001

All reproduction & intellectual property rights reserved © 2019

in Association with

TLC ENGINEERING
 255 S. Orange Avenue
 Suite 1400
 Orlando, FL 32801
 P 407.841.0050
 CDA PEF022860
 www.tlc-engineers.com
 TLC No. 118548
 TYPING: L16720K- C262A19

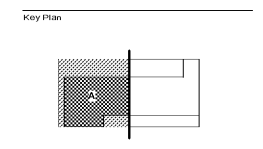

Professional Seal
 Emory Neal Boothe, P.E.
 Georgia License #PE039005


**NOT FOR
 CONSTRUCTION**

No.	Description	Date
1	DD - GMP	2019-07-03

Project No: 18.16013.00
 Sheet Title
**LEVEL 5 FLOOR PLAN -
 WEST - LIGHTING**

Original is 30 x 42. Do not scale contents of this drawing.
 Sheet Number

E305A

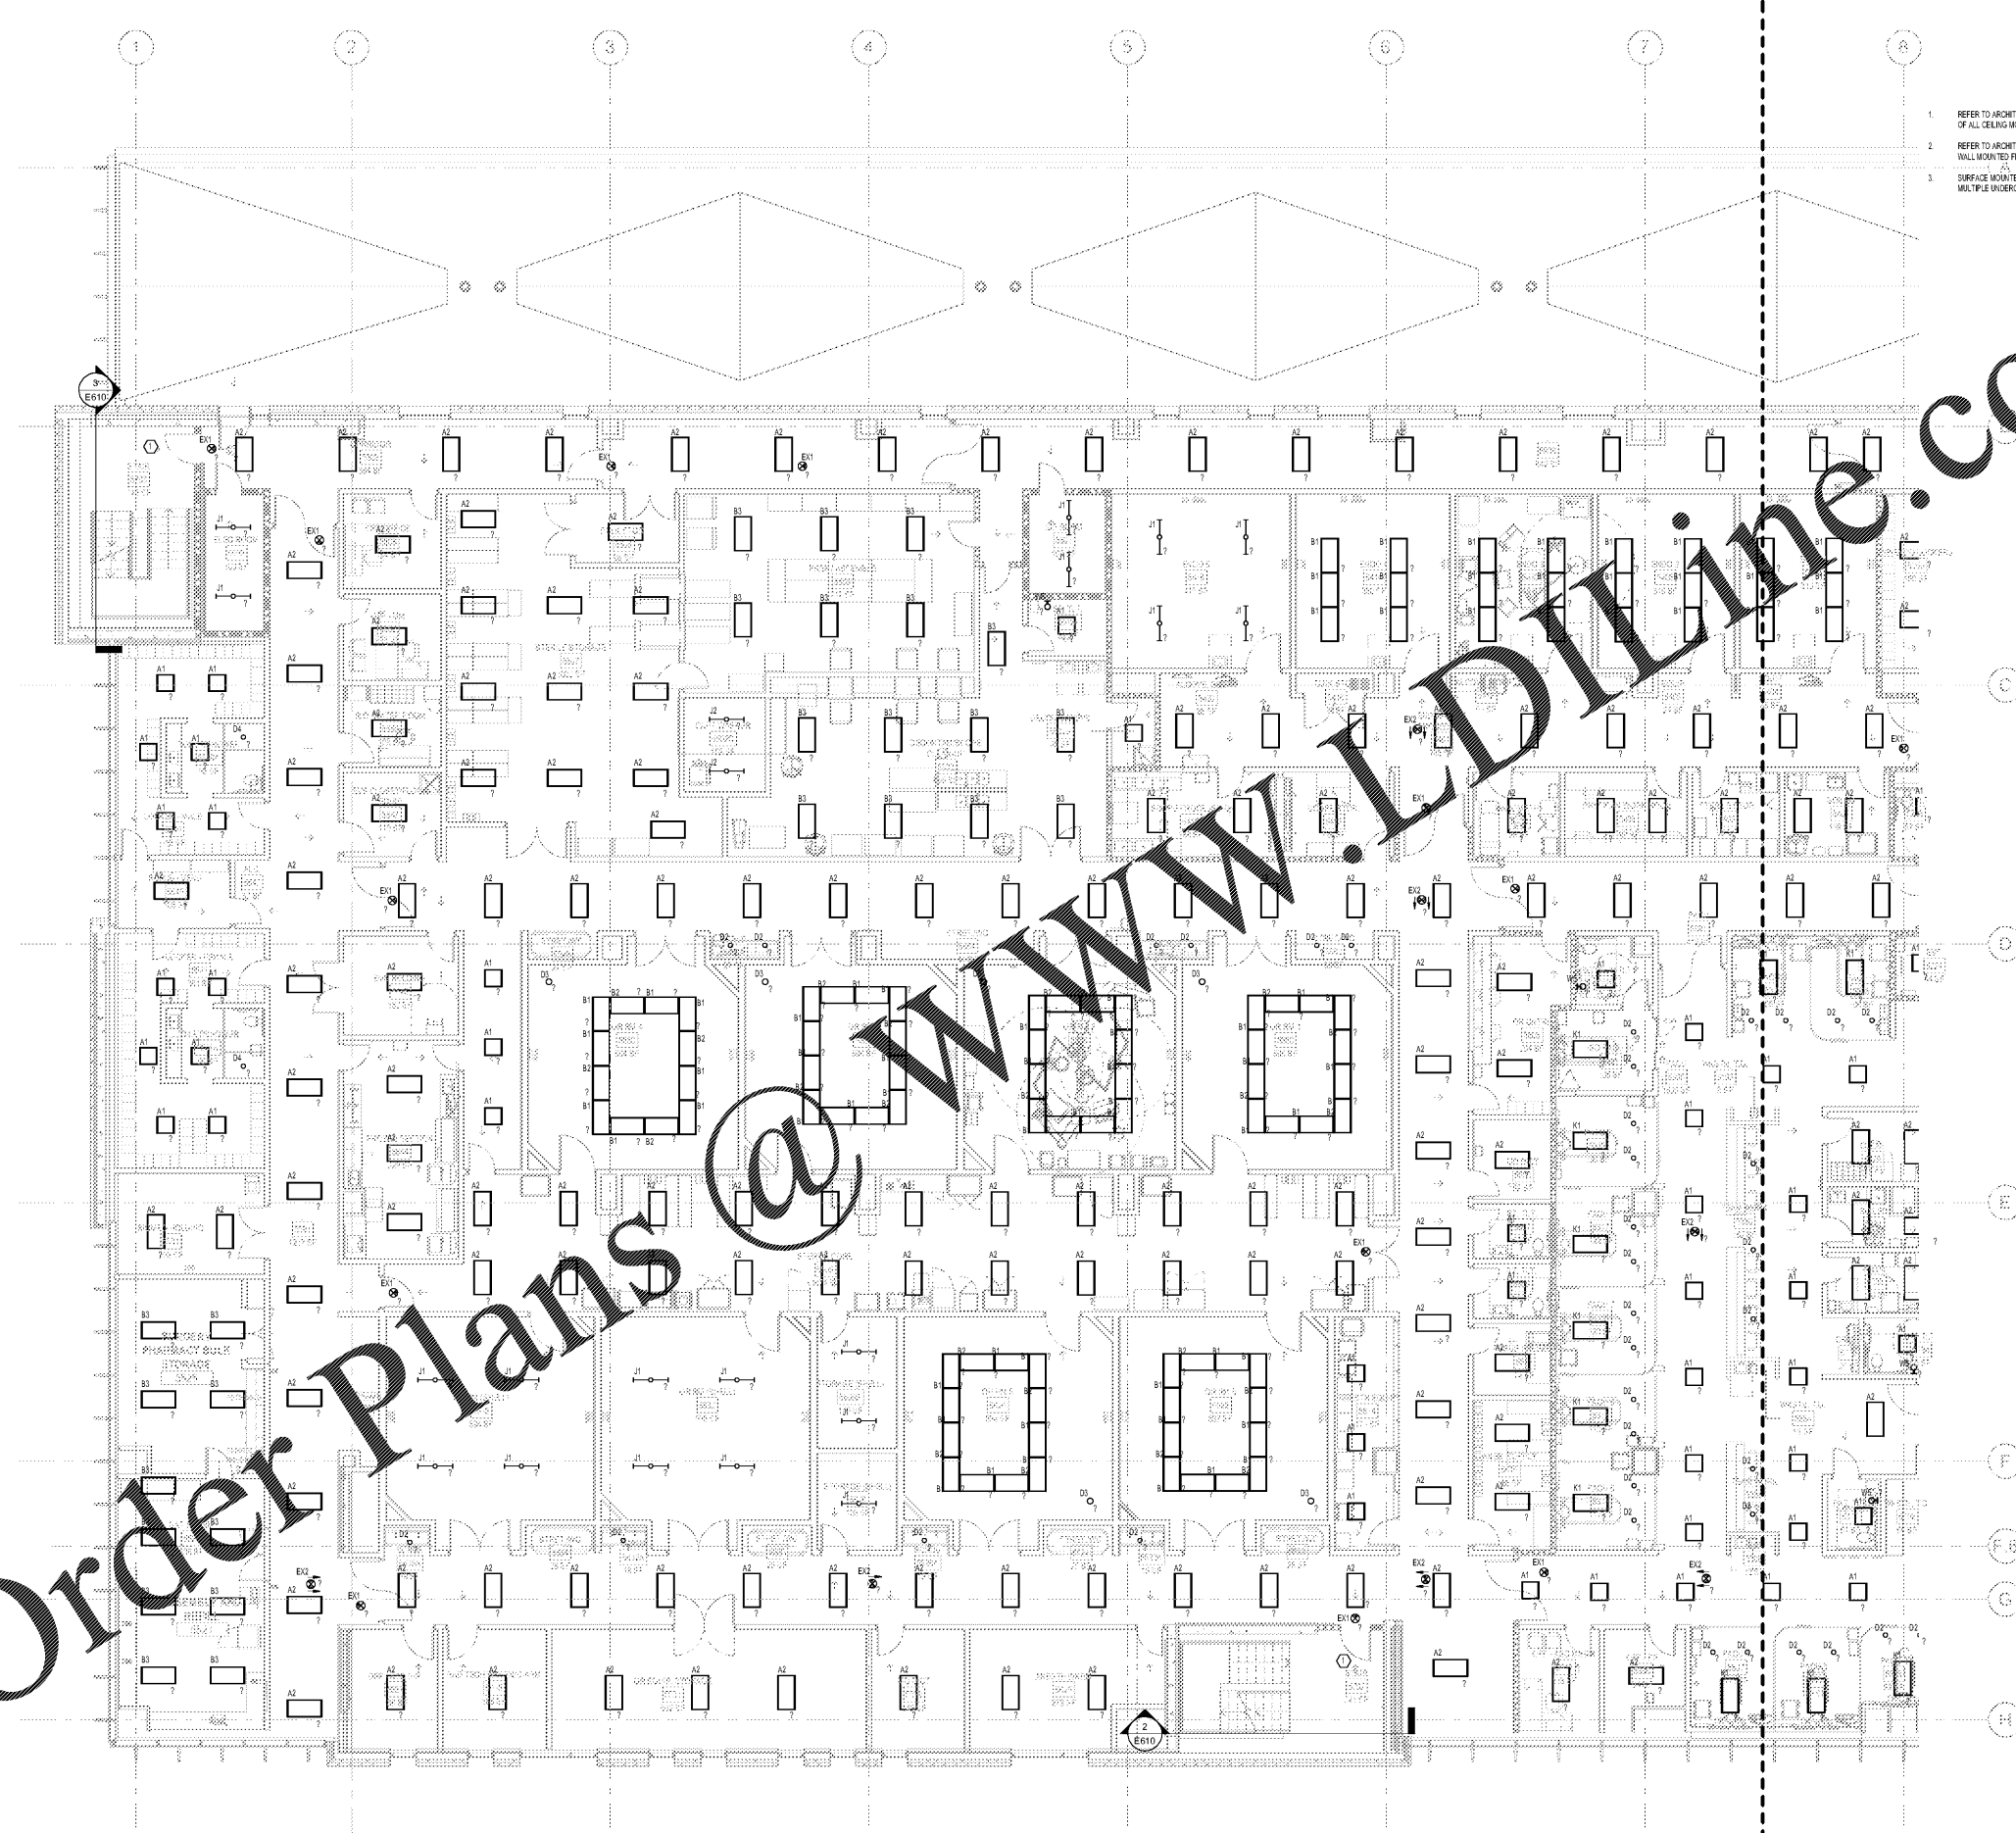

1 FLOOR PLAN - LEVEL 5 - WEST - LIGHTING
 1/8" = 1'-0"