

ELECTRICAL KEYNOTES



Project
**THE CENTER FOR
ADVANCED SURGICAL
SERVICES (CASS)**
88 JESSE HILL DRIVE
ATLANTA, GA 30303

Prepared For
GRADY HEALTH SYSTEM
80 JESSE HILL DR, SE
ATLANTA, GA 30303



Helmut Obata & Koessbaum, Inc.
191 Peachtree Street, NE, Suite 2250
Atlanta, GA 30303 USA
Tel: 404.438.8000 Fax: 404.438.8001

All reproduction & intellectual property rights reserved © 2019



Key Plan



Professional Seal
Roosevelt Powell, P.E.
Georgia License #PE21592

**NOT FOR
CONSTRUCTION**

Revision table with columns: No., Description, Date


1. SCHEMATIC DESIGN 2018.11.21
2. SCHEMATIC DESIGN-UPDATE 2019.03.18

Project No: 18.16013.00
Sheet Title

**LEVEL 3 FLOOR PLAN -
WEST - LIGHTING**

Original is 30 x 42. Do not scale contents of this drawing.
Sheet Number

E313A

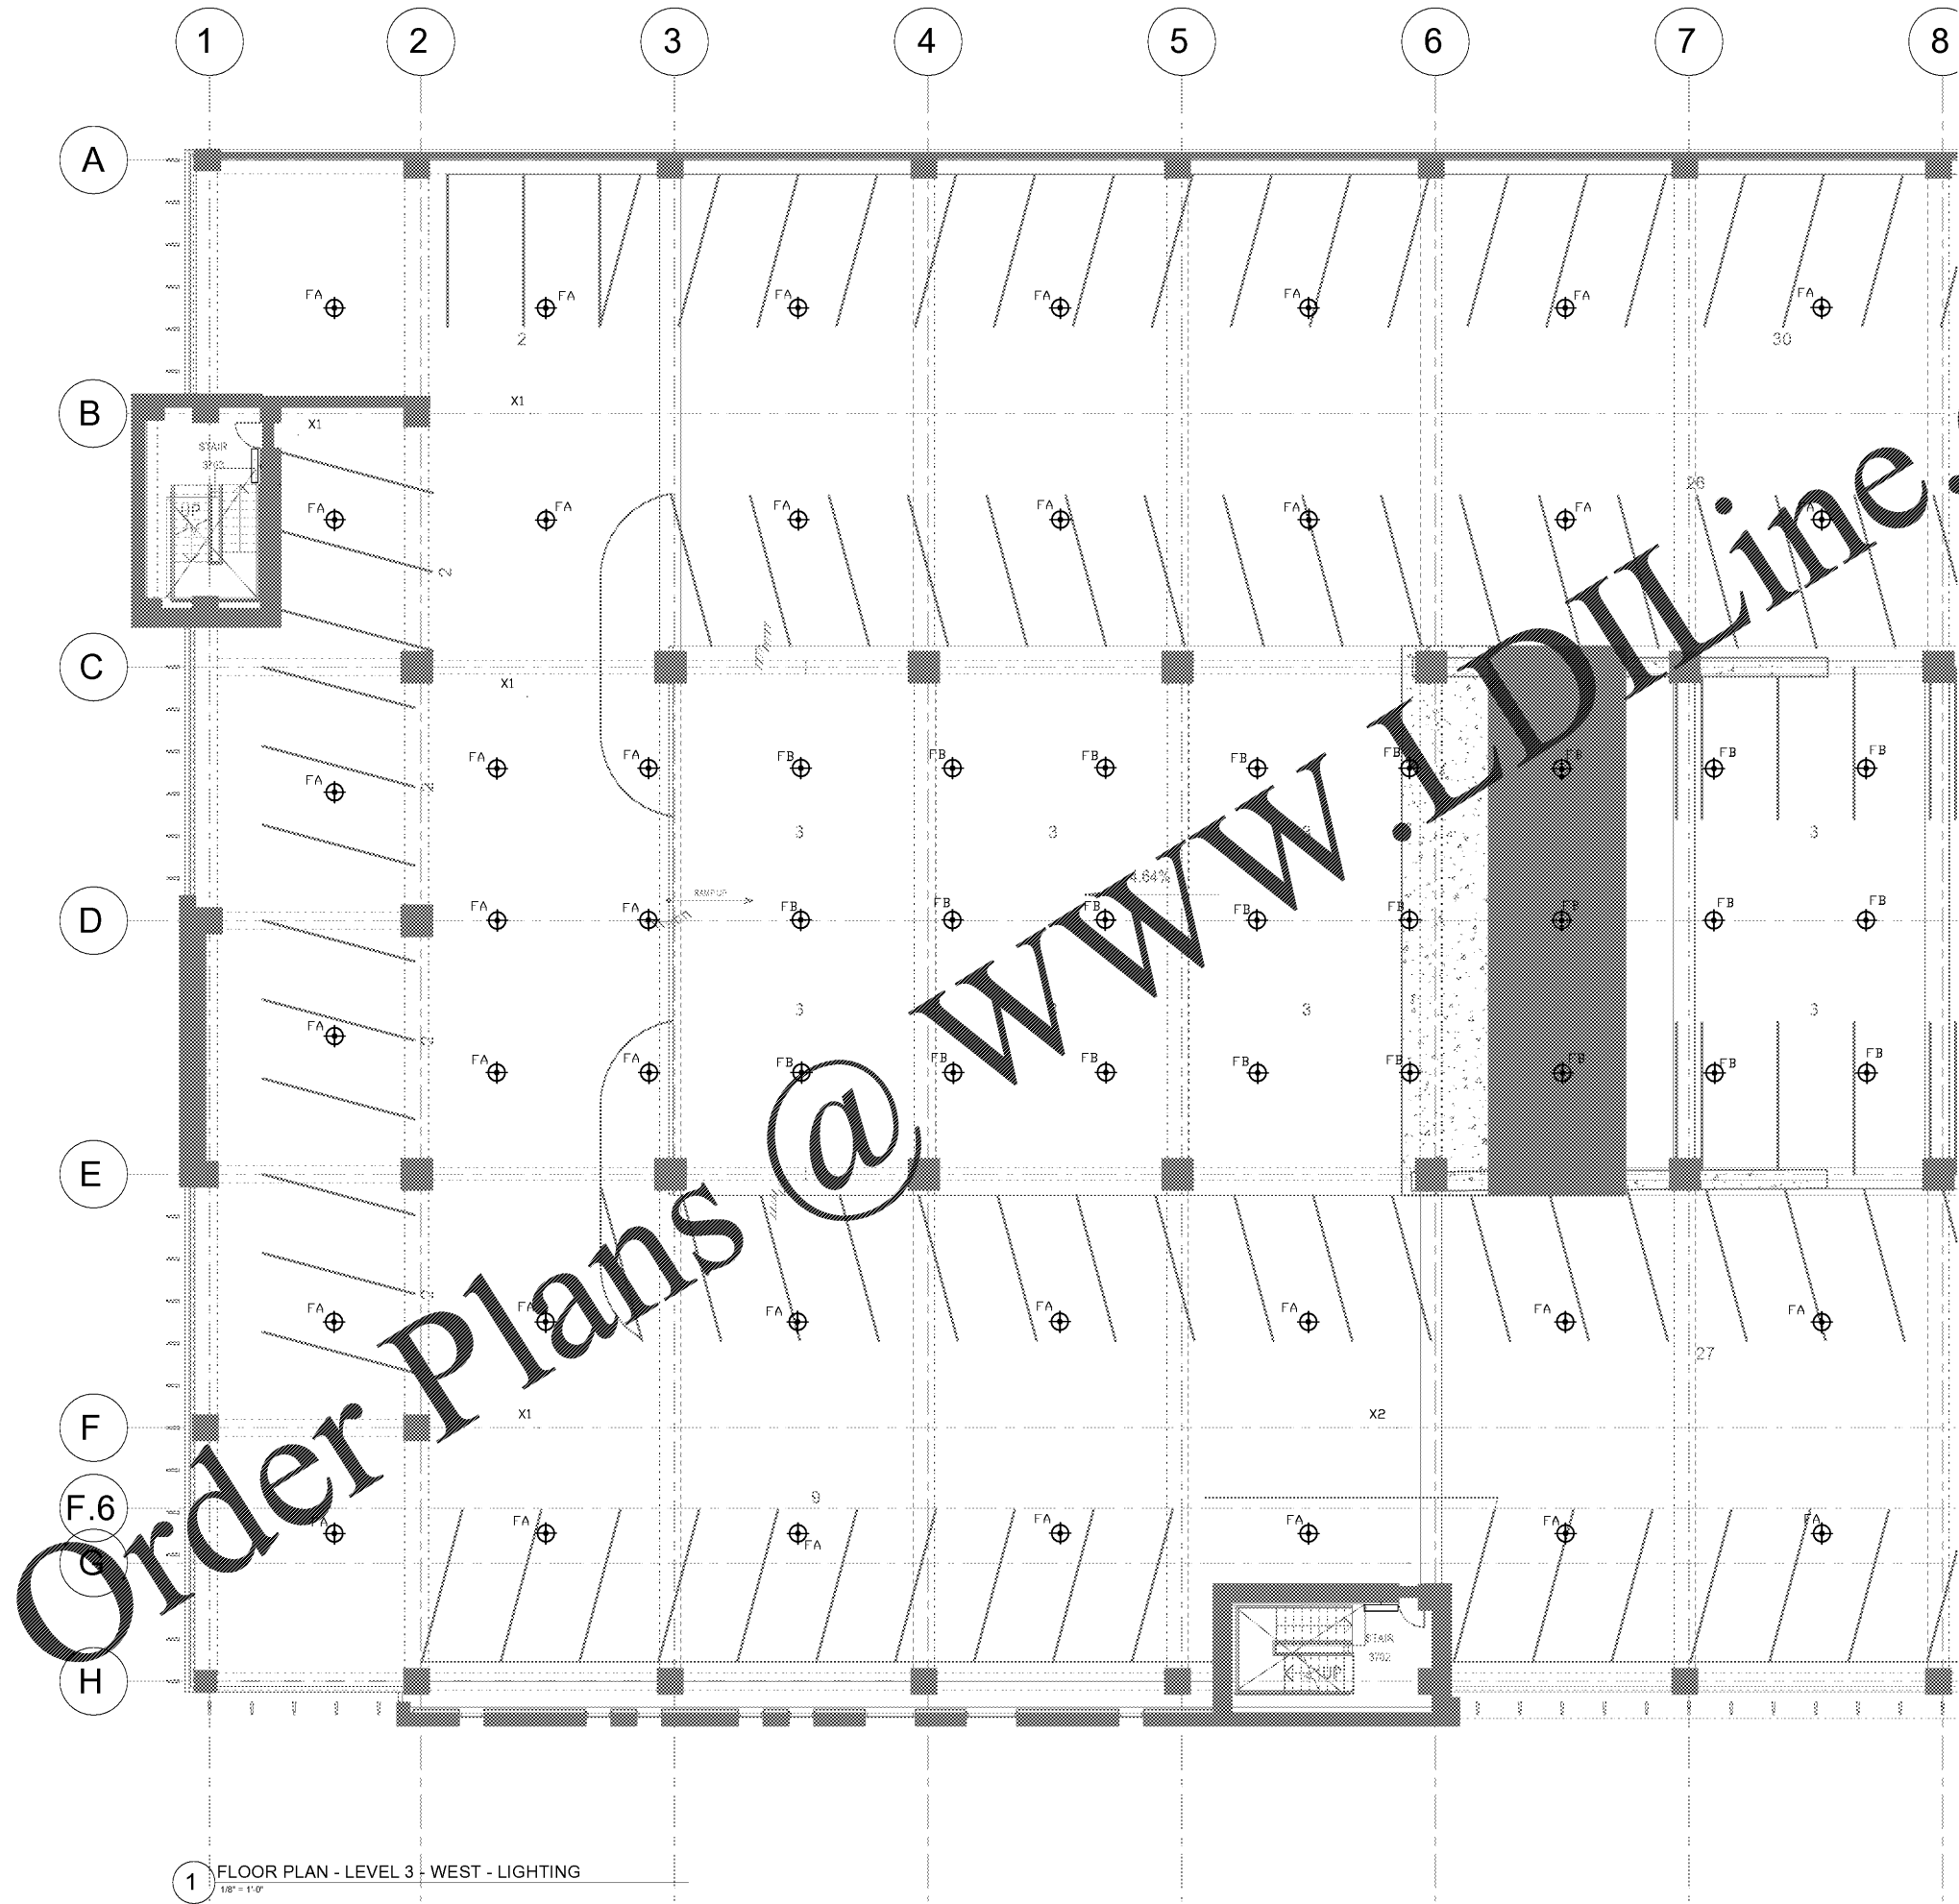

Order Plans @ WWW.LDIDLINE.com

1 FLOOR PLAN - LEVEL 3 - WEST - LIGHTING
1/8" = 1'-0"