



Project
THE CENTER FOR
ADVANCED SURGICAL
SERVICES (CASS)
88 JESSE HILL DRIVE
ATLANTA, GA 30303

Prepared For
GRADY HEALTH SYSTEM
80 JESSE HILL DR, SE
ATLANTA, GA 30303



 
Hellmuth, Obata & Kassabaum, Inc.
191 Peachtree Street, NE, Suite 2250
Atlanta, GA 30303 USA
T+1 404 439 9000 F+1 404 439 9001

All reproduction & intellectual property rights reserved © 2019

In Association with

TLC ENGINEERING
355 S. Orange Avenue
Suite 1500
Orlando, FL 32801
P: 407.841.0992
www.tlc-engineers.com
FL License: 116648
CDL License: 116648
TLC No. 116648

Key Plan



Professional Seal
Emory Neal Boothe, P.E.
Georgia License #PE039005

**NOT FOR
CONSTRUCTION**

No.	Description	Date
1	DD - GMP	2019-07-03

Project No: 18.16013.00
Sheet Title


**GROUND FLOOR PLAN
- WEST - FIRE ALARM**

Original is 20 x 42. Do not scale contents of this drawing.
Sheet Number

E400A

- GENERAL FIRE ALARM PLAN NOTES:
- REFER TO FIRE ALARM SYMBOL LEGEND FOR DETAILED REQUIREMENTS FOR ALL FIRE ALARM DEVICE INSTALLATIONS.
 - REFER TO ARCHITECTURAL ELEVATIONS FOR FINAL MOUNTING HEIGHTS OF ALL DEVICES. UNLESS NOTED OTHERWISE, ARCHITECTURAL ELEVATIONS SHALL DICTATE MOUNTING HEIGHTS OF ALL DEVICES.
 - VERIFY AND COORDINATE EXACT ELECTRICAL REQUIREMENTS OF ALL EQUIPMENT WITH MANUFACTURER'S RECOMMENDATIONS PRIOR TO INSTALLATION OF EQUIPMENT.
 - FIRE ALARM CONTRACTOR SHALL FULLY TEST ALL INITIATING DEVICES WITHIN THE SMOKE COMPARTMENT TO ENSURE THAT ALL DEVICES ARE CORRECTLY INITIATING THE CORRECT SMOKE COMPARTMENT IDENTIFICATION, AS SHOWN ON THE LIFE SAFETY PLANS. CONTRACTOR SHALL CORRECT ANY AND ALL DISCREPANCIES FOUND DURING SAID TESTING PROCEDURE.
 - REFER TO THE FIRE ALARM SYSTEM RISER DIAGRAM FOR ADDITIONAL INFORMATION.
 - UNLESS NOTED OTHERWISE, EACH FIRE COMPARTMENT SHALL BE A FIRE EVACUATION ZONE.
 - REFER TO MECHANICAL DRAWINGS FOR QUANTITIES AND LOCATIONS OF ALL FRO DOOR COMPARTMENTS. NOTIFY SMOKE CONTRACTORS. THESE DEVICES SHALL BE PROVIDED BY THE SMOKE CONTRACTOR, REGARDLESS OF IF THEY ARE SHOWN ON THE FIRE ALARM DRAWING OR NOT.
 - REFER TO MECHANICAL DRAWINGS FOR QUANTITIES AND LOCATIONS OF ALL FLOW AND THROUGH SMOKE DEVICES. THESE DEVICES SHALL BE PROVIDED BY THE FIRE ALARM CONTRACTOR, REGARDLESS OF IF THEY ARE SHOWN ON THE FIRE ALARM DRAWING OR NOT.

KEY NOTES

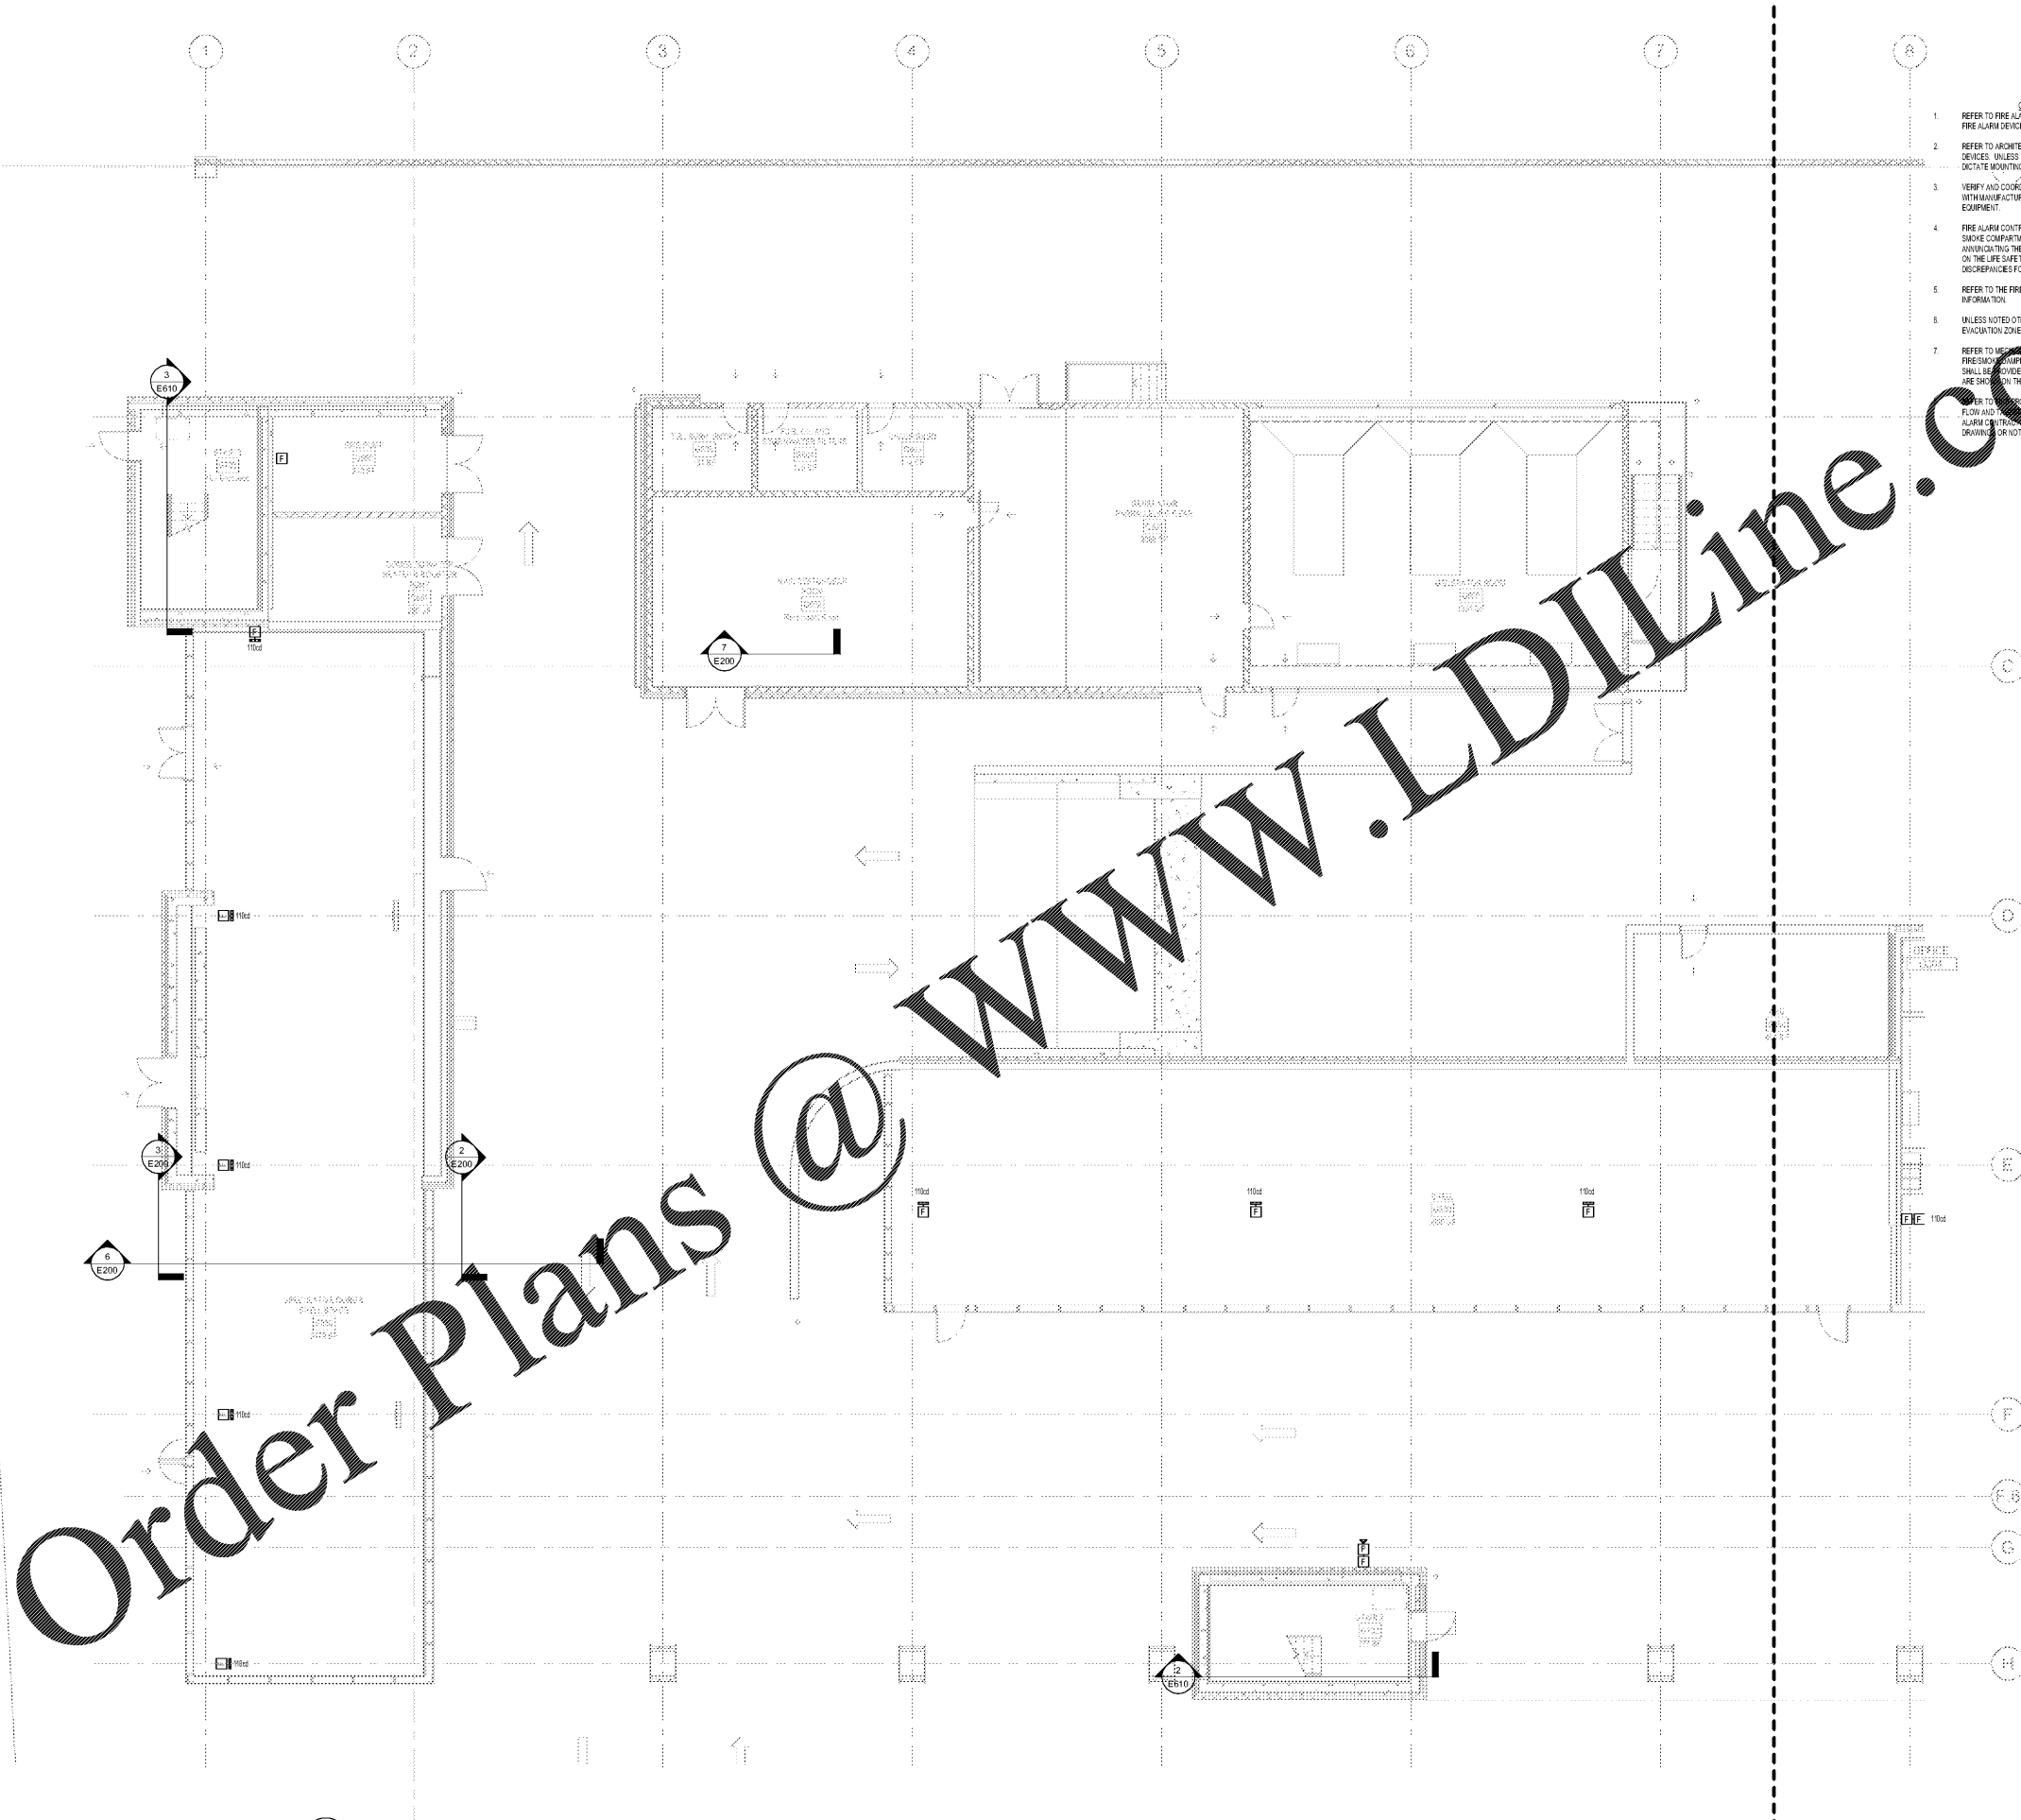

1 FLOOR PLAN - GROUND LEVEL - WEST - FIRE ALARM
1/8" = 1'-0"