

ELECTRICAL KEYNOTES



Project  
**THE CENTER FOR  
ADVANCED SURGICAL  
SERVICES (CASS)**  
88 JESSE HILL DRIVE  
ATLANTA, GA 30303

Prepared For  
**GRADY HEALTH SYSTEM**  
80 JESSE HILL DR, SE  
ATLANTA, GA 30303



Hellmuth, Obata & Kassabaum, Inc.  
191 Peachtree Street, NE, Suite 2250  
Atlanta, GA 30303 USA  
Tel: 404.438.8000 Fax: 404.438.8001

All reproduction & intellectual property rights reserved ©  
2019



Key Plan



Professional Seal  
Roosevelt Powell, P.E.  
Georgia License #PE21562

**NOT FOR  
CONSTRUCTION**

No.	Description	Date
1	DD - GMP	2019-07-01

1	SCHEMATIC DESIGN	2018.11.31
2	SCHEMATIC DESIGN - UPDATE	2019.03.19

Project No: **18.16013.00**


Sheet Title

**LEVEL 2 FLOOR PLAN -  
WEST - FIRE ALARM**

Original is 30 x 42. Do not scale contents of this drawing.

Sheet Number

**E412A**

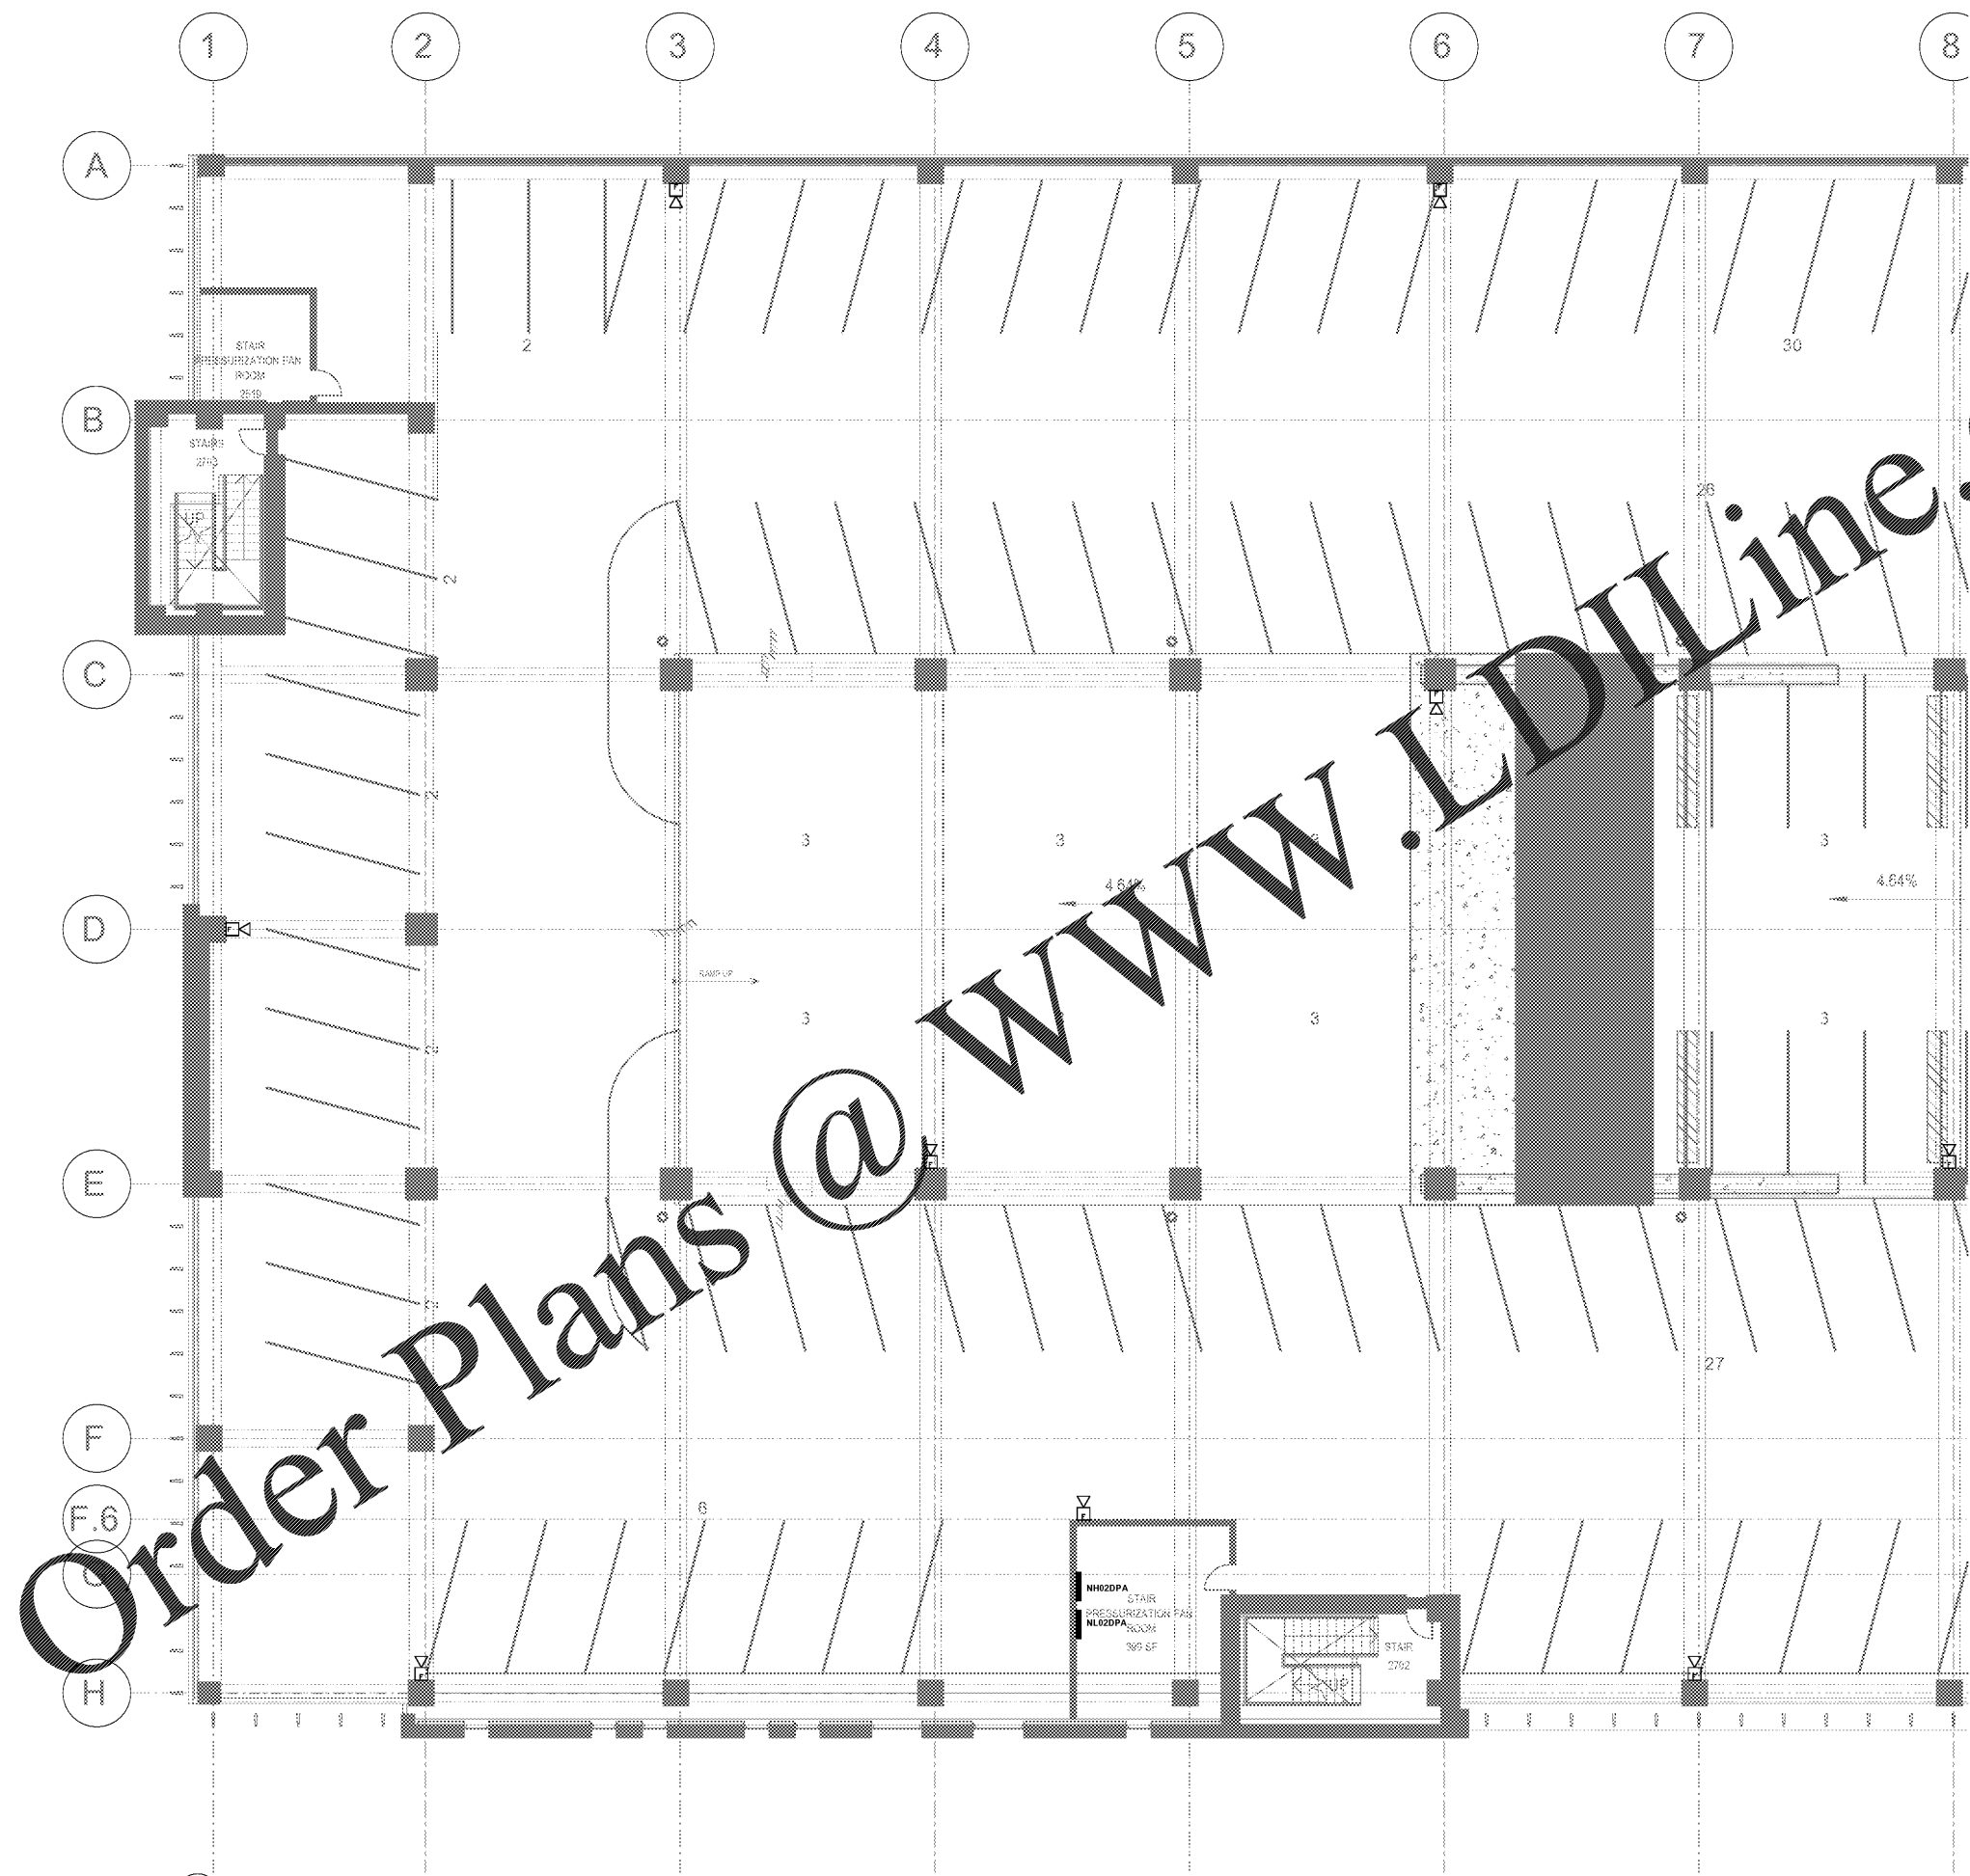

1 FLOOR PLAN - LEVEL 2 - WEST - FIRE ALARM  
1/8" = 1'-0"