


Order Plans @ [www.LDILine.com](http://www.LDILine.com)

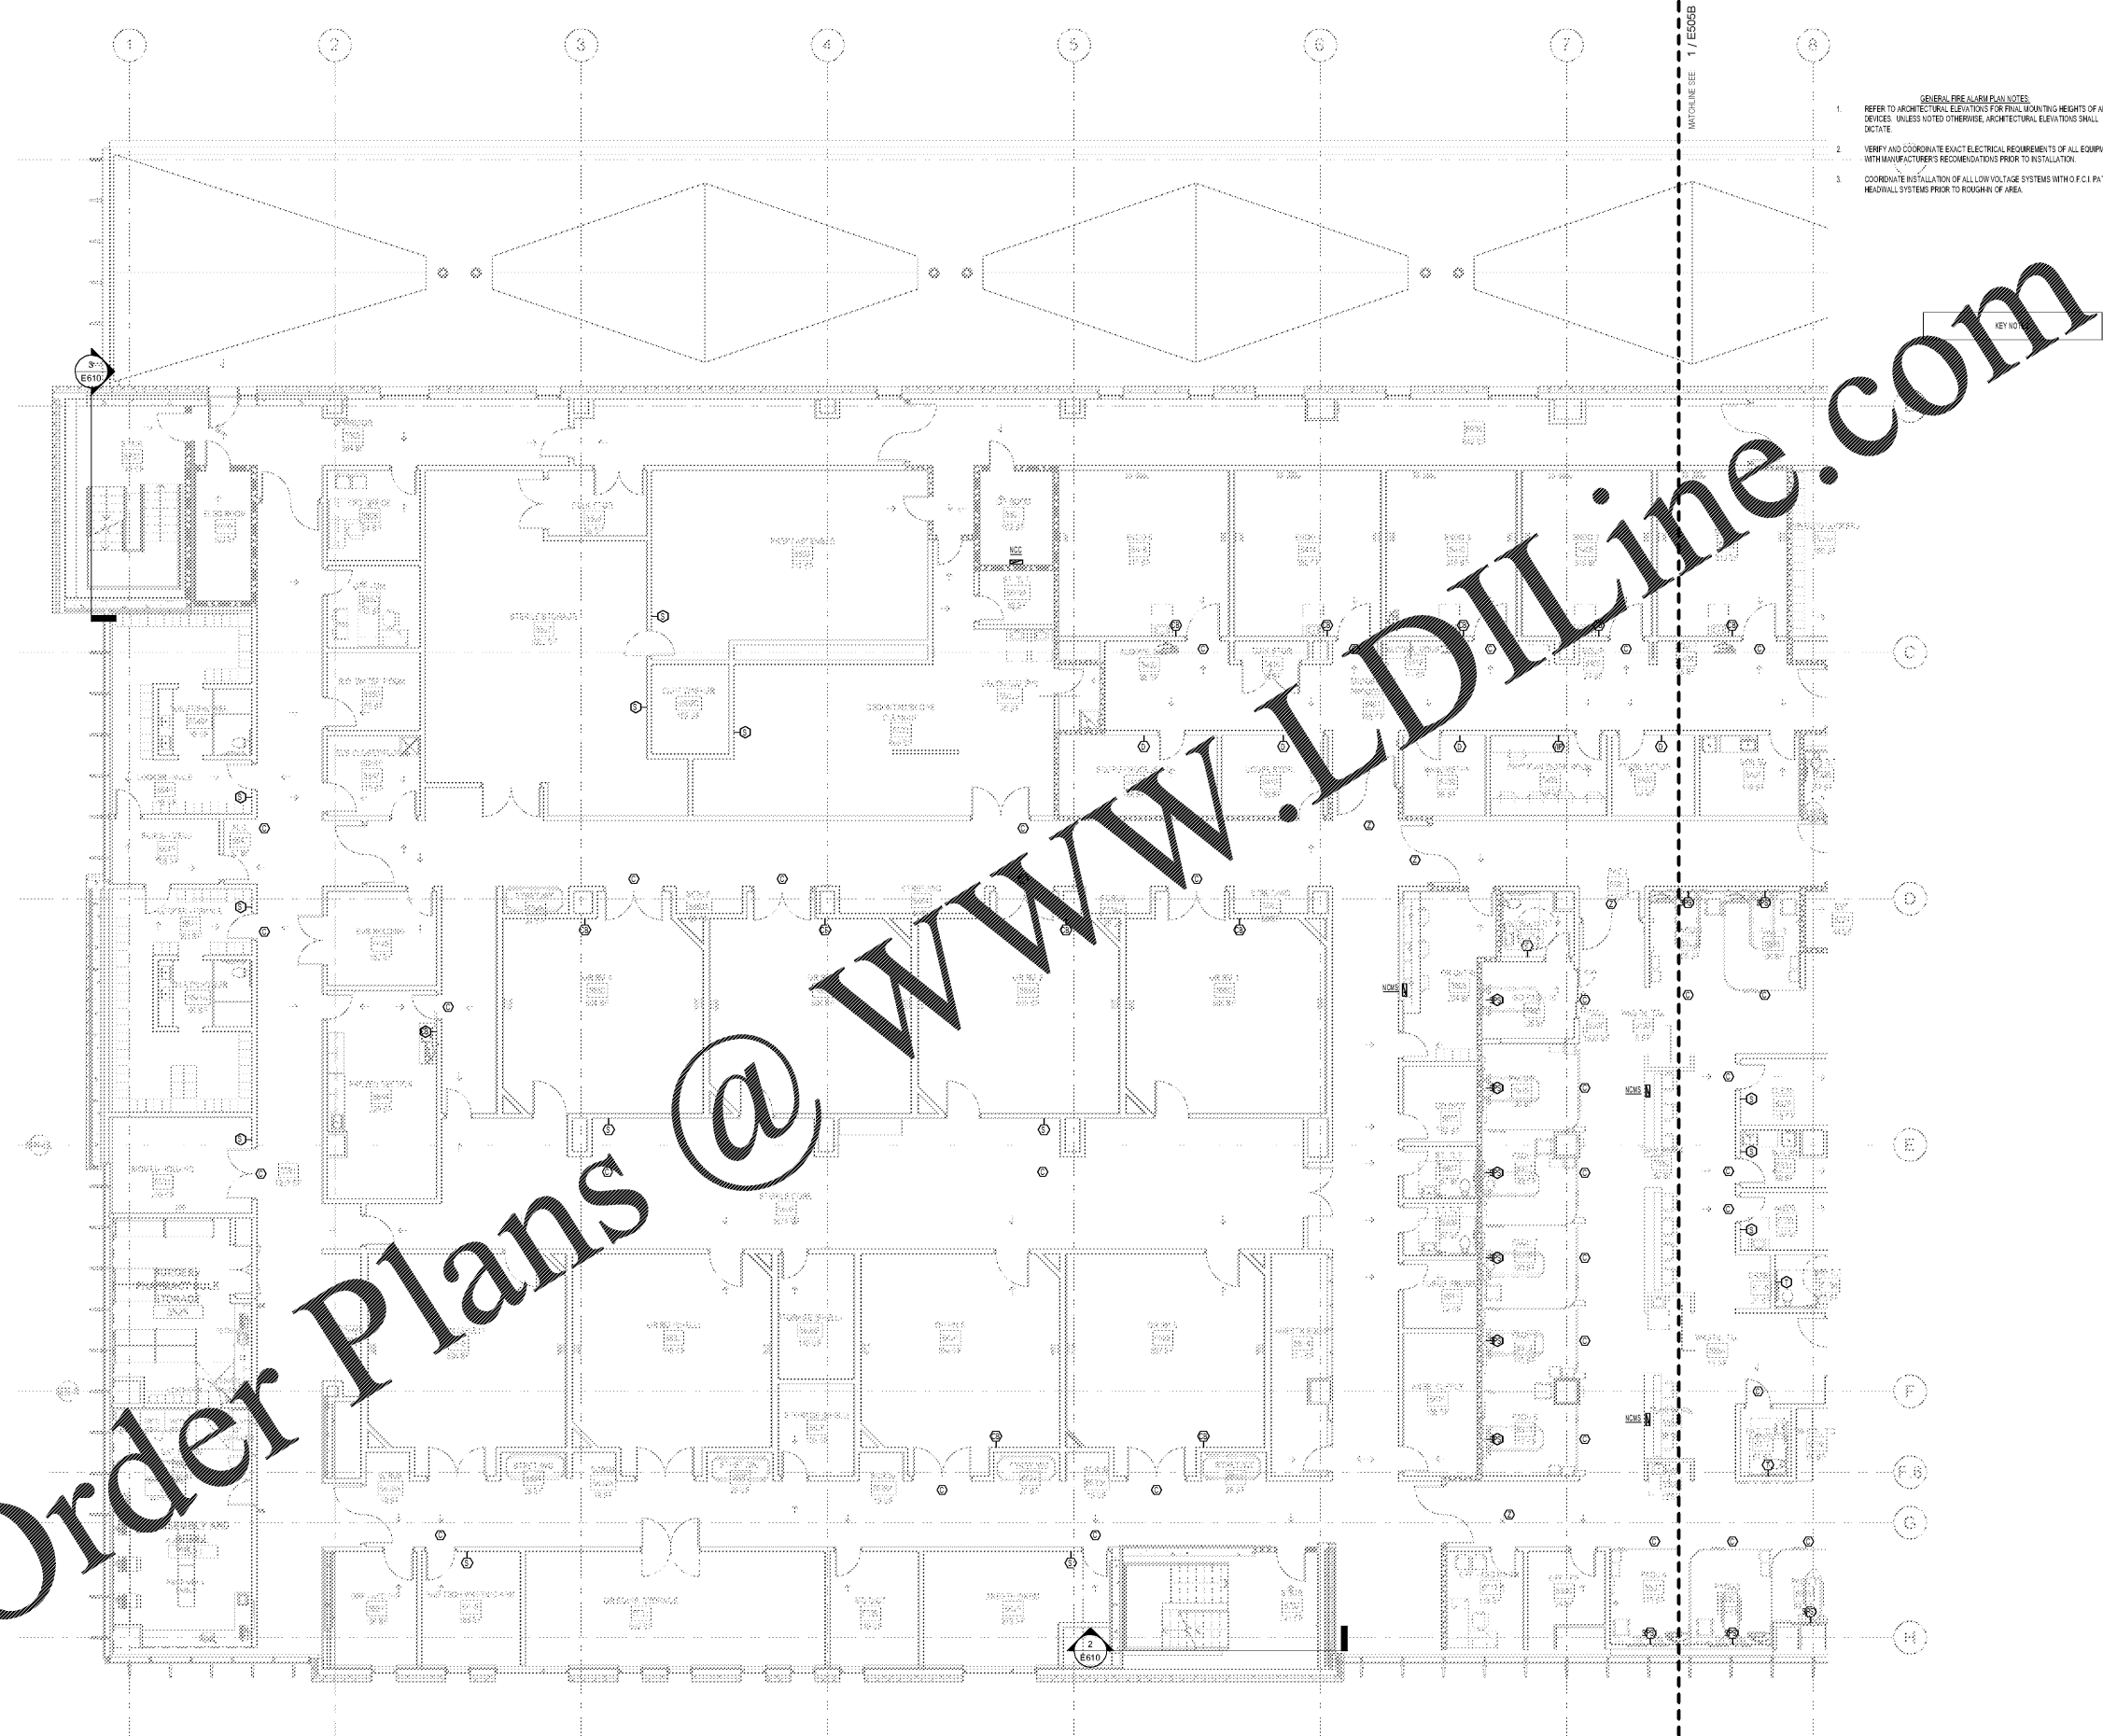

- GENERAL FIRE ALARM PLAN NOTES:
1. REFER TO ARCHITECTURAL ELEVATIONS FOR FINAL MOUNTING HEIGHTS OF ALL DEVICES. UNLESS NOTED OTHERWISE, ARCHITECTURAL ELEVATIONS SHALL Dictate.
  2. VERIFY AND COORDINATE EXACT ELECTRICAL REQUIREMENTS OF ALL EQUIPMENT WITH MANUFACTURER'S RECOMMENDATIONS PRIOR TO INSTALLATION.
  3. COORDINATE INSTALLATION OF ALL LOW VOLTAGE SYSTEMS WITH O.F.C.I. PATIENT MEDICAL SYSTEMS PRIOR TO ROUGH-IN OF AREA.



Project  
**THE CENTER FOR  
 ADVANCED SURGICAL  
 SERVICES (CASS)**  
 88 JESSE HILL DRIVE  
 ATLANTA, GA 30303


Prepared For  
**GRADY HEALTH SYSTEM**  
 80 JESSE HILL DR. SE  
 ATLANTA, GA 30303



Hellmuth, Obata & Kassabaum, Inc.  
 191 Peachtree Street, NE, Suite 2250  
 Atlanta, GA 30303 USA  
 T+1 404 439 9000 F+1 404 439 9001

All reproduction & intellectual property rights reserved © 2019  
 In Association with

**TLC ENGINEERING**  
 255 S. Orange Avenue  
 Suite 1400  
 Orlando, FL 32801  
 P 407.841.0050  
 CDA PEF 022860  
 www.tlc-engineering.com  
 TLC No. 118548  
 TYPING: L16720K, C265A19

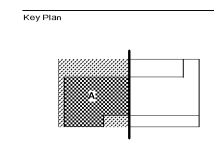

Professional Seal  
 Emory Neal Boothe, P.E.  
 Georgia License #PE039005

**NOT FOR  
 CONSTRUCTION**

No.	Description	Date
1	ED - GMP	2019-07-03

Project No: 18.16013.00  
 Sheet Title  
**LEVEL 5 FLOOR PLAN -  
 WEST - NURSE CALL**

Original is 20 x 42. Do not scale contents of this drawing.  
 Sheet Number

**E505A**

**1 FLOOR PLAN - LEVEL 5 - WEST - NURSE CALL**  
 1/8" = 1'-0"