 




Key Plan



Professional Seal  
 Emory Neal Boothe, P.E.  
 Georgia License #PE039005

**NOT FOR  
 CONSTRUCTION**


No.	Description	Date
3	DD - GMP	2019-07-03

Project No. 18-16013-00  
 Sheet Title

**TECHNOLOGY RISER  
 DIAGRAM - FIBER**

NEW GRADY CASS

EXISTING GRADY CAMPUS

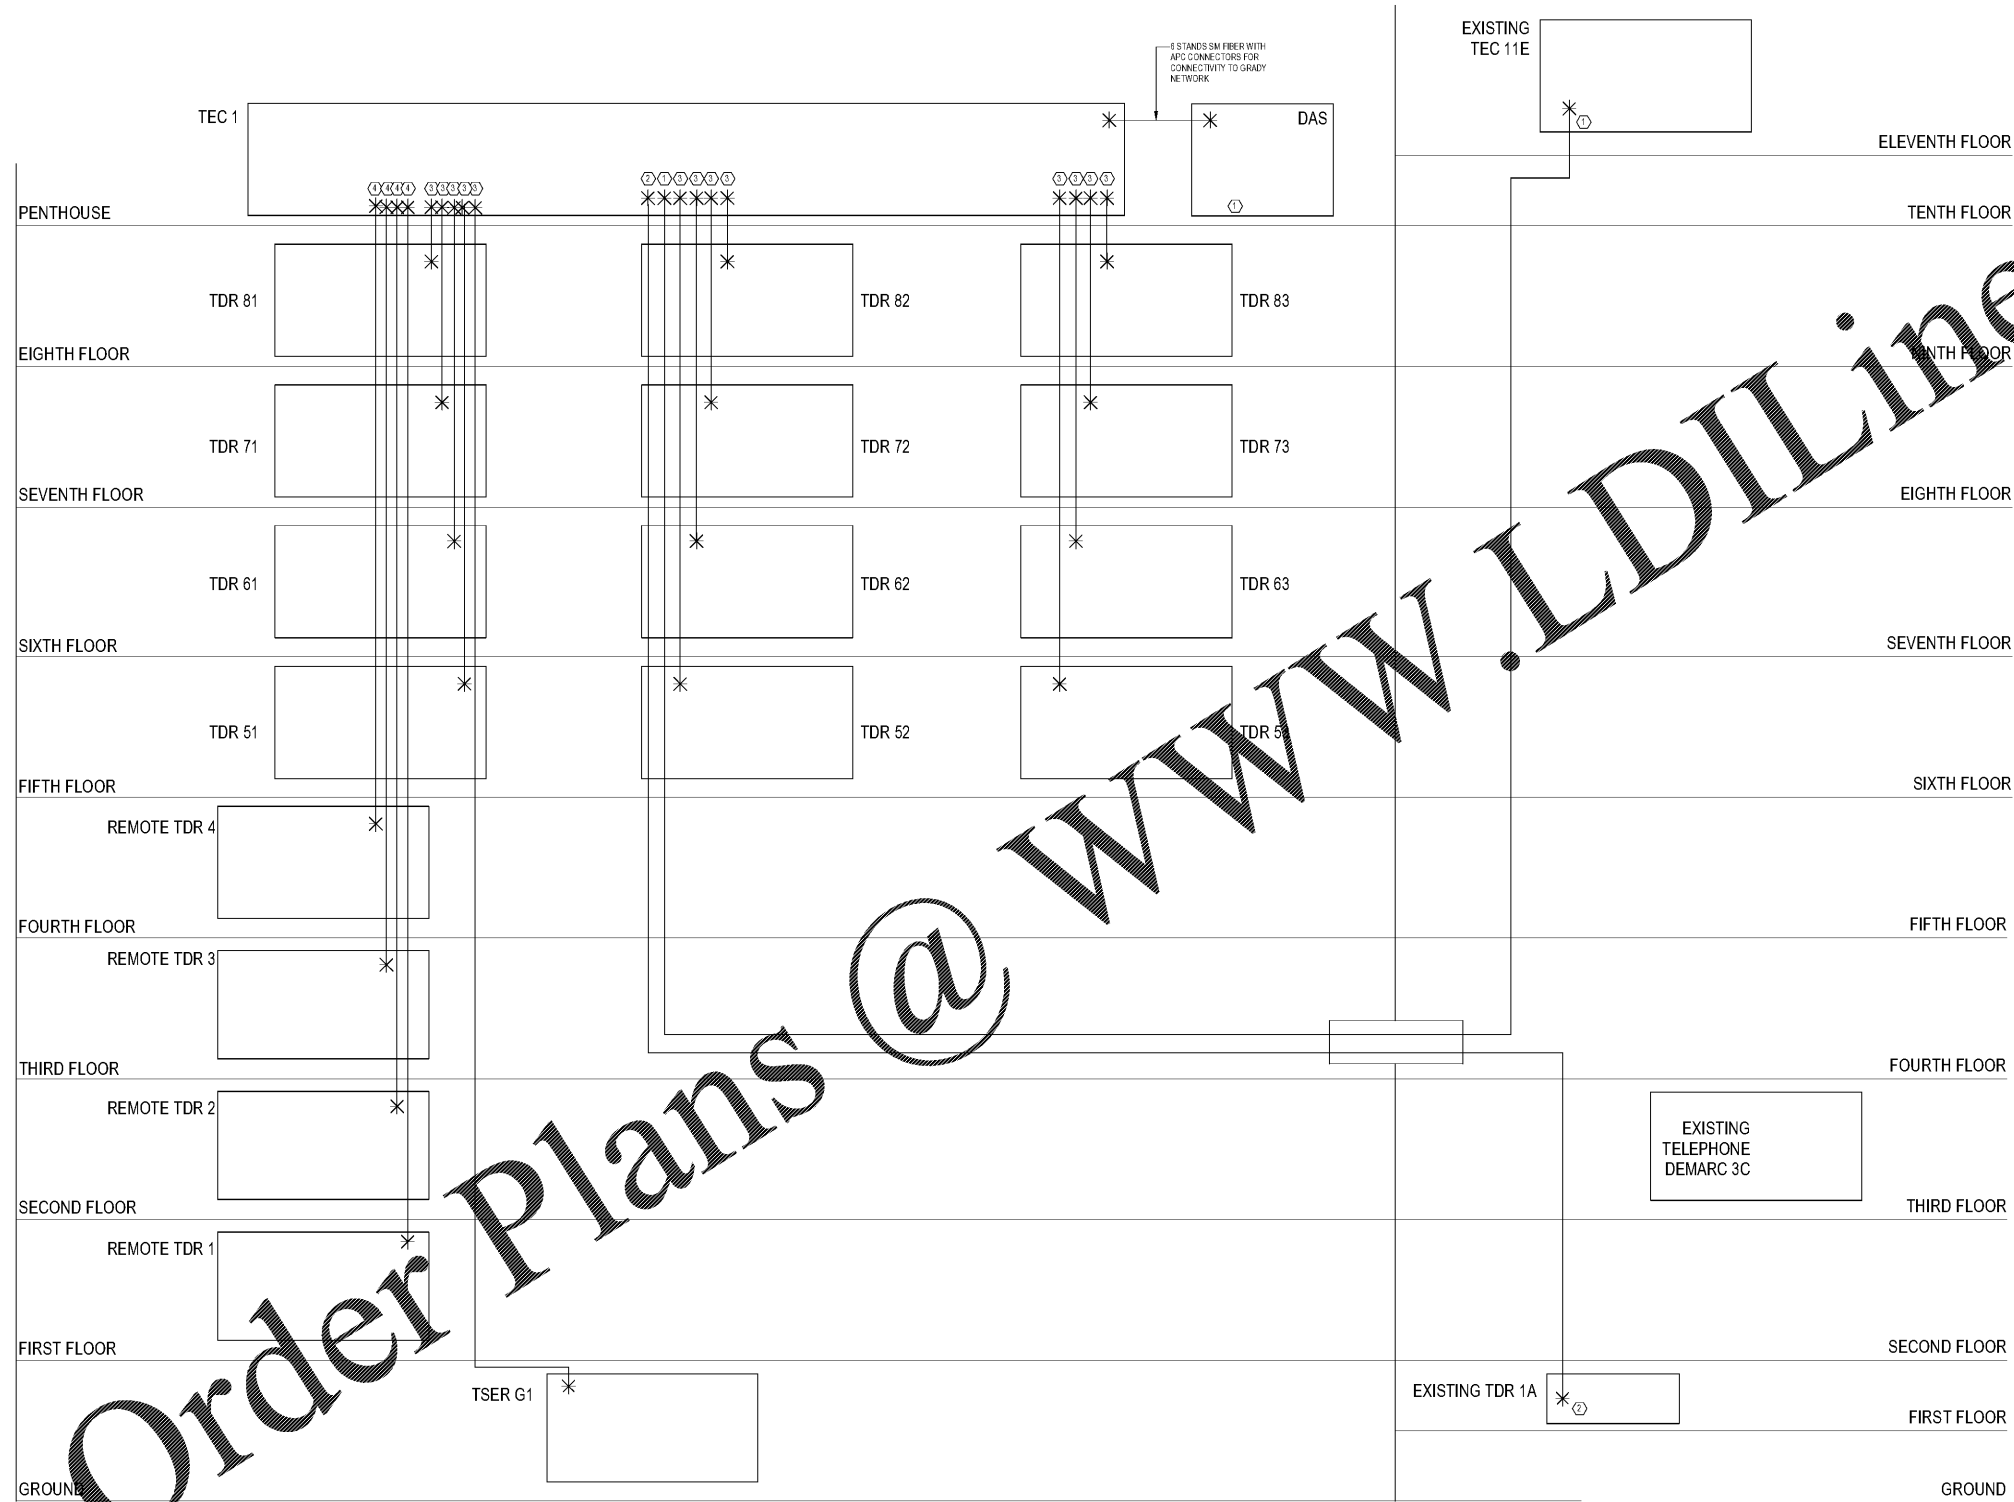

- FIBER PLAN KEYED NOTES:**
- ① PROVIDE 72 STRANDS, ARMORED, SINGLE MODE, INDOOR/OUTDOOR RISER RATED FIBER
  - ② PROVIDE 72 STRANDS, SINGLE MODE, ARMORED, INDOOR/OUTDOOR RISER RATED FIBER
  - ③ PROVIDE 24 STRANDS, RISER RATED, OM4 MULTIMODE FIBER WITH LC CONNECTORS
  - ④ PROVIDE 6 STRANDS RISER RATED, OM4 MULTI-MODE FIBER WITH LC CONNECTORS

**1 TELECOMMUNICATIONS FIBER RISER DIAGRAM**  
 1/2" = 1'-0"