


NEW GRADY CASS

EXISTING GRADY CAMPUS

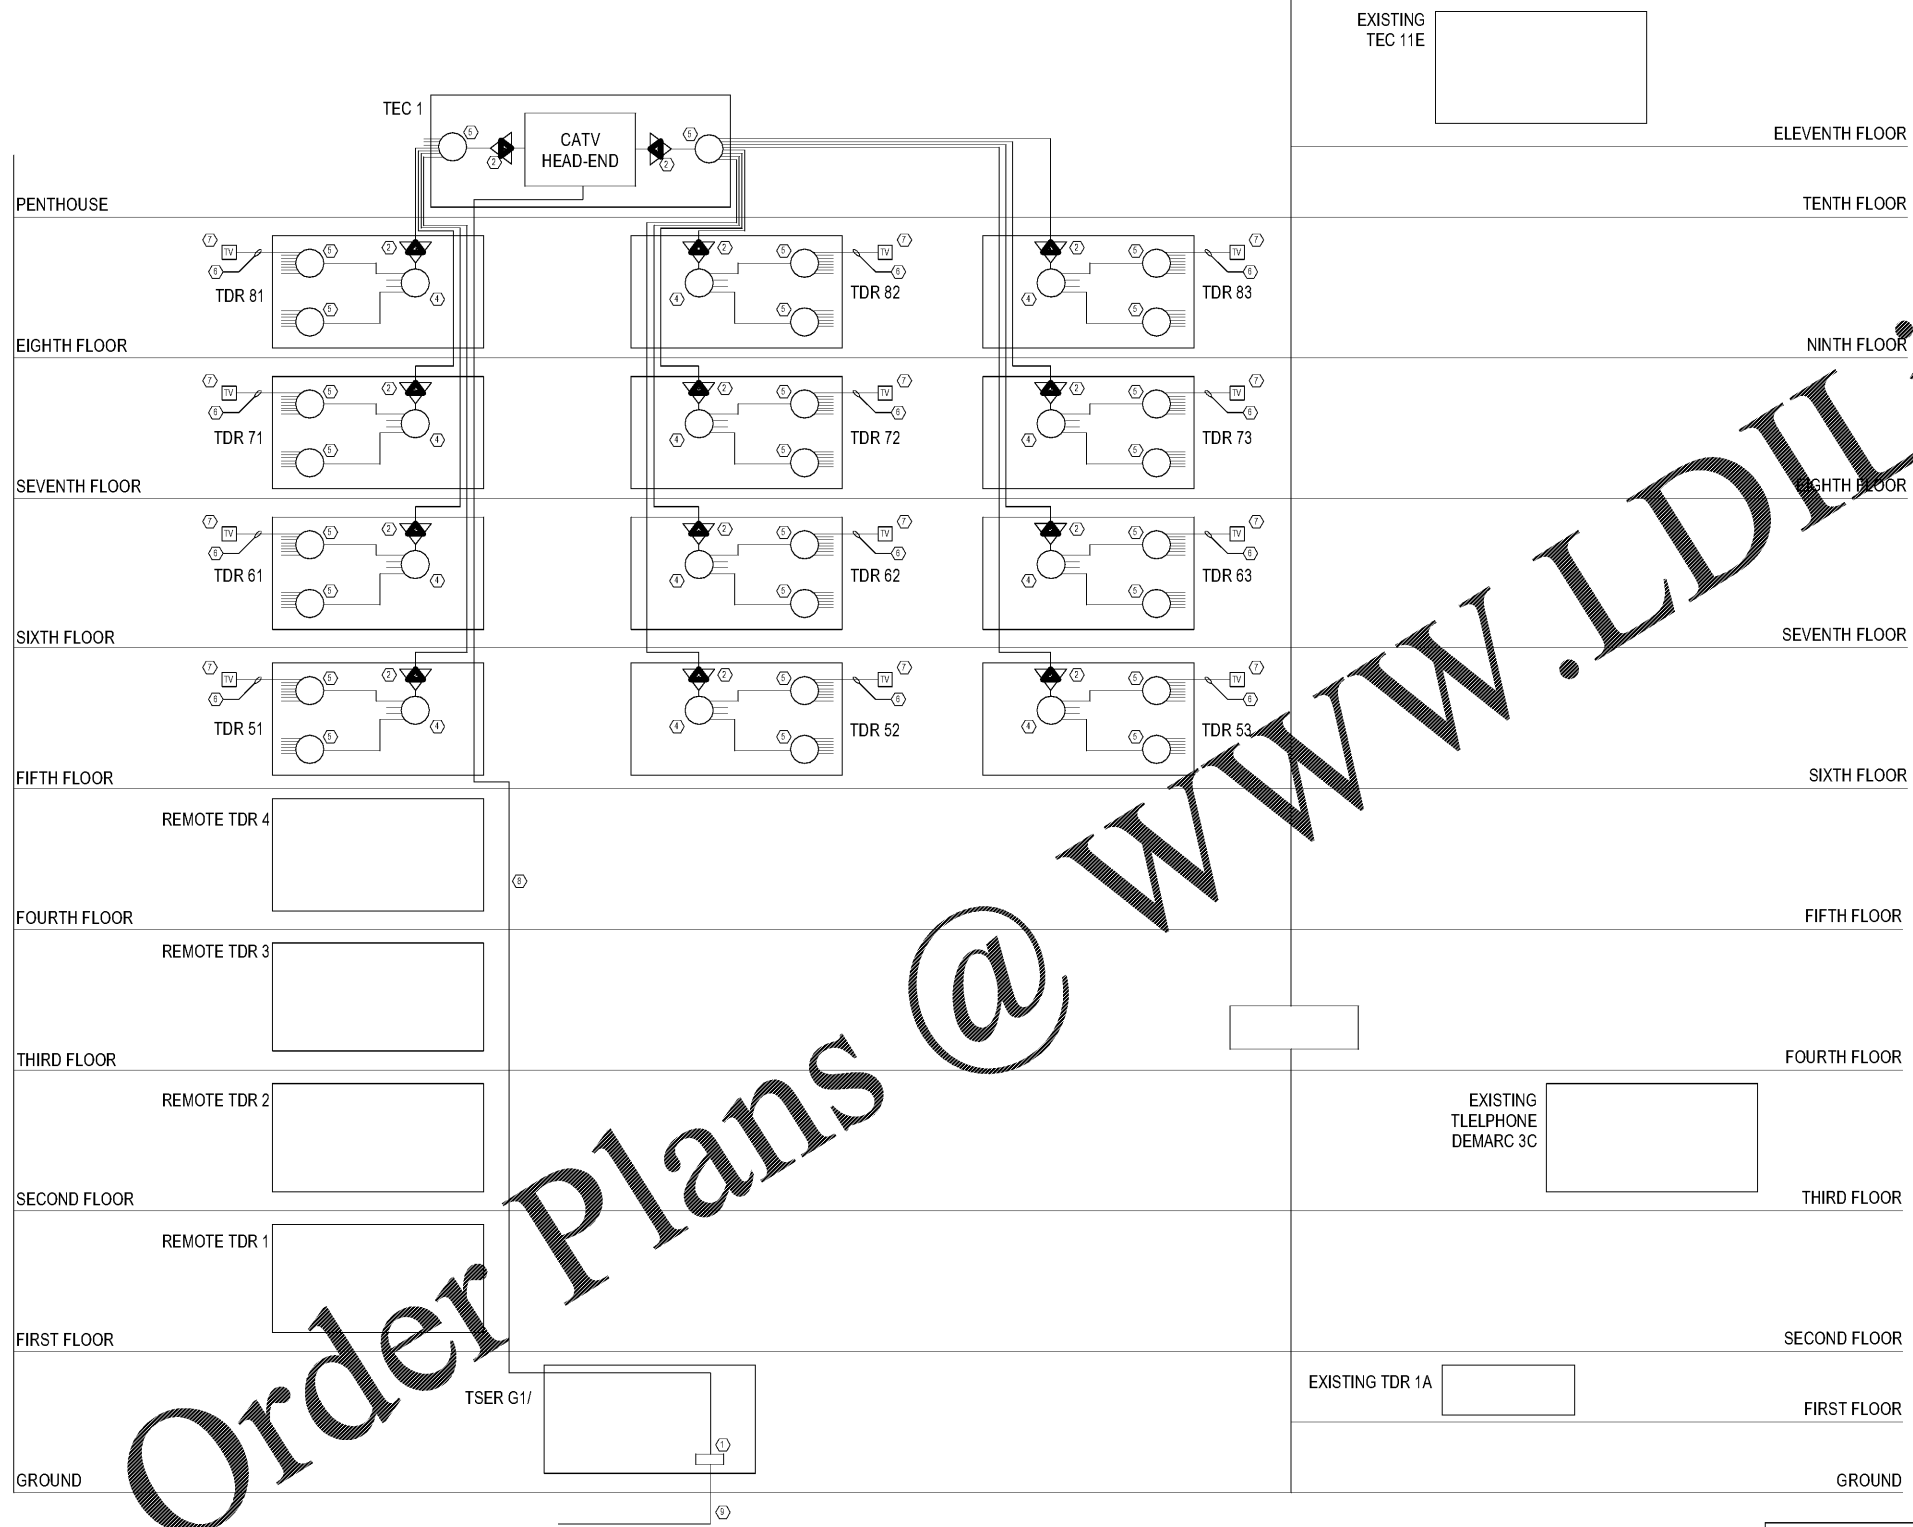

Project  
THE CENTER FOR  
ADVANCED SURGICAL  
SERVICES (CASS)  
88 JESSE HILL DRIVE  
ATLANTA, GA 30303

Prepared For  
**GRADY HEALTH SYSTEM**  
80 JESSE HILL DR. SE  
ATLANTA, GA 30303



Hellmuth, Obata & Kassabaum, Inc.  
191 Peachtree Street, NE, Suite 2250  
Atlanta, GA 30303 USA  
+1 404 439 9000 F+1 404 439 9001

All reproduction & intellectual property rights reserved © 2019.

In Association with



Key Plans



Professional Seal  
Emory Neal Boothe, P.E.  
Georgia License #PE039005

**NOT FOR  
CONSTRUCTION**

No.	Description	Date
3	DD - GMP	2/19/21/03

Project No. 18-16013-00  
Sheet Title

**TECHNOLOGY RISER  
DIAGRAM - CATV**

Original is 30 x 42. Do not scale contents of this drawing.  
Sheet Number

- CATV RISER KEYNOTES:**
- ① PROVIDE PRE-AMPLIFIER AT NEW SERVICE ENTRANCE.
  - ② PROVIDE AMPLIFIER AT DESIGNATED TELECOMMUNICATIONS ROOMS. DESIGN SELECTION: BLONDER TONGUE BIDA 85A-30 OR NEWEST MODEL.
  - ③ PROVIDE 75 OHM TERMINATION TAP AT DESIGNATED TELECOMMUNICATIONS ROOMS TO TERMINATE RG-11 RISER CABLE.
  - ④ PROVIDE 4-WAY SPLITTER, DESIGN SELECTION: BLONDER TONGUE SXRS-4.
  - ⑤ PROVIDE 3-WAY SPLITTER, DESIGN SELECTION: BLONDER TONGUE SXRS-3. PROVIDE SPLITTERS AS REQUIRED BY DEVICES ON THE FLOOR PLANS.
  - ⑥ PROVIDE GROUND SHIELD, RG-8 COAXIAL CABLE TO TV LOCATIONS AS SHOWN ON PLANS; DESIGN SELECTION: COMMSCOPE 5540. TERMINATE ALL UNUSED TAPS WITH 75 OHM TERMINATORS.
  - ⑦ REFER TO TELECOMMUNICATIONS SHEETS FOR LOCATIONS OF TV OUTLETS, CONDUIT/TRACEWAY/HOOK REQUIREMENTS, AND FOR DETAILS ON OUTLET FACEPLATE.
  - ⑧ PROVIDE A 1/2" 50OHM COAXIAL HARDLINE FROM THE SERVICE PROVIDER EQUIPMENT IN THE GROUND FLOOR ENTRANCE FACILITY TO THE PENTHOUSE MDF.
  - ⑨ PROVIDE 3/4" CONDUITS WITH PULLSTRING TO A NEW HOLE FOR NEW COMCAST CABLING.

**1 TELECOMMUNICATIONS CATV RISER DIAGRAM**  
1/2" = 1'-0"