

SEAL:


THIS DOCUMENT IS NOT  
 FOR REGULATORY  
 APPROVAL, PERMITTING,  
 OR CONSTRUCTION.

**GENERAL NOTES**

A. CO2 MONITORING SYSTEM PROVIDED BY 7-ELEVEN. CONTRACTOR TO COORDINATE INSTALLATION OF CO2 MONITORING SYSTEM WITH AUTHORIZED INSTALLER. REFERENCE EF1.1 SHEET FOR SPECIFICATIONS.

**KEY NOTES**

1. LOGIC02 MODEL MK10 SET 2A WITH CENTRAL UNIT.
2. CO2 ALERT WITH BUILT IN LAMP/ BUZZER/ 15FT POWER CABLE.
3. WARNING LAMP INCLUDING 15FT CABLE AND CONNECTOR.
4. POWER SUPPLY.
5. CO2 WARNING SIGN.
6. STAINLESS STEEL PROTECTION BAR.
7. EXTERIOR CO2 TANK.
8. BAG IN BOX RACKS
9. POST MIX
10. EXTERIOR NITROGEN TANK.

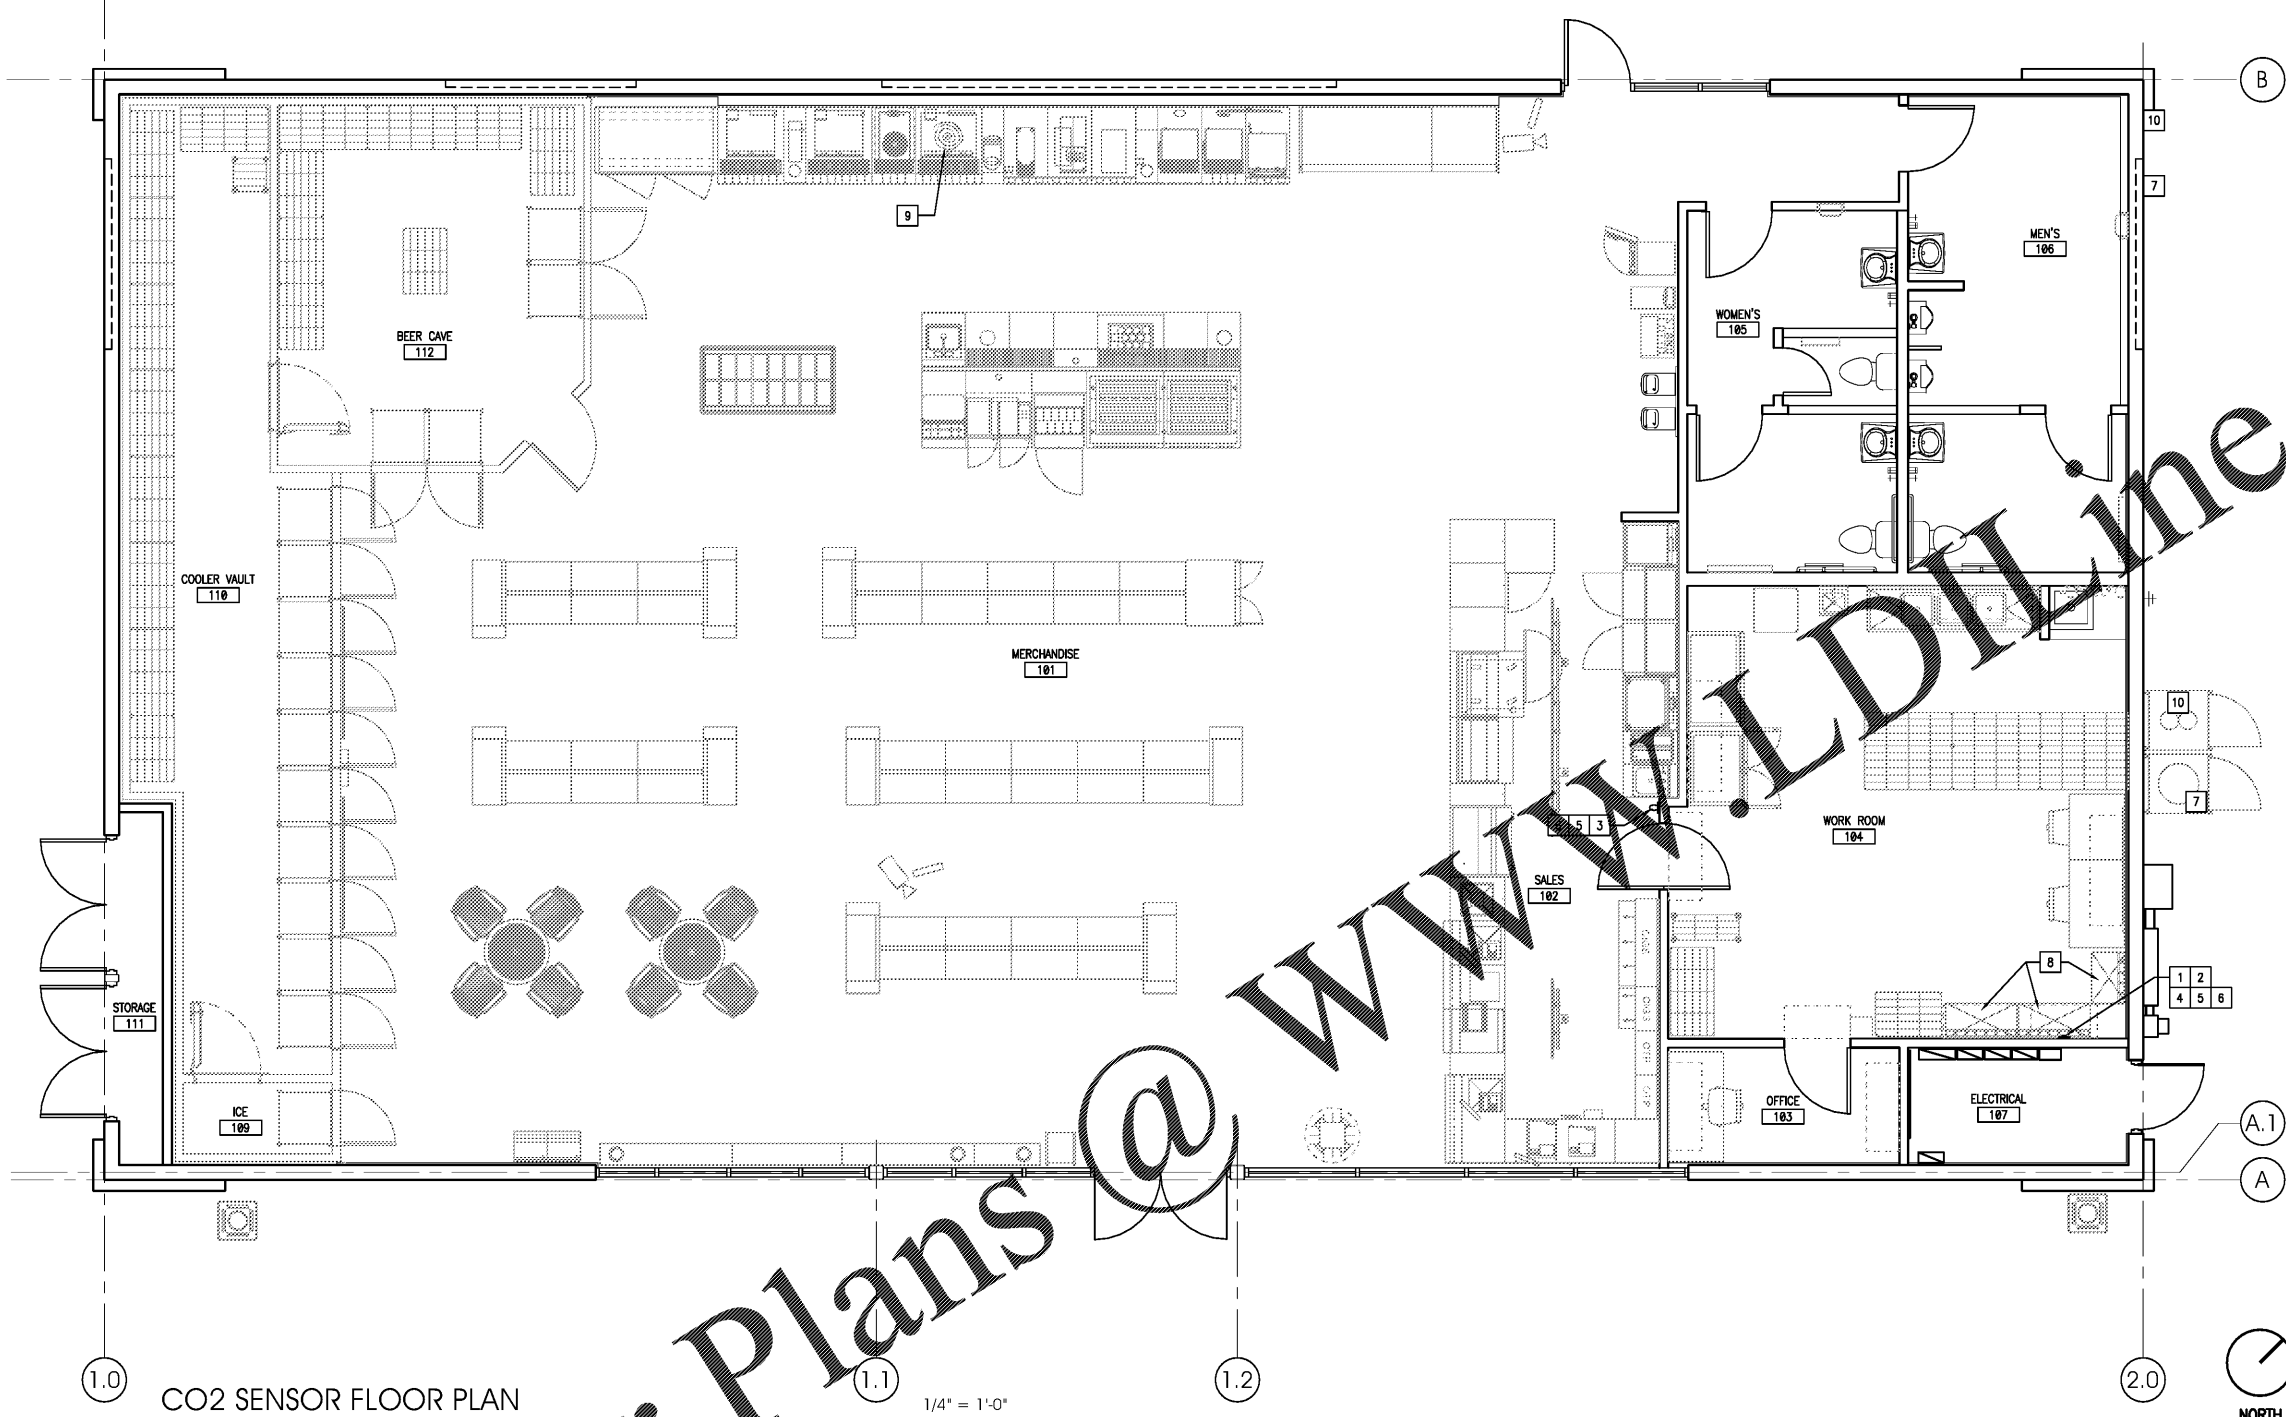

1.0 CO2 SENSOR FLOOR PLAN

1.1 1/4" = 1'-0"

1.2

2.0



NO. DATE REMARKS  
 REVISIONS



BID SET  
 JUNE 27, 2019

**7-ELEVEN**  
**STORE #38777**

12060 US 301 N  
 PARRISH, FL  
 34219

PROJECT NO: 2018.0891  
 DATE: FEBRUARY 26, 2019

**A0.4**

CO2 SENSOR FLOOR PLAN

CHECKED: RW DRAWN: JUM

COPYRIGHT © 2019 INTERPLAN LLC. REPRODUCE, COPY, OR TRANSMIT IN ANY FORM OR BY ANY MEANS WITHOUT PERMISSION IN WRITING IS STRICTLY PROHIBITED. ALL RIGHTS RESERVED. REPRODUCTIONS, CHANGES OR ASSIGNMENTS ARE PROHIBITED.