


SEAL:

THIS DOCUMENT IS NOT  
FOR REGULATORY  
APPROVAL, PERMITTING,  
OR CONSTRUCTION.

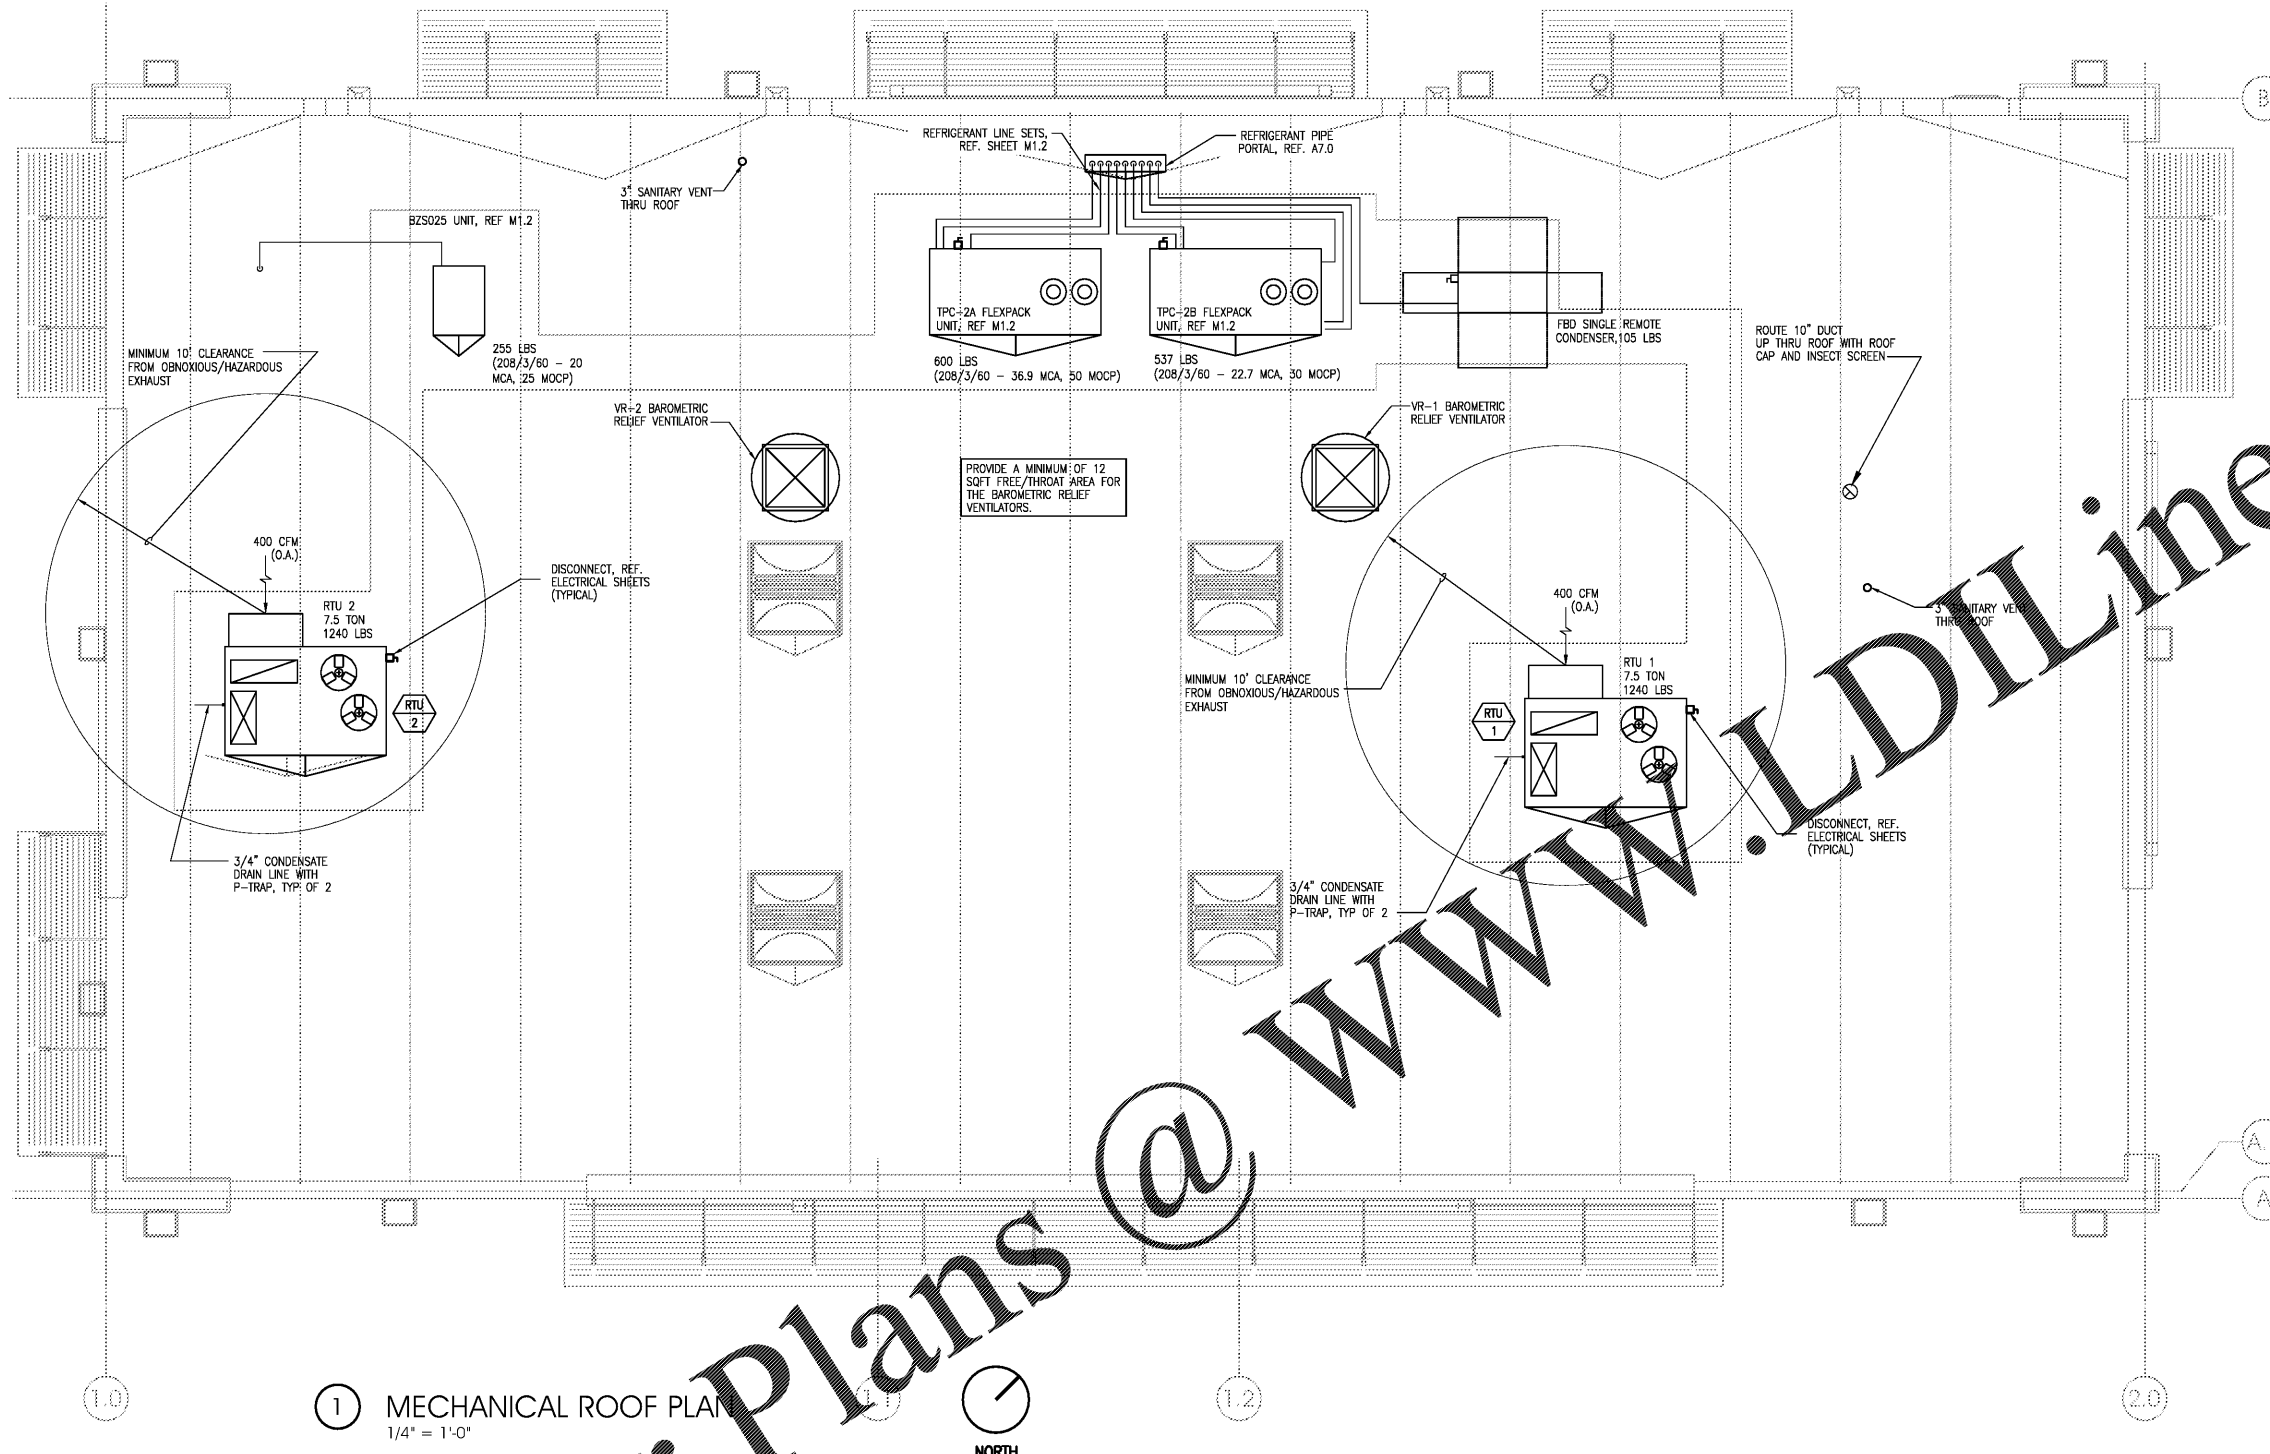

1 MECHANICAL ROOF PLAN  
1/4" = 1'-0"



Order Plans @ WWW.LDILine.com

NO.	DATE	REMARKS



BID SET  
JUNE 27, 2019

7-ELEVEN  
STORE #38777

12060 US 301 N  
PARRISH, FL  
34219

PROJECT NO: 2018.0891  
DATE: FEBRUARY 26, 2019

M1.1  
MECHANICAL ROOF PLAN

CHECKED: MM DRAWN: AE

COPYRIGHT © 2019 INTERPLAN LLC. RESERVE COPYRIGHT & OTHER RIGHTS RESTRICTING THESE DOCUMENTS TO THE ORIGINAL USE OR TYPING FOR WHICH THEY WERE PREPARED. REPRODUCTIONS, CHANGES OR ASSIGNMENTS ARE PROHIBITED.