

SEAL:

THIS DOCUMENT IS NOT
FOR REGULATORY
APPROVAL, PERMITTING,
OR CONSTRUCTION.

NO. DATE REMARKS
REVISIONS



BID SET
JUNE 27, 2019


7-ELEVEN
STORE #38777

12060 US 301 N
PARRISH, FL
34219

PROJECT NO: 2018.0891
DATE: FEBRUARY 26, 2019

P1.1
PLUMBING WATER PLAN

CHECKED: MM DRAWN: LE

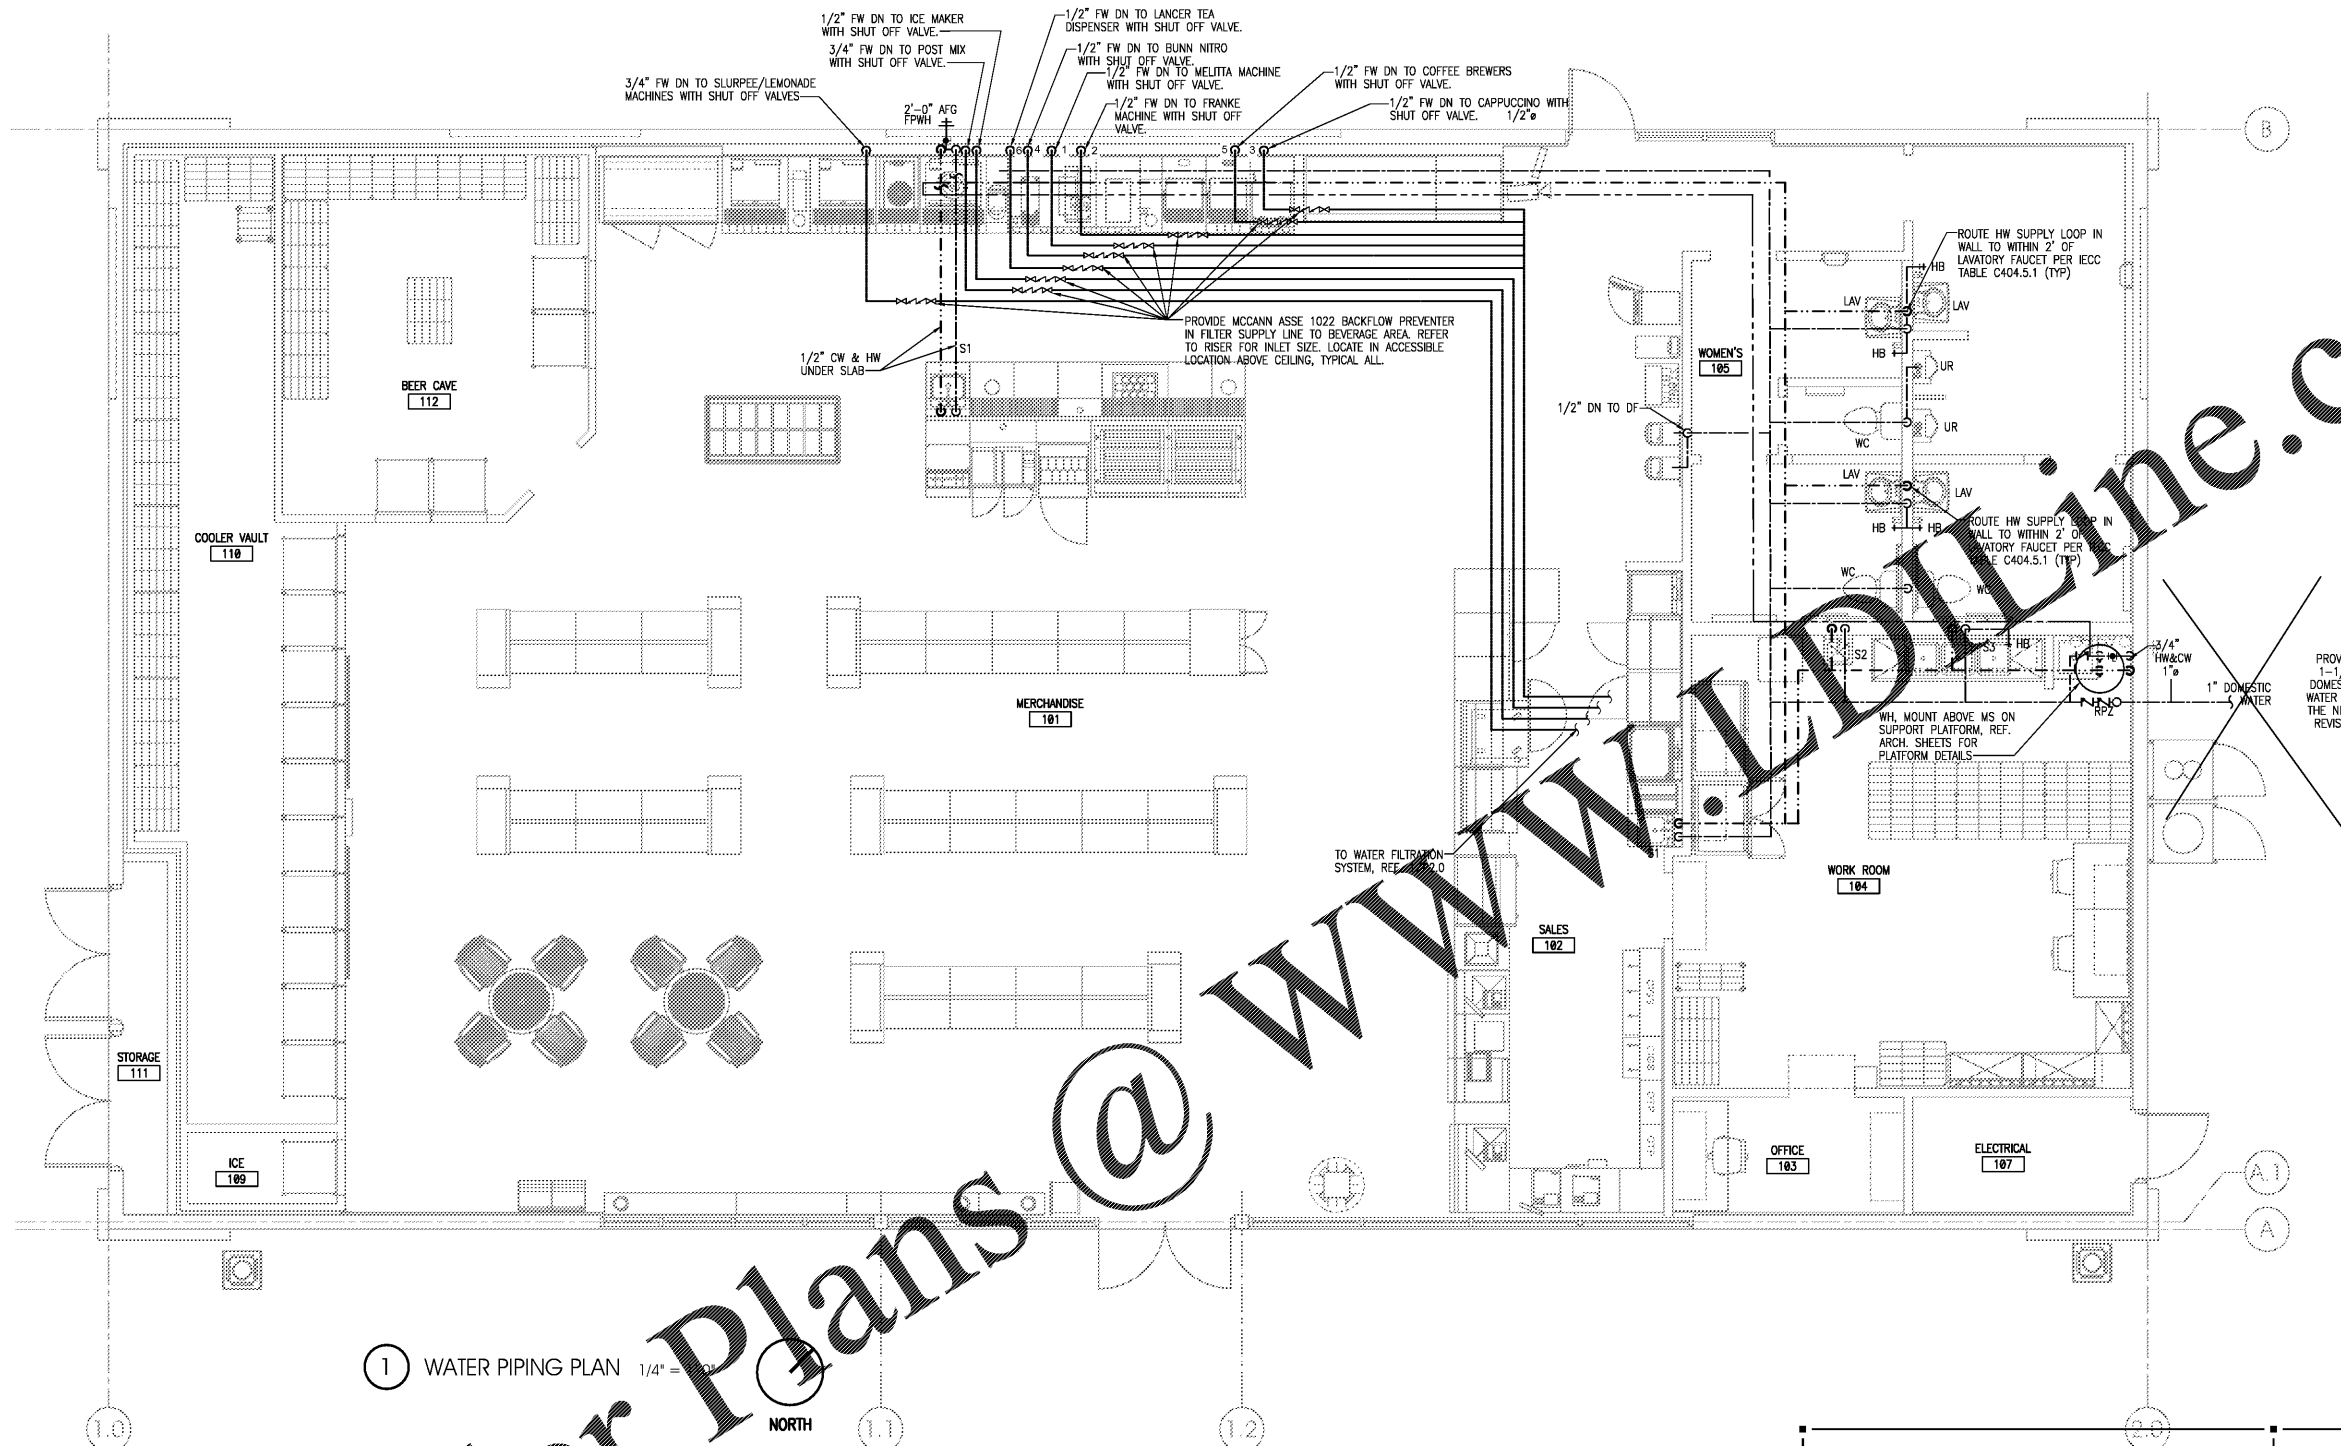

1 WATER PIPING PLAN 1/4" = 1'-0"

Order Plans @ www.worldline.com

PUMP SCHEDULE					
MARK	MANUFACTURER	MODEL	HEAD (FT)	V/PH	NOTES
P1	BELL & GOSSETT	NBF-9U/LW	11 @ 5 GPM	120/1	A-D

NOTES:
A. LEAD FREE CONSTRUCTION.
B. PROVIDE WITH FLEXIBLE PLUG-IN CORD.
C. INSTALL PER MANUFACTURER'S RECOMMENDATIONS.
D. PROVIDE WITH FLOW AND TEMPERATURE SENSORS FOR ON-DEMAND CIRCULATION CONTROLS PER 2015 IECC C404.7, REF 2/P2.0

WATER HEATER SCHEDULE						
MARK	MANUF.	MODEL	TANK SIZE	KW	V/PH	NOTES
WH	RHEEM	ELD52	47	9	208/3	A, B, C

GENERAL INFORMATION (ALL UNITS):
1. 120 DEG. F OUTLET TEMPERATURE.
NOTES:
A. PROVIDE AMTROL (OR EQUAL) EXPANSION TANK AND DRAIN PAN SIZED PER MANUFACTURER'S RECOMMENDATIONS.
B. MOUNT WATER HEATER ON SUPPORT PLATFORM, REF. 2/P2.0.
C. WIRED FOR SIMULTANEOUS OPERATION.

BACKFLOW PREVENTER SCHEDULE	
EQUIPMENTS	BACKFLOW PREVENTER MODEL NUMBER
ICE MACHINE	ASSE 1022
SODA MACHINE	ASSE 1022
CAPPUCCINO MACHINE	ASSE 1022
SLURPEE MACHINE	ASSE 1022

COPYRIGHT © 2019 INTERPLAN LLC. RESERVE COPYRIGHT & OTHER RIGHTS RESTRICTING THESE DOCUMENTS TO THE ORIGINAL SET OR TYPED COPY WHICH THEY WERE PREPARED. REPRODUCTIONS, CHANGES OR ASSIGNMENTS ARE PROHIBITED.