

SEAL:

**THIS DOCUMENT IS NOT  
FOR REGULATORY  
APPROVAL, PERMITTING,  
OR CONSTRUCTION.**

**GENERAL NOTES:**


- A LOCAL ENGINEER MUST APPROVE ALL CONSTRUCTION DRAWINGS TO VERIFY THEY MEET LOCAL, STATE AND NATIONAL CODES.
- ALL ELECTRICAL FITTINGS TO BE WATERTIGHT. ANY FIXTURES IN VICINITY OF WASH UNIT TO BE WATER TIGHT INCLUDING LIGHTS.
- DRILL A 1/4" DIAMETER DRAIN HOLE IN THE BOTTOM OF ALL JUNCTION BOXES THAT ARE LOCATED IN THE WASH BAY.
- ALL MATERIALS TO BE PROVIDED AND INSTALLED BY CUSTOMER UNLESS OTHERWISE SPECIFIED.
- CONSULT YOUR LOCAL RYKO REPRESENTATIVE FOR DIMENSIONS OTHER THAN SHOWN.
- TERMINATE ALL PIPES WITH FEMALE PIPE THREADS UNLESS OTHERWISE NOTED.
- ALL DIMENSIONS TO BE CLEAR SPACE DIMENSIONS.
- DO NOT USE WIRE LARGER OR SMALLER THAN THOSE SPECIFIED.
- ALL WIRES #16 AWG AND SMALLER ARE TO BE TFFN STRANDED.
- ALL WIRES #14 AWG AND LARGER ARE TO BE THHN STRANDED.
- NO CONDUITS MAY ENTER THE TOP OF ANY ENCLOSURE.
- BUILDING DETAILS ARE FOR ILLUSTRATION, AND ARE NOT INTENDED FOR CONSTRUCTION, PURCHASER SHOULD CONSULT WITH A PROPERLY CERTIFIED ENGINEER, CONTRACTOR, OR ARCHITECT WITH RESPECT TO COMPLIANCE WITH LOCAL SAFETY AND BUILDING CODES, FOR NECESSARY PERMITS AND LICENSES, AND FOR APPROPRIATE CONNECTIONS OF ALL UTILITIES.

EXHAUST FAN SCHEDULE								
MARK	MANUFACTURER	MODEL	CFM	E.S.P. (IN. WC)	RPM	MOTOR HP	V/Ph	CONTROL
EF-1	GREENHECK	SET-14-438-A3	2585	0.125"	1750	1/3	120/1	T-STAT

- NOTES:  
 A. PROVIDE INTEGRAL GRAVITY BACKDRAFT DAMPER, MODEL WD-320, AND DAMPER GUARD.  
 B. PROVIDE WALL HOUSING AND GUARD.  
 C. PROVIDE FACTORY MOUNTED DISCONNECT.  
 D. PROVIDE INSECT SCREEN.  
 E. PROVIDE HONEYWELL MODEL T8169B4017/U THERMOSTAT, SET AT 80°F.  
 F. COORDINATE WALL OPENING WITH ARCHITECTURAL AND STRUCTURAL.  
 G. INSTALL PER MANUFACTURER'S RECOMMENDATIONS.  
 H. TO BE PROVIDED BY 7-ELEVEN AND INSTALLED BY CONTRACTOR. FOR ADDITIONAL INFORMATION CONTACT CHAD LITERSKY (214) 350-6871 EXT. 2140 WITH BARTOS INDUSTRIES.

LOUVER SCHEDULE					
MARK	MANUFACTURER	MODEL	SIZE	NET FREE AREA (SQ.FT.)	DESCRIPTION
LV-1	GREENHECK	ESJ-401	42 X 24	3.18	ALUMINUM STATIONARY FIXED BLADE LOUVER NON-DRAINABLE WITH INSECT SCREEN

- NOTES:  
 A. COORDINATE WALL OPENING WITH ARCHITECTURAL AND STRUCTURAL.  
 B. INSTALL PER MANUFACTURER'S RECOMMENDATIONS.  
 C. TO BE PROVIDED BY 7-ELEVEN AND INSTALLED BY CONTRACTOR. FOR ADDITIONAL INFORMATION CONTACT CHAD LITERSKY (214) 350-6871 EXT. 2140 WITH BARTOS INDUSTRIES.

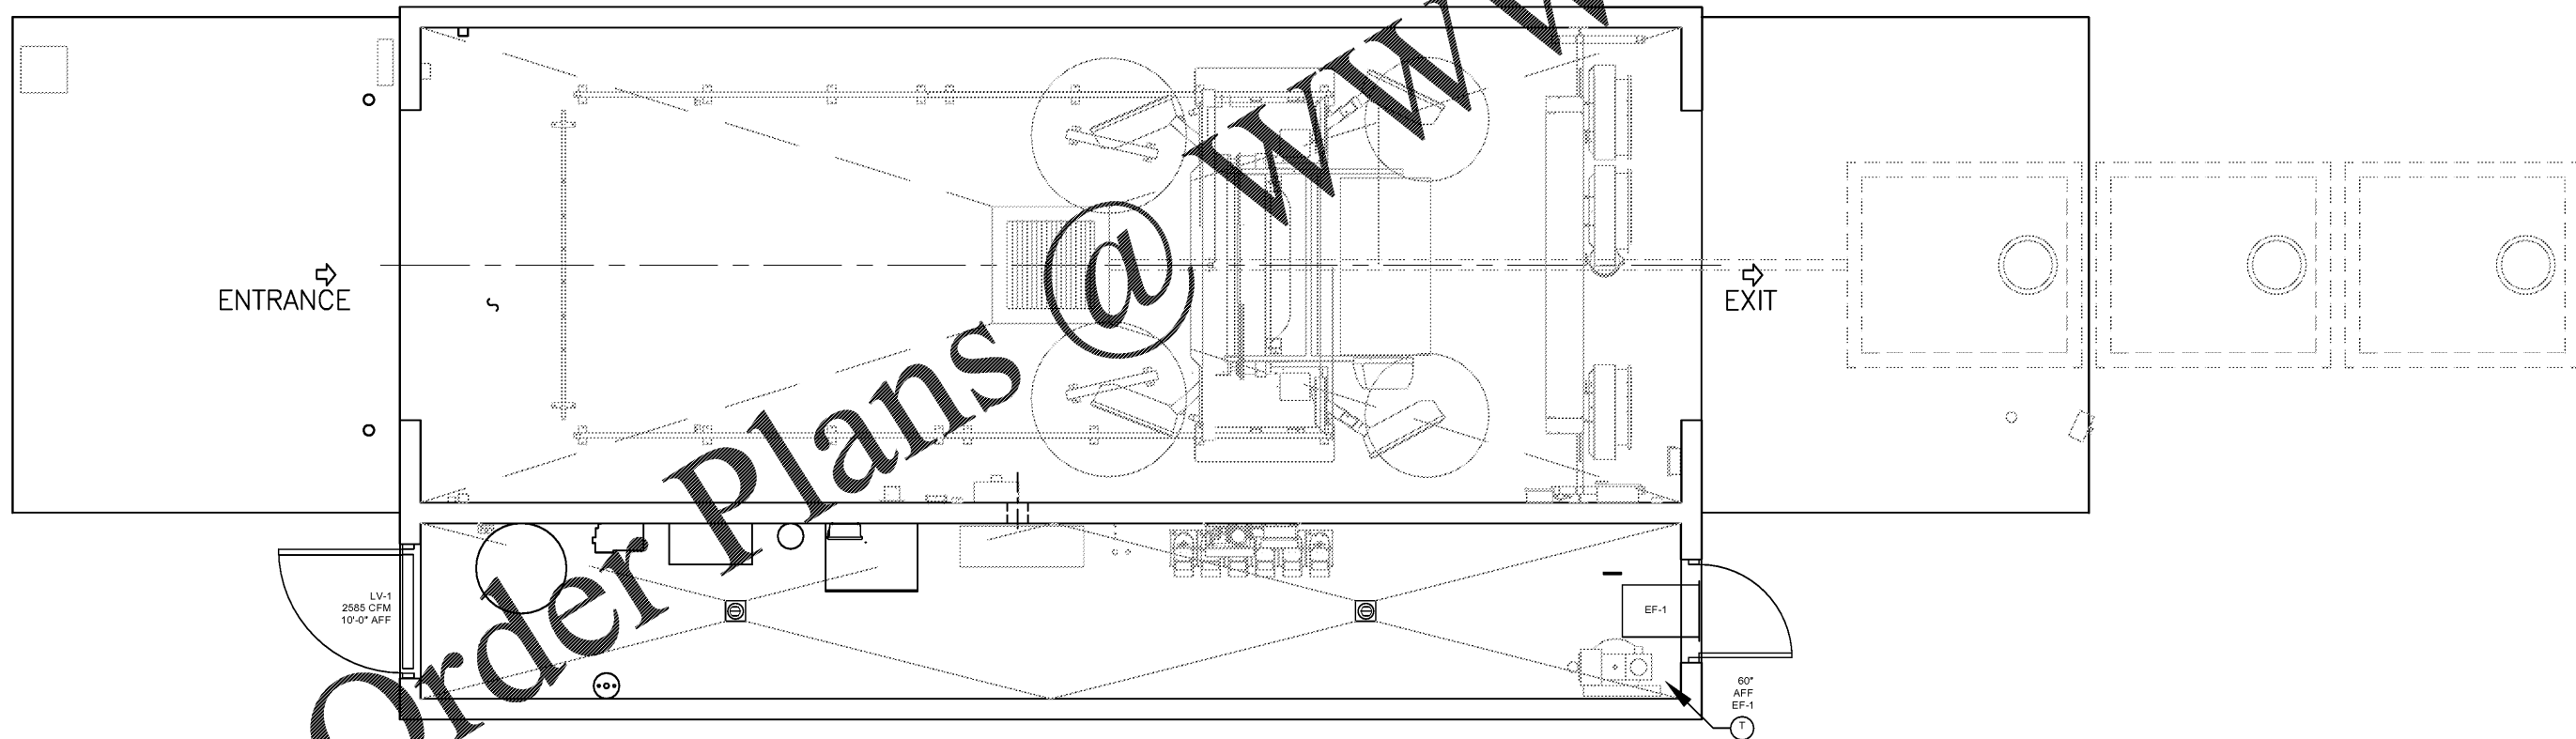

**1 MECHANICAL SYSTEMS**  
SCALE: 3/8"=1'-0"

NO.	DATE	REMARKS
REVISIONS		



BID SET  
JUNE 27, 2019

**7-ELEVEN  
STORE #38777**

12060 US 301 N  
PARRISH, FL  
34219

PROJECT NO: 2018.0891  
DATE: FEBRUARY 26, 2019

**CWM1.0**  
CAR WASH MECHANICAL  
SYSTEM

CHECKED: MM DRAWN: LE

COPYRIGHT © 2019 INTERPLAN LLC. RESERVE COPYRIGHT & OTHER RIGHTS RESTRICTING THESE DOCUMENTS TO THE ORIGINAL USE OR PURPOSE FOR WHICH THEY WERE PREPARED. REPRODUCTIONS, CHANGES OR ASSIGNMENTS ARE PROHIBITED.