

SEAL:

THIS DOCUMENT IS NOT
FOR REGULATORY
APPROVAL, PERMITTING,
OR CONSTRUCTION.

1 03.18.19 PEER COMMENTS
NO. DATE REMARKS

REVISIONS



BID SET
JUNE 27, 2019

7-ELEVEN
STORE #38777

12060 US 301 N
PARRISH, FL
34219

PROJECT NO: 2018.0891
DATE: FEBRUARY 26, 2019

CWE2.0
CAR WASH LIGHTING PLAN

CHECKED: BKJ DRAWN: MM


GENERAL NOTES

LIGHTING FIXTURE PACKAGE
UNLESS OTHERWISE NOTED 7-ELEVEN SHALL PROVIDE THE INTERIOR AND EXTERIOR LIGHTING FIXTURE PACKAGE- FURNISHED BY GRAYBAR (INSTALLED BY G.C.)

LIGHT SWITCHES
ALL OCCUPANCY SENSING SWITCHES ARE TO BE MULTI-TECHNOLOGY WALL SWITCH SENSOR, 1200 SQ. FT. MAJOR MOTION COVERAGE, 400 SQ. FT. MINOR MOTION COVERAGE. 800WB120V INC, 1200VA@120V FL, 2700VA@277V FL, 1/4HP@120V MOTOR, COMMERCIAL GRADE - WHITE CALIFORNIA TITLE 24 COMPLIANT. ALL TO BE PROVIDED BY GRAYBAR AND INSTALLED BY G.C.
WIRE EMERGENCY AND EXIT LIGHT FIXTURE AHEAD OF CONTROL.


LIGHTING FIXTURE SCHEDULE

TYPE	MANUFACTURER	CATALOG NUMBER	VOLTS/PHASE	WATTS	LAMPS		MOUNTING	DESCRIPTION	QTY
					TYPE	QTY			
C1	PHILLIPS	SN-2-48IN/WSS-TLEDW	120/1	36	#21875-1918/END/48-4000-UNV (LED)	2	SURFACE	SURFACE MOUNTED STRIP FIXTURE WITH PHILIPS LED LAMPS	4
G	BETA LED	SEC-EDG-3M-WM-06-D-UL-BZ-525	120/1	102	LED	1	WALL	EXTERIOR LED WALL LIGHT	10
T	CREE	PKG-304-PS-DM-04-D-UL-WH-525	120/1	66	LED	1	WALL	INTERIOR (WASH BAY) LED WALL LIGHT	4
X1	PHILLIPS	E611W	120/1	11	LED	2	UNIVERSAL	EMERGENCY FIXTURE W/ 90 MINUTE BATTERY BACKUP	2
X2	PHILLIPS	VERWEM	120/277V, 1	2	LED	2	UNIVERSAL	LED EXIT (RED) LETTERS; EMERGENCY BATTERY BACK-UP	2
N	PHILLIPS	PLEMBZ	120/277V, 1	24	LED	8	WALL	LED WALL MOUNT; EMERGENCY BATTERY BACK-UP; 4500K	2

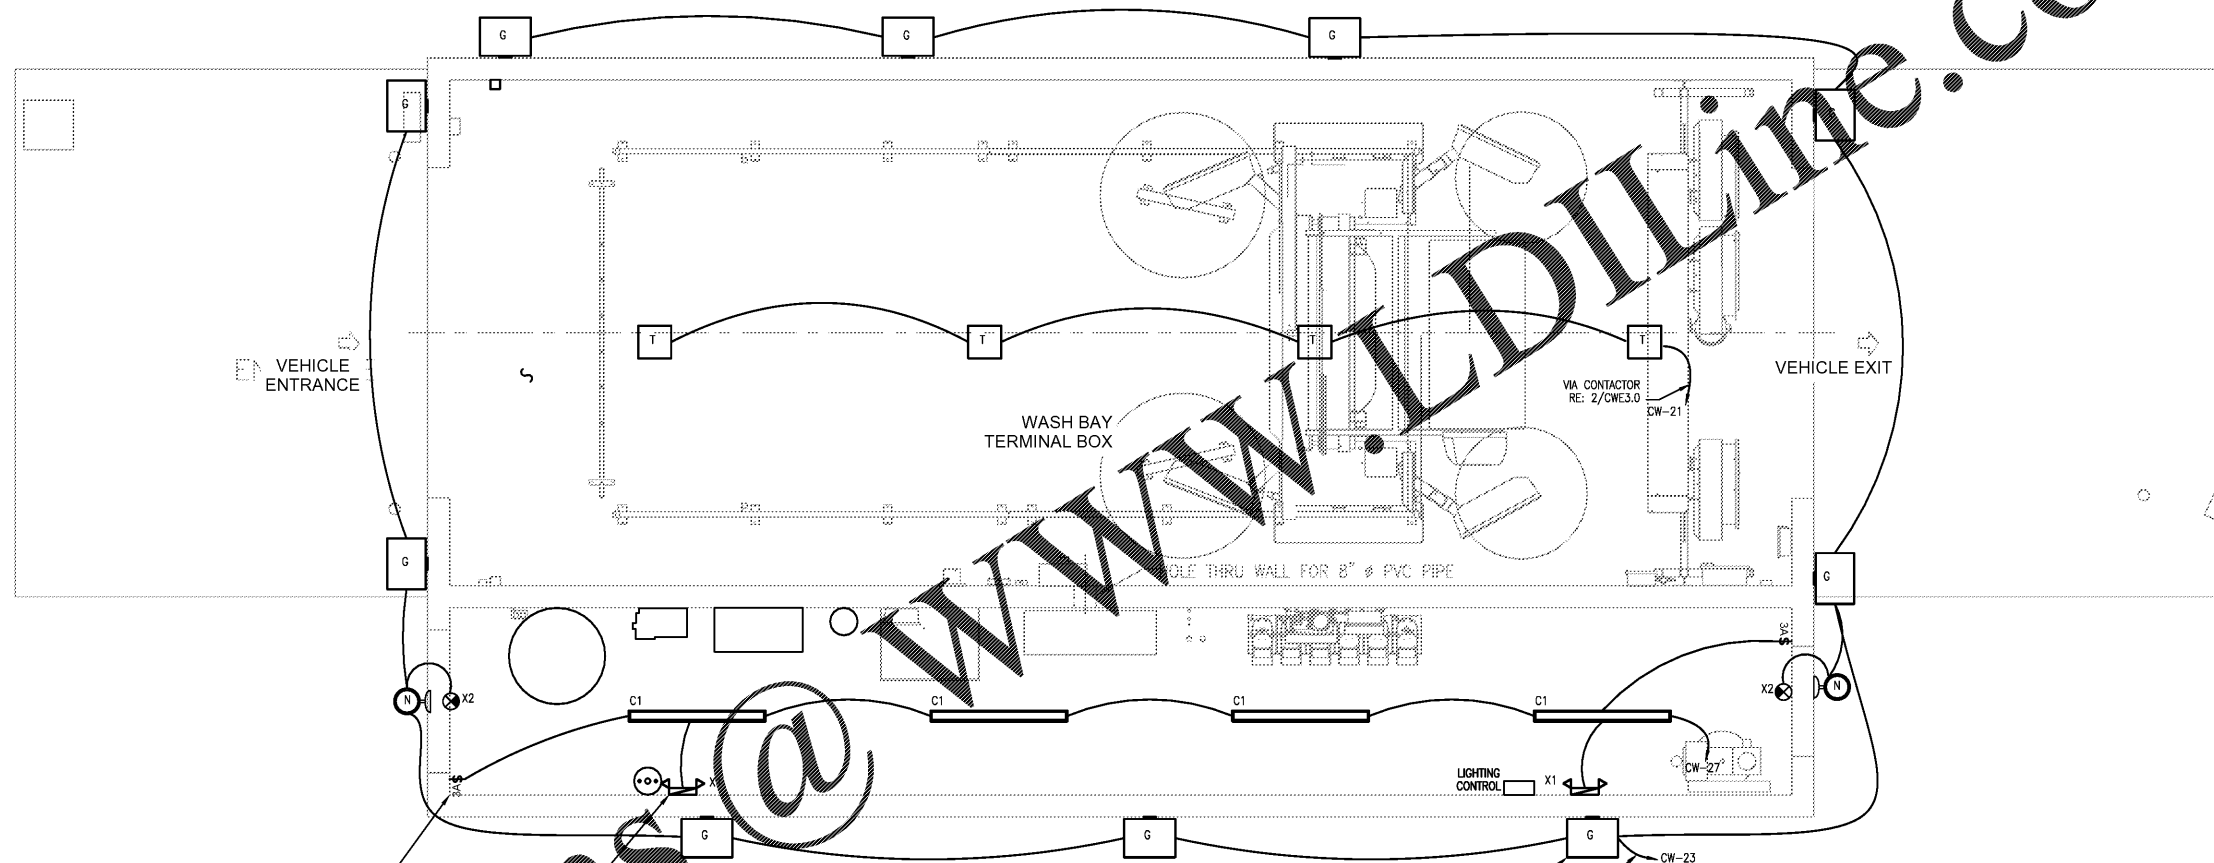


ELECTRICAL LIGHTING PLAN

3/8" = 1'-0"

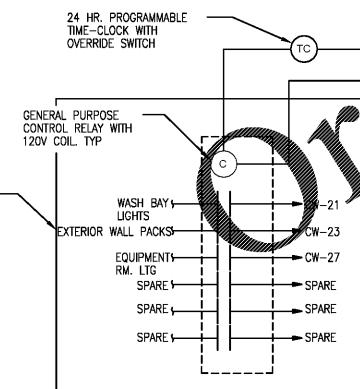

2 TIME CLOCK CONTACTOR
N.T.S.

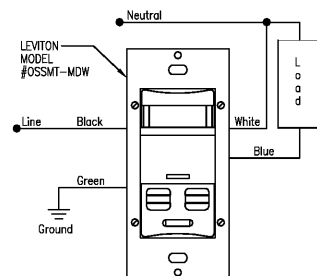

3 "A" OCCUPANCY SENSOR
N.T.S.

NOTE: RESTROOM SET TO 10 MINUTES.
BACKROOM AND OFFICES SET TO 20 MINUTES.
BACKROOM WITH HIDDEN AREAS SET TO 30 MINUTES.

WWW.LEDLINE.COM

Order Plans @

COPYRIGHT © 2019 INTERPLAN LLC. RESERVE COPYRIGHT & OTHER RIGHTS RESTRICTING THESE DOCUMENTS TO THE ORIGINAL USE OR TAMPORING WHICH THEY WERE PREPARED. REPRODUCTIONS, CHANGES OR ASSIGNMENTS ARE PROHIBITED.