


DEMOLITION LEGEND
 [Hatched Box] EXISTING CHWS&R PIPING TO BE REMOVED
 [Hatched Box] EXISTING DUCTWORK TO BE REMOVED

- DEMOLITION KEY NOTES:**
- 1 REMOVE EXISTING AIR HANDLING UNIT AND REPLACE WITH NEW. REMOVE PORTION OF SUPPLY AND RETURN DUCTWORK IN ORDER TO REPLACE THE UNIT.
 - 2 REMOVE EXISTING FAN COIL UNIT AND DISCH. HEATER AND REPLACE WITH NEW. REMOVE PORTION OF SUPPLY AND RETURN DUCTWORK IN ORDER TO REPLACE THE UNIT.
 - 3 NOT USED.
 - 4 REMOVE EXISTING FAN COIL UNIT AND REPLACE WITH NEW. REMOVE PORTION OF SUPPLY AND RETURN DUCTWORK IN ORDER TO REPLACE THE UNIT.
 - 5 REMOVE EXISTING EXTERIOR CONDENSER UNIT AND REPLACE WITH NEW.

DEMOLITION NOTES:
 A. EXISTING CONTROLS ARE BEING REPLACED WITH NEW DDC CONTROLS. ALL EXISTING CONTROLS ARE TO BE REMOVED. REFER TO CONTROL SCHEMATIC SHEET M-302 FOR NEW CONTROLS REQUIREMENTS.

RECEIVED
 DEC 19 2017
 BUILDING DEPARTMENT
 BCPS

Bid Documents Only
 Not For Construction

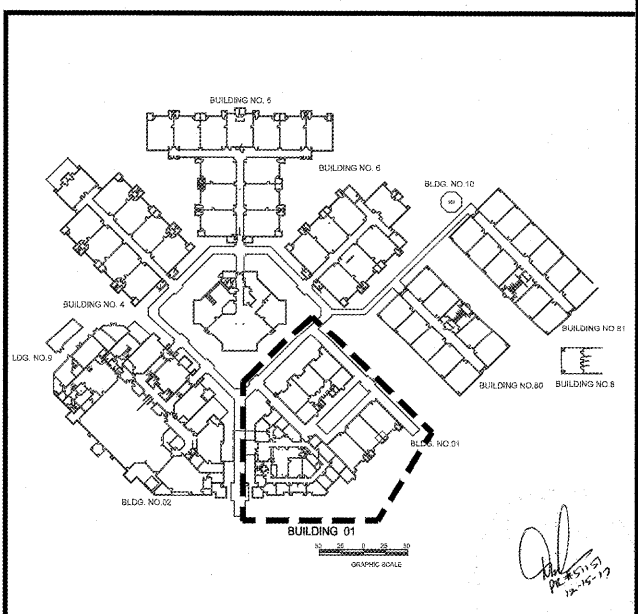


PARTIAL DEMO MECHANICAL
 FLOOR PLAN BUILDING 01

JOB PHASE: 100% SUBMITTAL
 SBBC PROJECT: P-001632
 DATE: 12.13.16
 SCALE: AS SHOWN
 DRAWN BY: E.H.
 CHECKED BY: H.A.
 FL LICENSE PE# 39048
 CAE PROJECT NO. 2015.95

ERIC HAMMOND
 PROFESSIONAL ENGINEER
 SEAL

DRAWING No.
DM-101

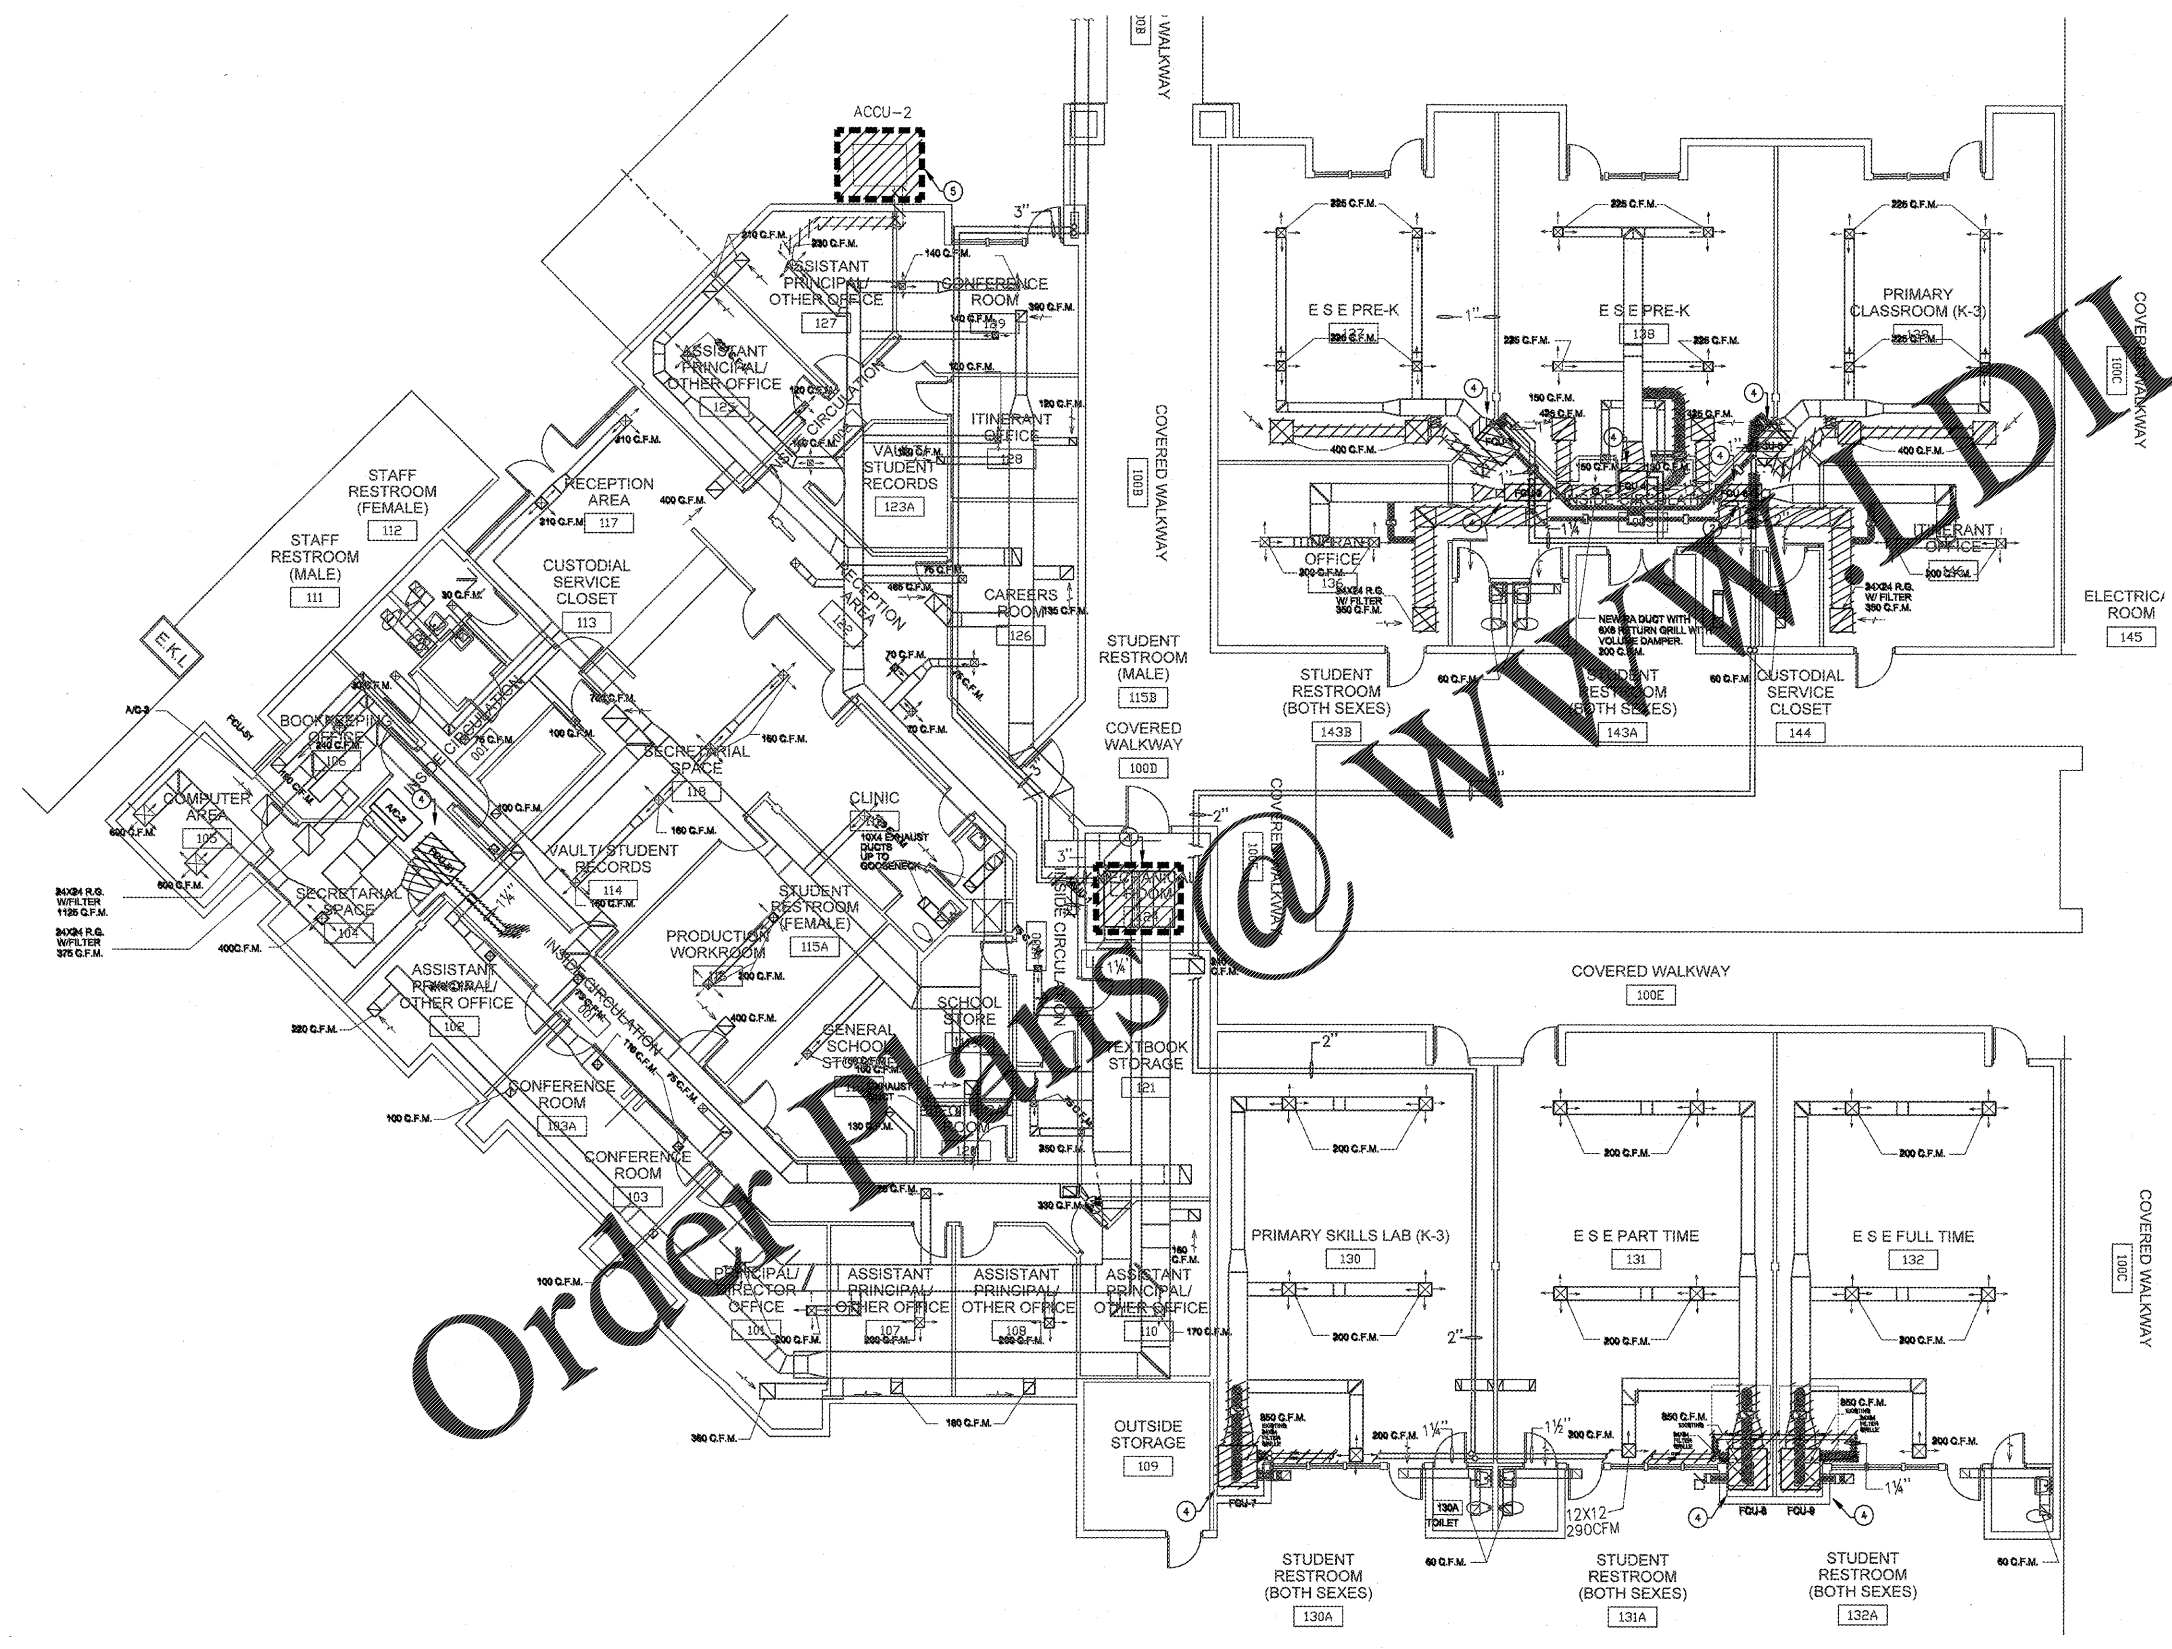

2 PARTIAL DEMO MECHANICAL FLOOR PLAN BUILDING 01
 SCALE: 1/8" = 1'-0"

1 KEY PLAN
 SCALE: 1" = 100'-0"

Order Plans @ www.drawing.com