 
 



Order Plans @ www.LDILine.com

DEMOLITION LEGEND
 EXISTING CHWS&R PIPING TO BE REMOVED
 EXISTING DUCTWORK TO BE REMOVED


DEMOLITION KEY NOTES:
 ① REMOVE EXISTING AIR HANDLING UNIT AND REPLACE WITH NEW. REMOVE PORTION OF SUPPLY AND RETURN DUCTWORK IN ORDER TO REPLACE THE UNIT.

DEMOLITION NOTES:
 A. EXISTING CONTROLS ARE BEING REPLACED WITH NEW DDC CONTROLS. ALL EXISTING CONTROLS ARE TO BE REMOVED. REFER TO CONTROL SCHEMATIC SHEET M-302 FOR NEW CONTROLS REQUIREMENTS.

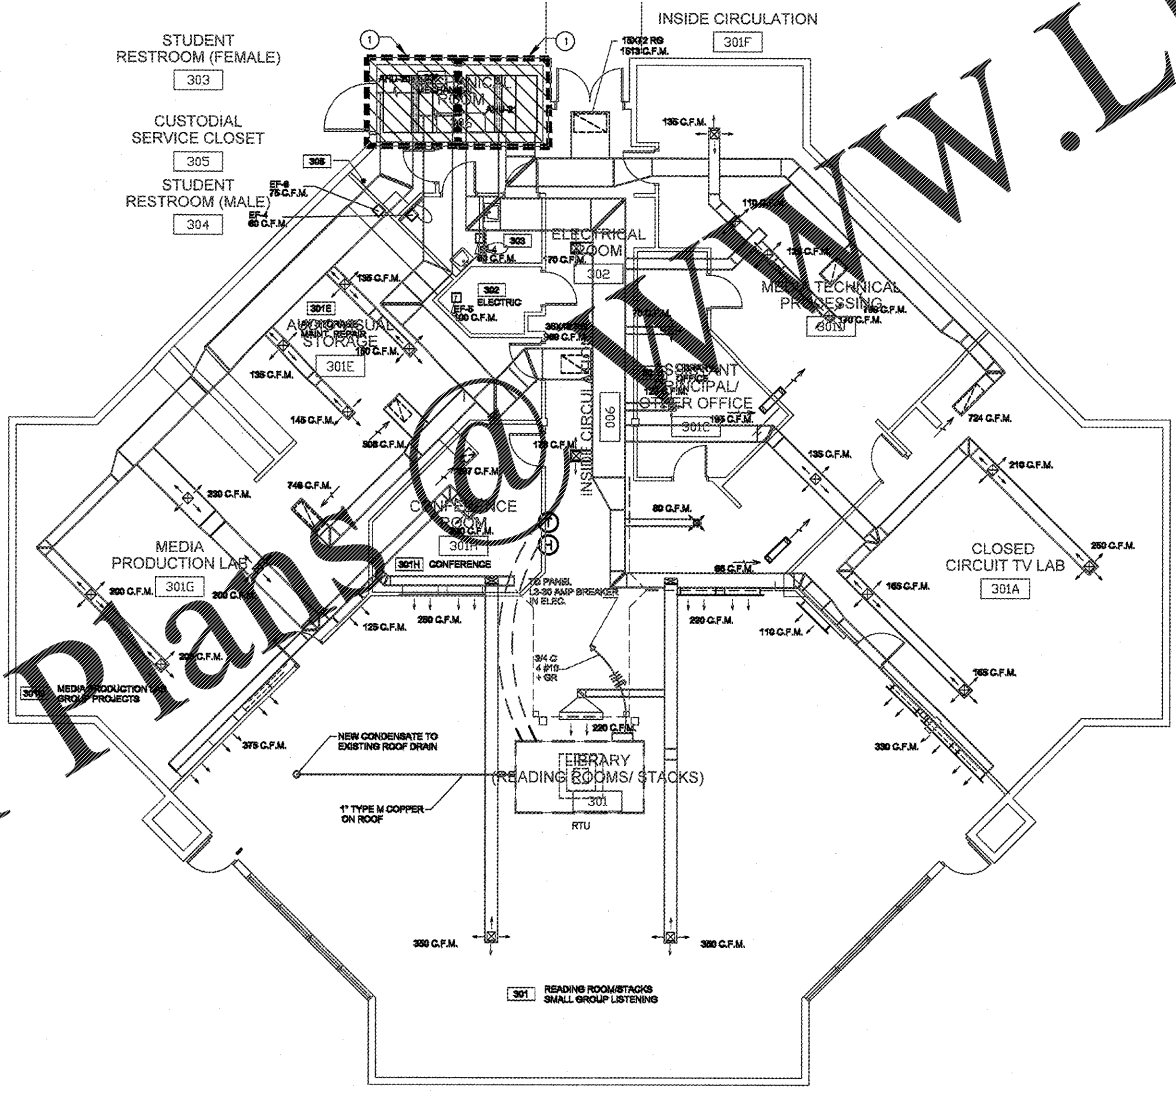

RECEIVED
 DEC 19 2017
 BUILDING DEPARTMENT
 BCPS

Bid Documents Only
 Not For Construction

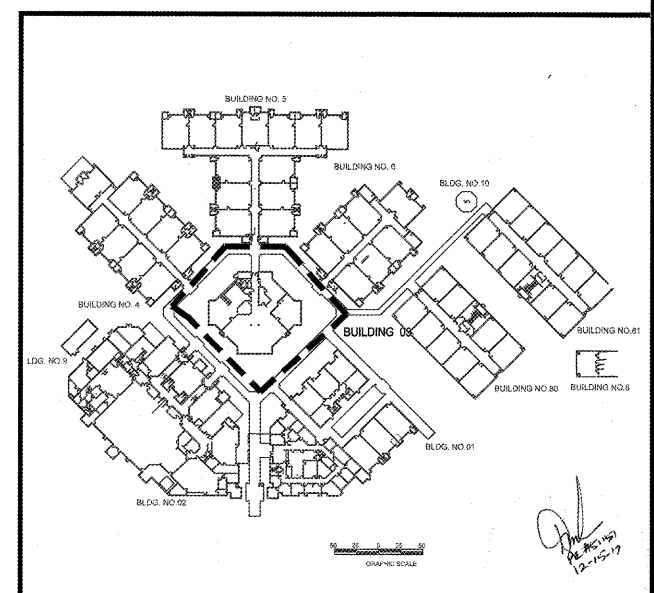

REVISIONS

SEA CASTLE
 ELEMENTARY SCHOOL
 9600 MIRAMAR BOULEVARD
 MIRAMAR, FLORIDA 33025



THE SCHOOL BOARD OF BROWARD COUNTY

PARTIAL DEMO MECHANICAL
 FLOOR PLAN BUILDING 03

JOB PHASE: 100% SUBMITTAL
 SBBP PROJECT: P-001632
 DATE: 12.13.16
 SCALE: AS SHOWN
 DRAWN BY: HA
 CHECKED BY: E.H.
 CAE PROJECT NO. 2015.55
 FL. LICENSE PE# 39048

ERIC HAMMOND
 PROFESSIONAL ENGINEER
 SEAL
 DRAWING No.

DM-103

THIS IS A VIOLATION OF THE LAW FOR ANY PERSON, UNLESS ACTING UNDER THE DIRECTION OF A LICENSED ARCHITECT, TO ALTER THESE PLANS AND SPECIFICATIONS. THIS DOCUMENT CONTAINS PROPERTY INFORMATION AND SHALL NOT BE USED OR REPRODUCED, OR ITS CONTENTS DISCLOSED, IN WHOLE OR IN PART, WITHOUT THE PRIOR WRITTEN CONSENT OF CRAIN ATLANTIS ENGINEERING, INC.