


DEMOLITION LEGEND
 [Hatched Pattern] EXISTING CHWS&R PIPING TO BE REMOVED
 [Hatched Pattern] EXISTING DUCTWORK TO BE REMOVED

DEMOLITION KEY NOTES:
 ① REMOVE EXISTING FAN COIL UNIT AND DUCT HEATER AND REPLACE WITH NEW. REMOVE PORTION OF SUPPLY AND RETURN DUCTWORK IN ORDER TO REPLACE THE UNIT.

DEMOLITION NOTES:
 A. EXISTING CONTROLS ARE BEING REPLACED WITH NEW DDC CONTROLS. ALL EXISTING CONTROLS ARE TO BE REMOVED. REFER TO CONTROL SCHEMATIC SHEET M-302 FOR NEW CONTROLS REQUIREMENTS.

RECEIVED
 DEC 19 2017
 BUILDING DEPARTMENT
 BCPS

Bid Documents Only
 Not For Construction

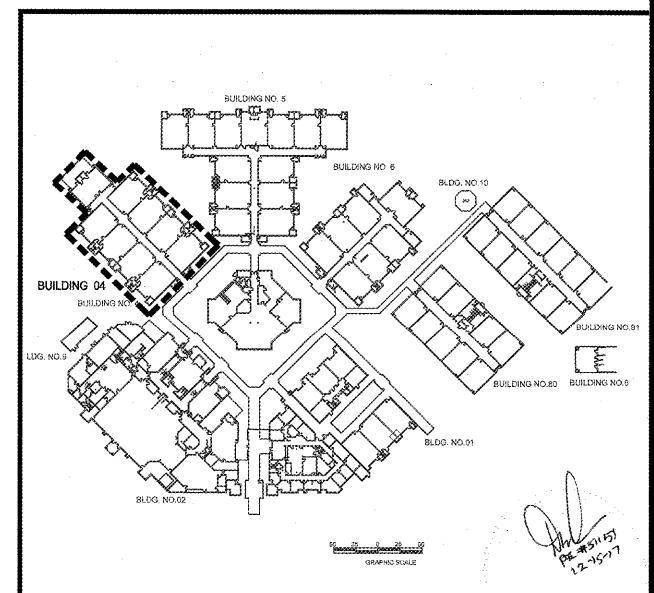

Order Plans @ plans@dwgline.com

PARTIAL DEMO MECHANICAL FLOOR PLAN BUILDING 04

JOB PHASE: 100% SUBMITTAL
 SBEC PROJECT: P-001632
 DATE: 12.13.16
 SCALE: AS SHOWN
 DRAWN BY: HA
 CHECKED BY: E.H.
 CAE PROJECT NO. 201635
 FL LICENSE PE# 39048

ERIC HAMMOND
 PROFESSIONAL ENGINEER
 SEAL
 DRAWING No.

THE SCHOOL BOARD OF BROWARD COUNTY

THIS IS A VIOLATION OF THE LAW FOR ANY PERSON, UNLESS ACTING UNDER THE DIRECTION OF A LICENSED ARCHITECT, TO ALTER THESE PLANS AND SPECIFICATIONS. THIS DOCUMENT CONTAINS PROPERTY INFORMATION AND SHALL NOT BE USED OR REPRODUCED, OR ITS CONTENTS DISCLOSED, IN WHOLE OR IN PART, WITHOUT THE PRIOR WRITTEN CONSENT OF CRAIN ATLANTIS ENGINEERING, INC. COPYRIGHT 2014 CRAIN ATLANTIS ENGINEERING, INC.