


HAMMOND & ASSOCIATES, INC.
 CONSULTING ENGINEERS
 7348 NW 5TH STREET
 PLANTATION, FLORIDA 33317
 TEL: (954) 327-7111 FAX (954) 327-7154
 ERIC J. HAMMOND P.E.
 MECHANICAL / ELECTRICAL ENGINEER
 P.E. #39048
 EB 5315

CRAIN ATLANTIS
 ENGINEERING, INC.
 CONSULTING ENGINEERS & ARCHITECTS
 210 SW NINTH AVENUE
 DEERFIELD BEACH, FLORIDA 33441
 AA 2601855 EB - 27498

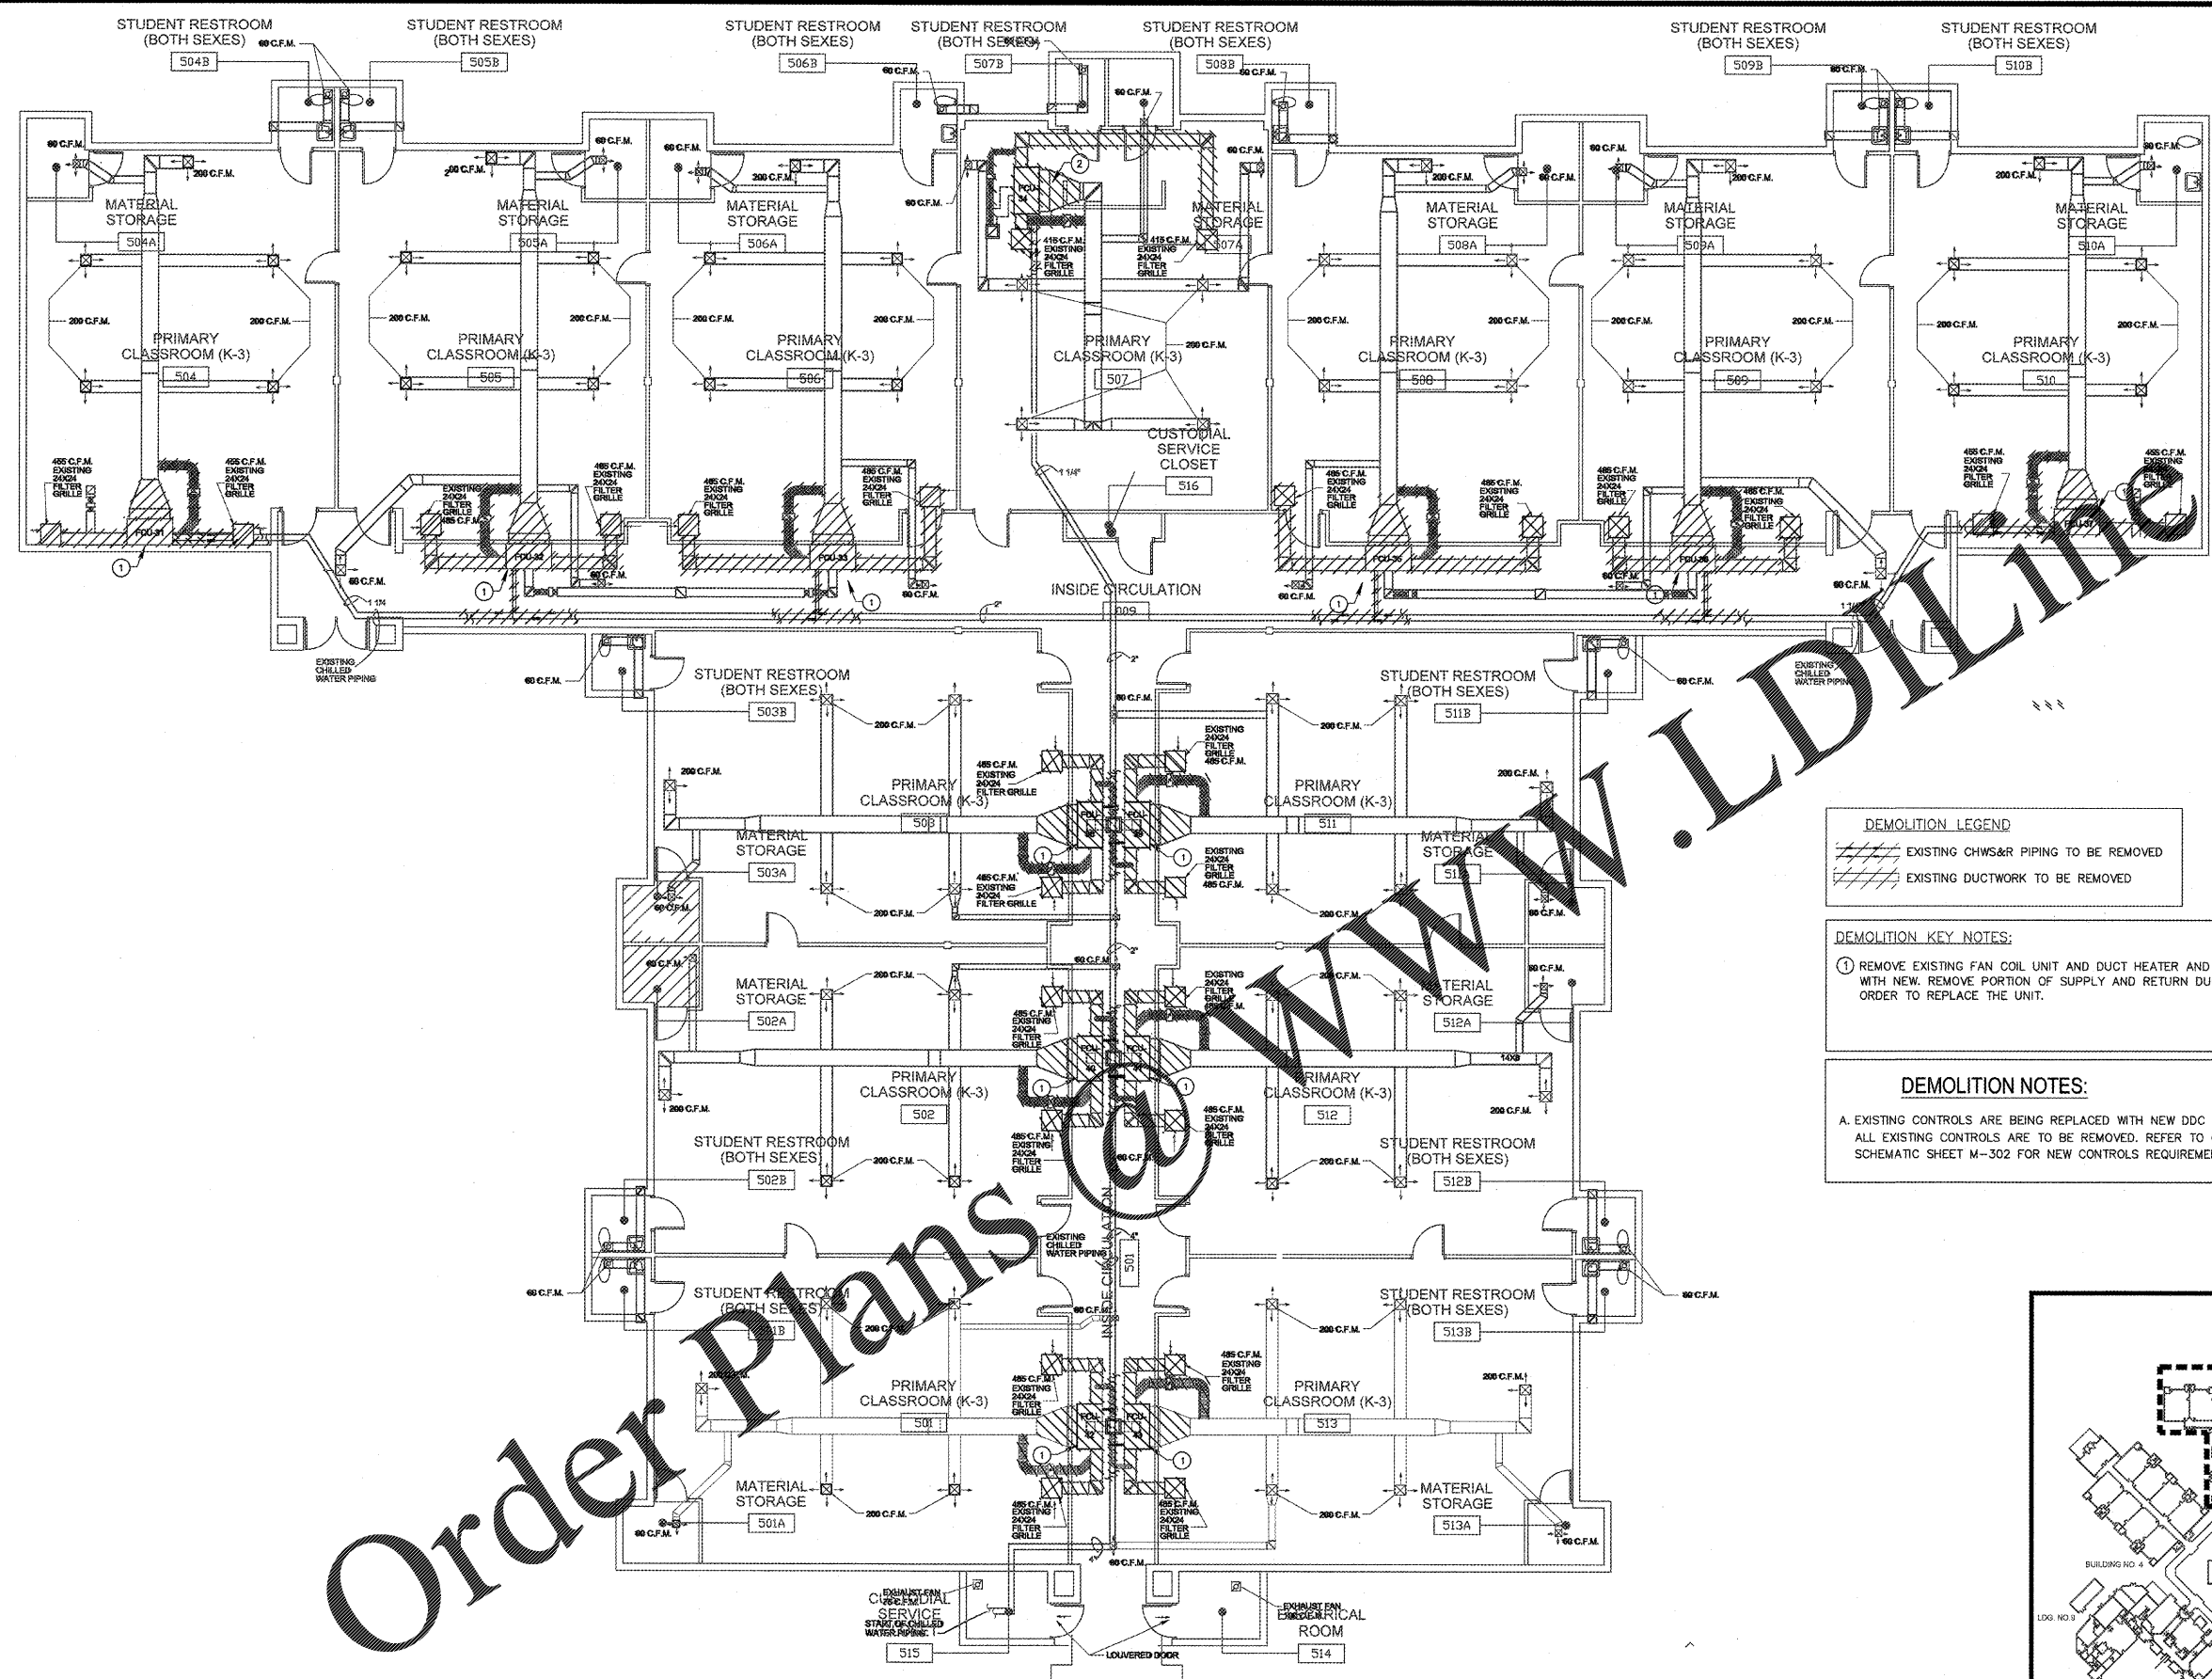


DEMOLITION LEGEND
 [Hatched pattern] EXISTING CHWS&R PIPING TO BE REMOVED
 [Dashed pattern] EXISTING DUCTWORK TO BE REMOVED

DEMOLITION KEY NOTES:
 ① REMOVE EXISTING FAN COIL UNIT AND DUCT HEATER AND REPLACE WITH NEW. REMOVE PORTION OF SUPPLY AND RETURN DUCTWORK IN ORDER TO REPLACE THE UNIT.

DEMOLITION NOTES:
 A. EXISTING CONTROLS ARE BEING REPLACED WITH NEW DDC CONTROLS. ALL EXISTING CONTROLS ARE TO BE REMOVED. REFER TO CONTROL SCHEMATIC SHEET M-302 FOR NEW CONTROLS REQUIREMENTS.

RECEIVED
 DEC 19 2017
 BUILDING DEPARTMENT
 BCPS

Bid Documents Only
 Not For Construction

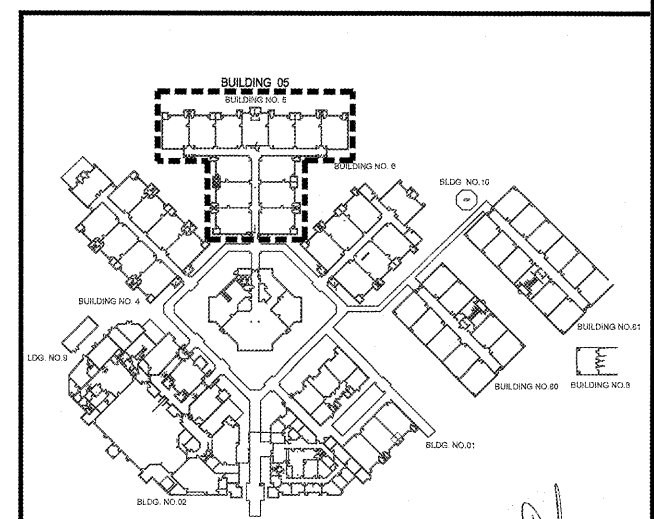

Order Plans
 WWW.LDLINE.com

SEA CASTLE
 ELEMENTARY SCHOOL
 9600 MIRAMAR BOULEVARD
 MIRAMAR, FLORIDA 33025

THE SCHOOL BOARD OF BROWARD COUNTY

PARTIAL DEMO MECHANICAL
 FLOOR PLAN BUILDING 05

JOB PHASE: 100% SUBMITTAL
 SBBC PROJECT: P-001632
 DATE: 12.13.16
 SCALE: AS SHOWN
 DRAWN BY: E.H.
 CHECKED BY: E.H.
 CAE PROJECT NO. 2015.05
 FL LICENSE PE# 39048

ERIC HAMMOND
 PROFESSIONAL ENGINEER
 SEAL
 DRAWING No.

THIS IS A VIOLATION OF THE LAW FOR ANY PERSON, UNLESS ACTING UNDER THE DIRECTION OF A LICENSED ARCHITECT, TO ALTER THESE PLANS AND SPECIFICATIONS. THIS DOCUMENT CONTAINS PROPERTY INFORMATION AND SHALL NOT BE USED OR REPRODUCED, OR ITS CONTENTS DISCLOSED, IN WHOLE OR IN PART, WITHOUT THE PRIOR WRITTEN CONSENT OF CRAIN ATLANTIS ENGINEERING, INC. COPYRIGHT 2014 CRAIN ATLANTIS ENGINEERING, INC.