

HAMMOND & ASSOCIATES, INC.
 CONSULTING ENGINEERS
 7348 NW 5TH STREET
 PLANTATION, FLORIDA 33317
 TEL: (954) 327-7111 FAX (954) 327-7154
 ERIC J. HAMMOND P.E.
 MECHANICAL / ELECTRICAL ENGINEER
 P.E. #33048
 EB 5315

CRAIN ATLANTIS
 ENGINEERING, INC.
 CONSULTING ENGINEERS & ARCHITECTS
 210 SW MADISON AVENUE, SUITE 3044
 DEERFIELD BEACH, FLORIDA 33441
 AA 28001808 EB - 27489

REVISIONS

SEA CASTLE
 ELEMENTARY SCHOOL
 9600 MIRAMAR BOULEVARD
 MIRAMAR, FLORIDA 33025



THE SCHOOL BOARD OF BROWARD COUNTY

RECEIVED
 DEC 19 2017
 BUILDING DEPARTMENT
 BCPS


Bid Documents Only
 Not For Construction

PARTIAL DEMO MECHANICAL
 FLOOR PLAN BUILDING 02


JOB PHASE: 100% SUBMITTAL
 SBDC PROJECT: P-001632
 DATE: 12.13.16
 SCALE: AS SHOWN
 DRAWN BY: HA
 CHECKED BY: EH
 CAE PROJECT NO. 2015.55
 FL. LICENSE PE# 39048

ERIC HAMMOND
 PROFESSIONAL ENGINEER
 SEAL

DRAWING No.
 DM-102

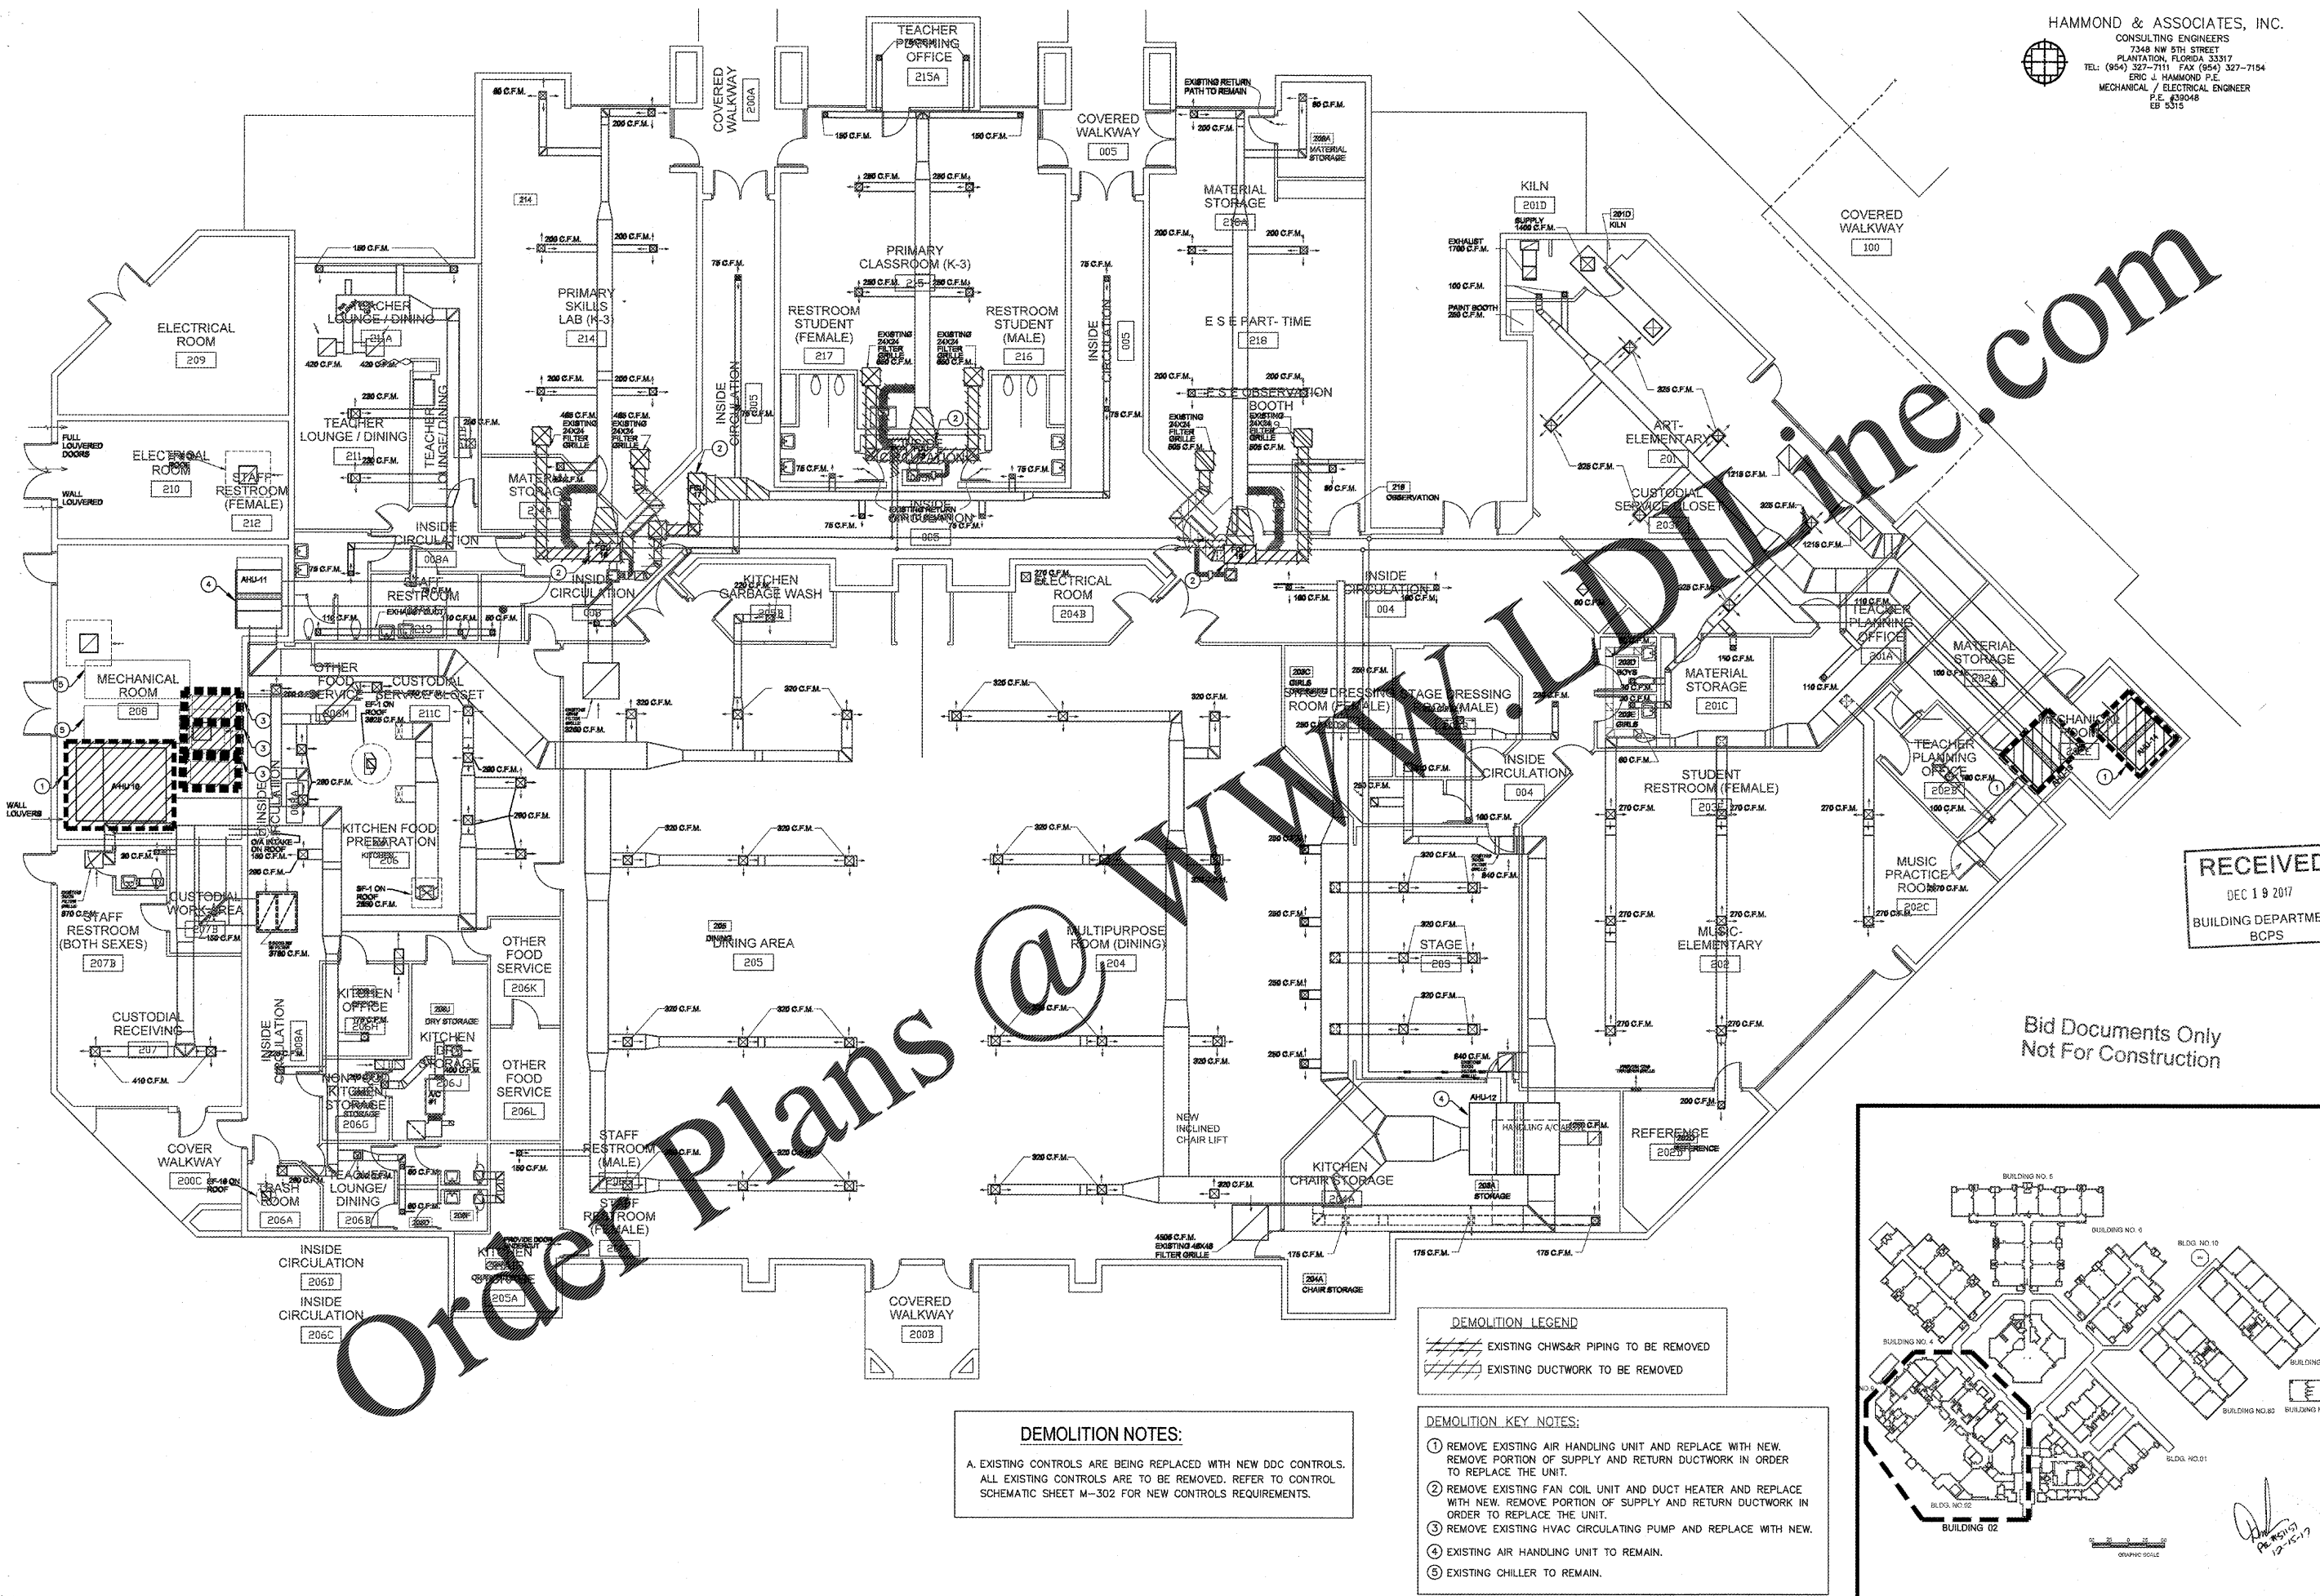


Order Plans @ www.lidline.com

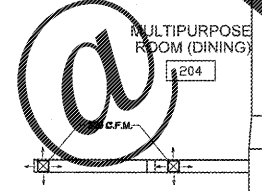

DEMOLITION NOTES:
 A. EXISTING CONTROLS ARE BEING REPLACED WITH NEW DDC CONTROLS. ALL EXISTING CONTROLS ARE TO BE REMOVED. REFER TO CONTROL SCHEMATIC SHEET M-302 FOR NEW CONTROLS REQUIREMENTS.

DEMOLITION LEGEND
 [Symbol] EXISTING CHWS&R PIPING TO BE REMOVED
 [Symbol] EXISTING DUCTWORK TO BE REMOVED

DEMOLITION KEY NOTES:
 ① REMOVE EXISTING AIR HANDLING UNIT AND REPLACE WITH NEW. REMOVE PORTION OF SUPPLY AND RETURN DUCTWORK IN ORDER TO REPLACE THE UNIT.
 ② REMOVE EXISTING FAN COIL UNIT AND DUCT HEATER AND REPLACE WITH NEW. REMOVE PORTION OF SUPPLY AND RETURN DUCTWORK IN ORDER TO REPLACE THE UNIT.
 ③ REMOVE EXISTING HVAC CIRCULATING PUMP AND REPLACE WITH NEW.
 ④ EXISTING AIR HANDLING UNIT TO REMAIN.
 ⑤ EXISTING CHILLER TO REMAIN.

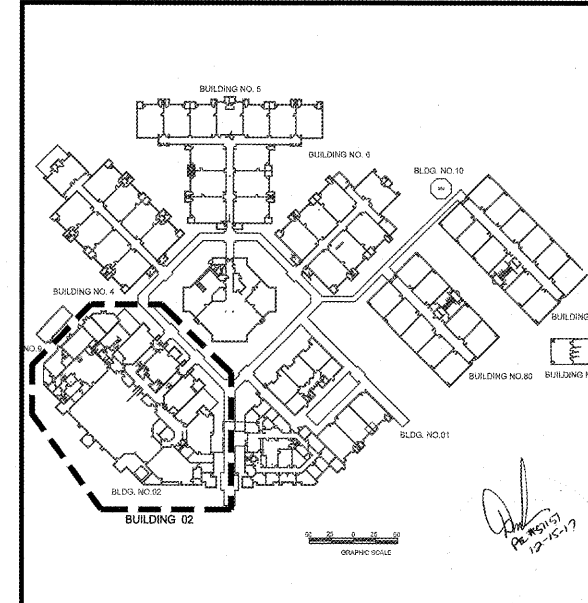

THIS IS A VIOLATION OF THE LAW FOR ANY PERSON, UNLESS ACTING UNDER THE DIRECTION OF A LICENSED ARCHITECT, TO ALTER THESE PLANS AND SPECIFICATIONS. THIS DOCUMENT CONTAINS PROPRIETARY INFORMATION AND SHALL NOT BE USED OR REPRODUCED, IN WHOLE OR IN PART, WITHOUT THE WRITTEN CONSENT OF CRAIN ATLANTIS ENGINEERING, INC. COPYRIGHT 2014 CRAIN ATLANTIS ENGINEERING, INC.