


HAMMOND & ASSOCIATES, INC.
 CONSULTING ENGINEERS
 7348 NW 5TH STREET
 PLANTATION, FLORIDA, 33317
 TEL: (954) 327-7111 FAX (954) 327-7154
 ERIC J. HAMMOND P.E.
 MECHANICAL / ELECTRICAL ENGINEER
 P.E. #39048
 EB 0315

CRAIN ATLANTIS
 ENGINEERING, INC.
 CONSULTING ENGINEERS & ARCHITECTS
 210 SW NINTWA AVENUE
 GAITHERSBURG, MD 20878
 P.A. 26071656 EB - 27488

REVISIONS	BUILDING DEPARTMENT COMMENTS
Δ 10/23/18	


RECEIVED
 MAR 06 2018
 BUILDING DEPARTMENT
 BCPS

DRAWING KEY NOTE:
 ① LOCATION OF NEW ROOF TOP UNIT. CONNECT TO EXISTING DUCTWORK IN CEILING BELOW.

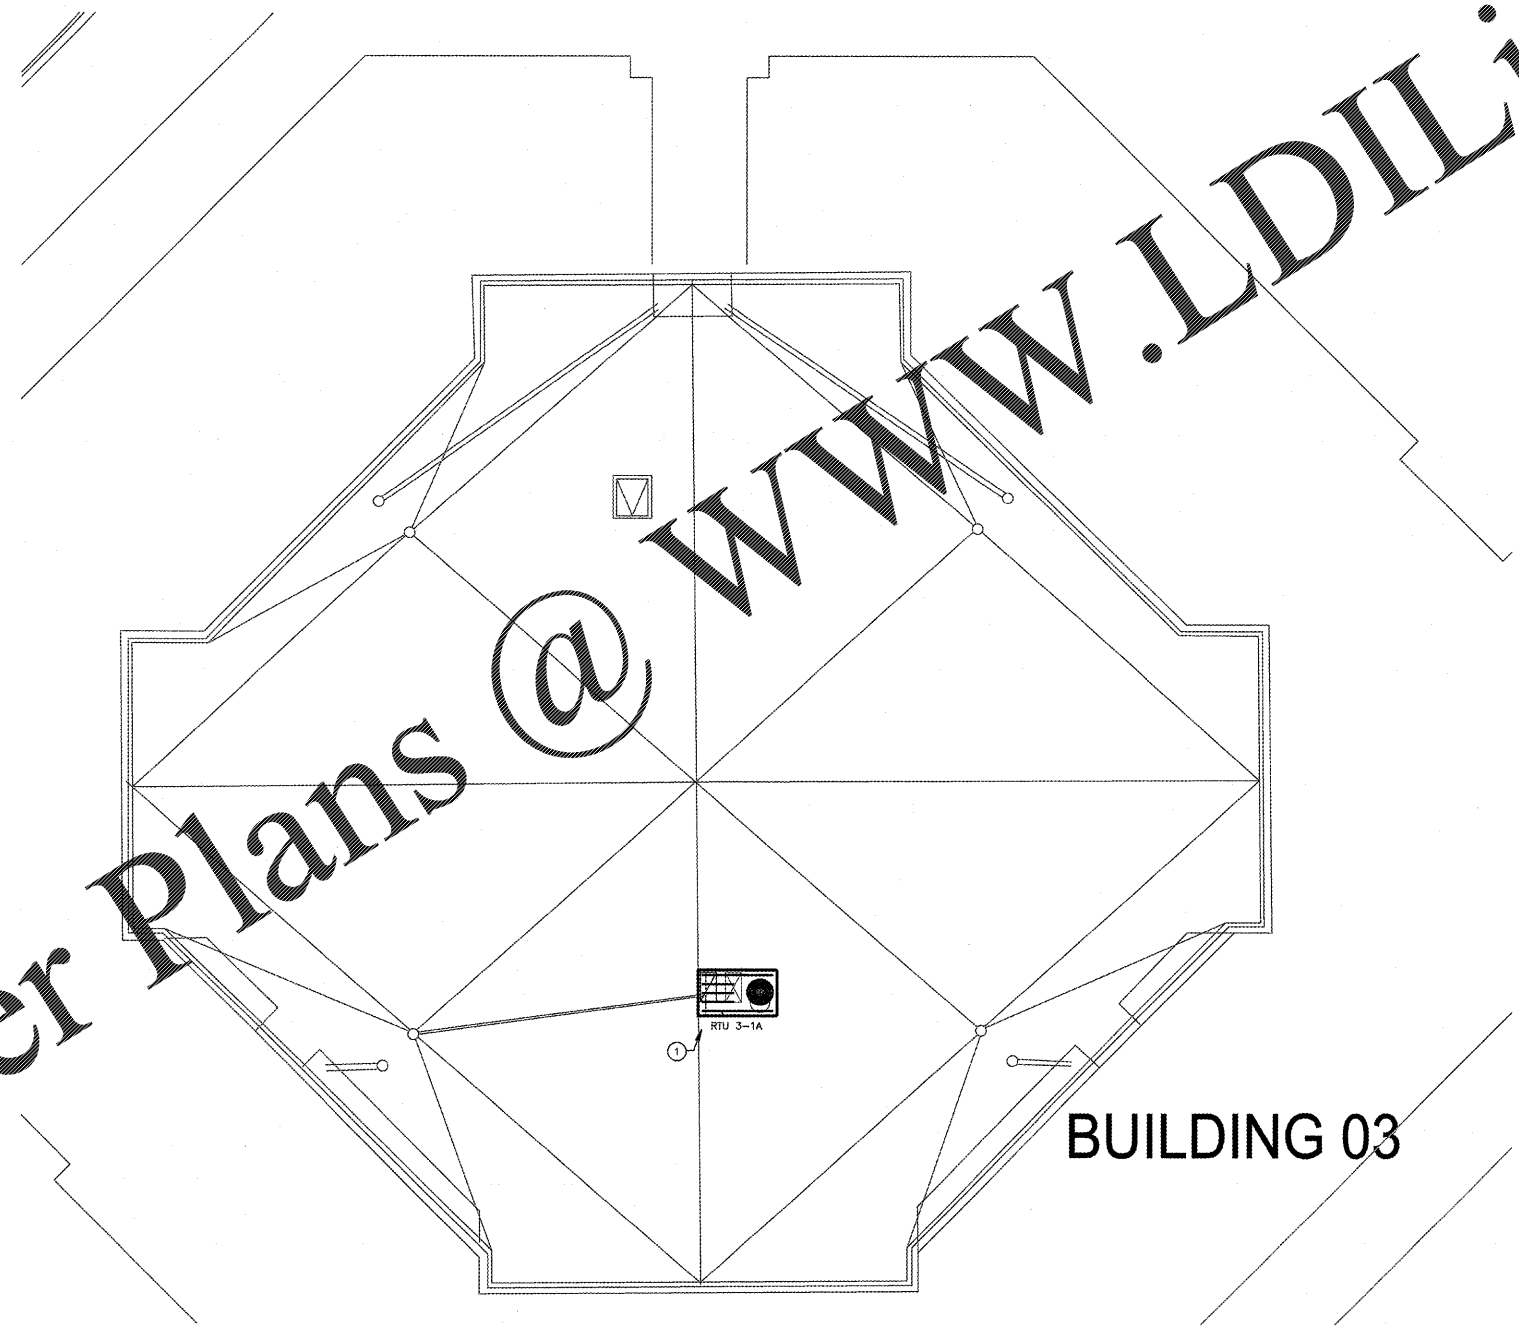

BUILDING 03

Bid Documents Only
 Not For Construction

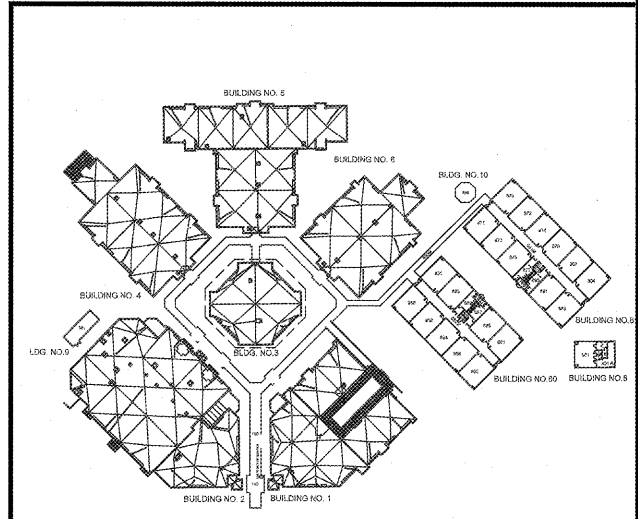

1 KEY PLAN
 SCALE: 1" = 100'-0"

Order Plans @ WWW.LDILine.com

SEA CASTLE
 ELEMENTARY SCHOOL
 9600 MIRAMAR BOULEVARD
 MIRAMAR, FLORIDA 33025



THE SCHOOL BOARD OF BROWARD COUNTY

MECHANICAL ROOF
 PLAN BUILDING 03

100% SUBMITTAL
 JOB PHASE: P 001652
 AS SHOWN
 DATE: 12.13.16
 DRAWN BY: HA
 CHECKED BY: E.H.
 CAE PROJECT No. 2016.55

ERIC HAMMOND
 PROFESSIONAL ENGINEER
 SEAL

DRAWING No.

M-203

2 MECHANICAL DEMOLITION ROOF PLAN BUILDING 03
 SCALE: 1/8" = 1'-0"

IT IS A VIOLATION OF THE LAW FOR ANY PERSON, UNLESS ACTING UNDER THE DIRECTION OF A LICENSED ARCHITECT, TO ALTER THESE PLANS AND SPECIFICATIONS. THIS DOCUMENT CONTAINS PROPERTY INFORMATION AND SHALL NOT BE USED OR REPRODUCED, OR ITS CONTENTS DISCLOSED, IN WHOLE OR IN PART, WITHOUT THE PRIOR WRITTEN CONSENT OF CRAIN ATLANTIS ENGINEERING, INC. COPYRIGHT 2014 CRAIN ATLANTIS ENGINEERING, INC.