


- DEMOLITION KEY NOTES:**
- EXISTING AIR HANDLING UNIT TO BE REMOVED AND REPLACED WITH NEW. REMOVE EXISTING DISCONNECT ALONG WITH CONDUIT AND WIRING TO UNIT BEING REPLACED.
 - EXISTING FAN COIL UNIT AND DUCT HEATER TO BE REMOVED AND REPLACED WITH NEW. REMOVE EXISTING DISCONNECT ALONG WITH CONDUIT AND WIRING TO UNIT BEING REPLACED.
 - EXISTING HVAC CONDENSING PUMP TO BE REMOVED AND REPLACED WITH NEW. REMOVE EXISTING DISCONNECT ALONG WITH CONDUIT AND WIRING TO UNIT BEING REPLACED.
 - EXISTING FAN COIL UNIT TO BE REMOVED AND REPLACED WITH NEW. REMOVE EXISTING DISCONNECT ALONG WITH CONDUIT AND WIRING TO UNIT BEING REPLACED.
 - EXISTING CHILLER TO REMAIN.
 - EXISTING RTU LOCATED ON ROOF TO BE REMOVED AND REPLACED WITH NEW. REMOVE EXISTING DISCONNECT ALONG WITH CONDUIT AND WIRING TO UNIT BEING REPLACED.
 - EXISTING EXTERIOR CONDENSING UNIT TO BE REMOVED AND REPLACED WITH NEW. REMOVE EXISTING DISCONNECT ALONG WITH CONDUIT AND WIRING TO UNIT BEING REPLACED.
 - LOCATION OF EXISTING OUTLET TO REMAIN.
 - LOCATION OF EXISTING OUTLET TO BE REMOVED AND REPLACED WITH NEW.
 - EXISTING ROOFTOP EXHAUST FAN TO BE REMOVED AND REPLACED WITH NEW. REMOVE EXISTING DISCONNECT ALONG WITH CONDUIT AND WIRING TO UNIT BEING REPLACED.

- GENERAL NOTES:**
- REPLACE ALL EXISTING RECEPTACLES IN MECHANICAL ROOMS WITH NEW GFCI RECEPTACLES.
 - IN ALL MECHANICAL ROOMS RECEIVING NEW AIR HANDLING UNITS, RELOCATE EXISTING LIGHTING IN ORDER TO PROVIDE ADEQUATE LIGHTING FOR WORKING ON THE ELECTRICAL EQUIPMENT. COMPLY WITH NEC 110.26(D).

RECEIVED
 MAR 06 2018
 BUILDING DEPARTMENT
 BCPS

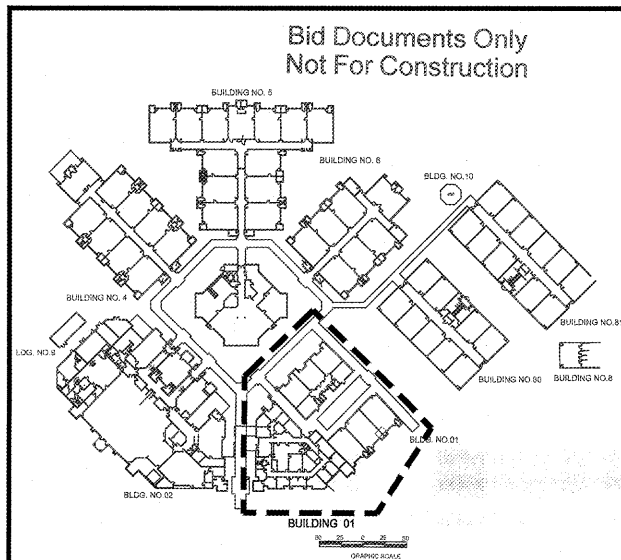

2 PARTIAL DEMOLITION ELECTRICAL FLOOR PLAN BUILDING 01
 SCALE: 1/8" = 1'-0"

1 KEY PLAN
 SCALE: 1" = 100'-0"

REVISIONS	BUILDING DEPARTMENT COMMENTS
02/23/18	

SEA CASTLE
 ELEMENTARY SCHOOL
 9600 MIRAMAR BOULEVARD
 MIRAMAR, FLORIDA 33025



THE SCHOOL BOARD OF BROWARD COUNTY

PARTIAL DEMOLITION
 ELECTRICAL FLOOR PLAN
 BUILDING 01

JOB PHASE: 100% SUBMITTAL
 SBBC PROJECT: P-001632
 DATE: 12.13.16
 SCALE: AS SHOWN
 DRAWN BY: HA
 CHECKED BY: EH
 CAE PROJECT NO. 2015.65



DRAWING NO.

DE-101

THIS IS A VALIDATION OF THE ORIGINAL DRAWING. IT IS NOT TO BE USED OR REPRODUCED, OR ITS CONTENTS DISCLOSED, IN WHOLE OR IN PART, WITHOUT THE PRIOR WRITTEN CONSENT OF CRAIN ATLANTIS ENGINEERING, INC. COPYRIGHT 2014 CRAIN ATLANTIS ENGINEERING, INC.