



- DEMOLITION KEY NOTES:**
- EXISTING AIR HANDLING UNIT TO BE REMOVED AND REPLACED WITH NEW. REMOVE EXISTING DISCONNECT ALONG WITH CONDUIT AND WIRING TO UNIT BEING REPLACED.
 - EXISTING FAN COIL UNIT AND DUCT HEATER TO BE REMOVED AND REPLACED WITH NEW. REMOVE EXISTING DISCONNECT ALONG WITH CONDUIT AND WIRING TO UNIT BEING REPLACED.
 - EXISTING HVAC CIRCULATING PUMP TO BE REMOVED AND REPLACED WITH NEW. REMOVE EXISTING DISCONNECT ALONG WITH CONDUIT AND WIRING TO UNIT BEING REPLACED.
 - EXISTING FAN COIL UNIT TO BE REMOVED AND REPLACED WITH NEW. REMOVE EXISTING DISCONNECT ALONG WITH CONDUIT AND WIRING TO UNIT BEING REPLACED.
 - EXISTING COILER TO REMAIN.
 - EXISTING RTU/CATERON ROOF TO BE REMOVED AND REPLACED WITH NEW. REMOVE EXISTING DISCONNECT ALONG WITH CONDUIT AND WIRING TO UNIT BEING REPLACED.
 - EXISTING EXTERIOR CONDENSING UNIT TO BE REMOVED AND REPLACED WITH NEW. REMOVE EXISTING DISCONNECT ALONG WITH CONDUIT AND WIRING TO UNIT BEING REPLACED.
 - LOCATION OF EXISTING OUTLET TO REMAIN.
 - LOCATION OF EXISTING OUTLET TO BE REMOVED AND REPLACED WITH NEW.
 - EXISTING ROOFTOP EXHAUST FAN TO BE REMOVED AND REPLACED WITH NEW. REMOVE EXISTING DISCONNECT ALONG WITH CONDUIT AND WIRING TO UNIT BEING REPLACED.

- GENERAL NOTES:**
- REPLACE ALL EXISTING RECEPTACLES IN MECHANICAL ROOMS WITH NEW GFCI RECEPTACLES.
 - IN ALL MECHANICAL ROOMS RECEIVING NEW AIR HANDLING UNITS, RELOCATE EXISTING LIGHTING IN ORDER TO PROVIDE ADEQUATE LIGHTING FOR WORKING ON THE ELECTRICAL EQUIPMENT. COMPLY WITH NEC 110.26(D).

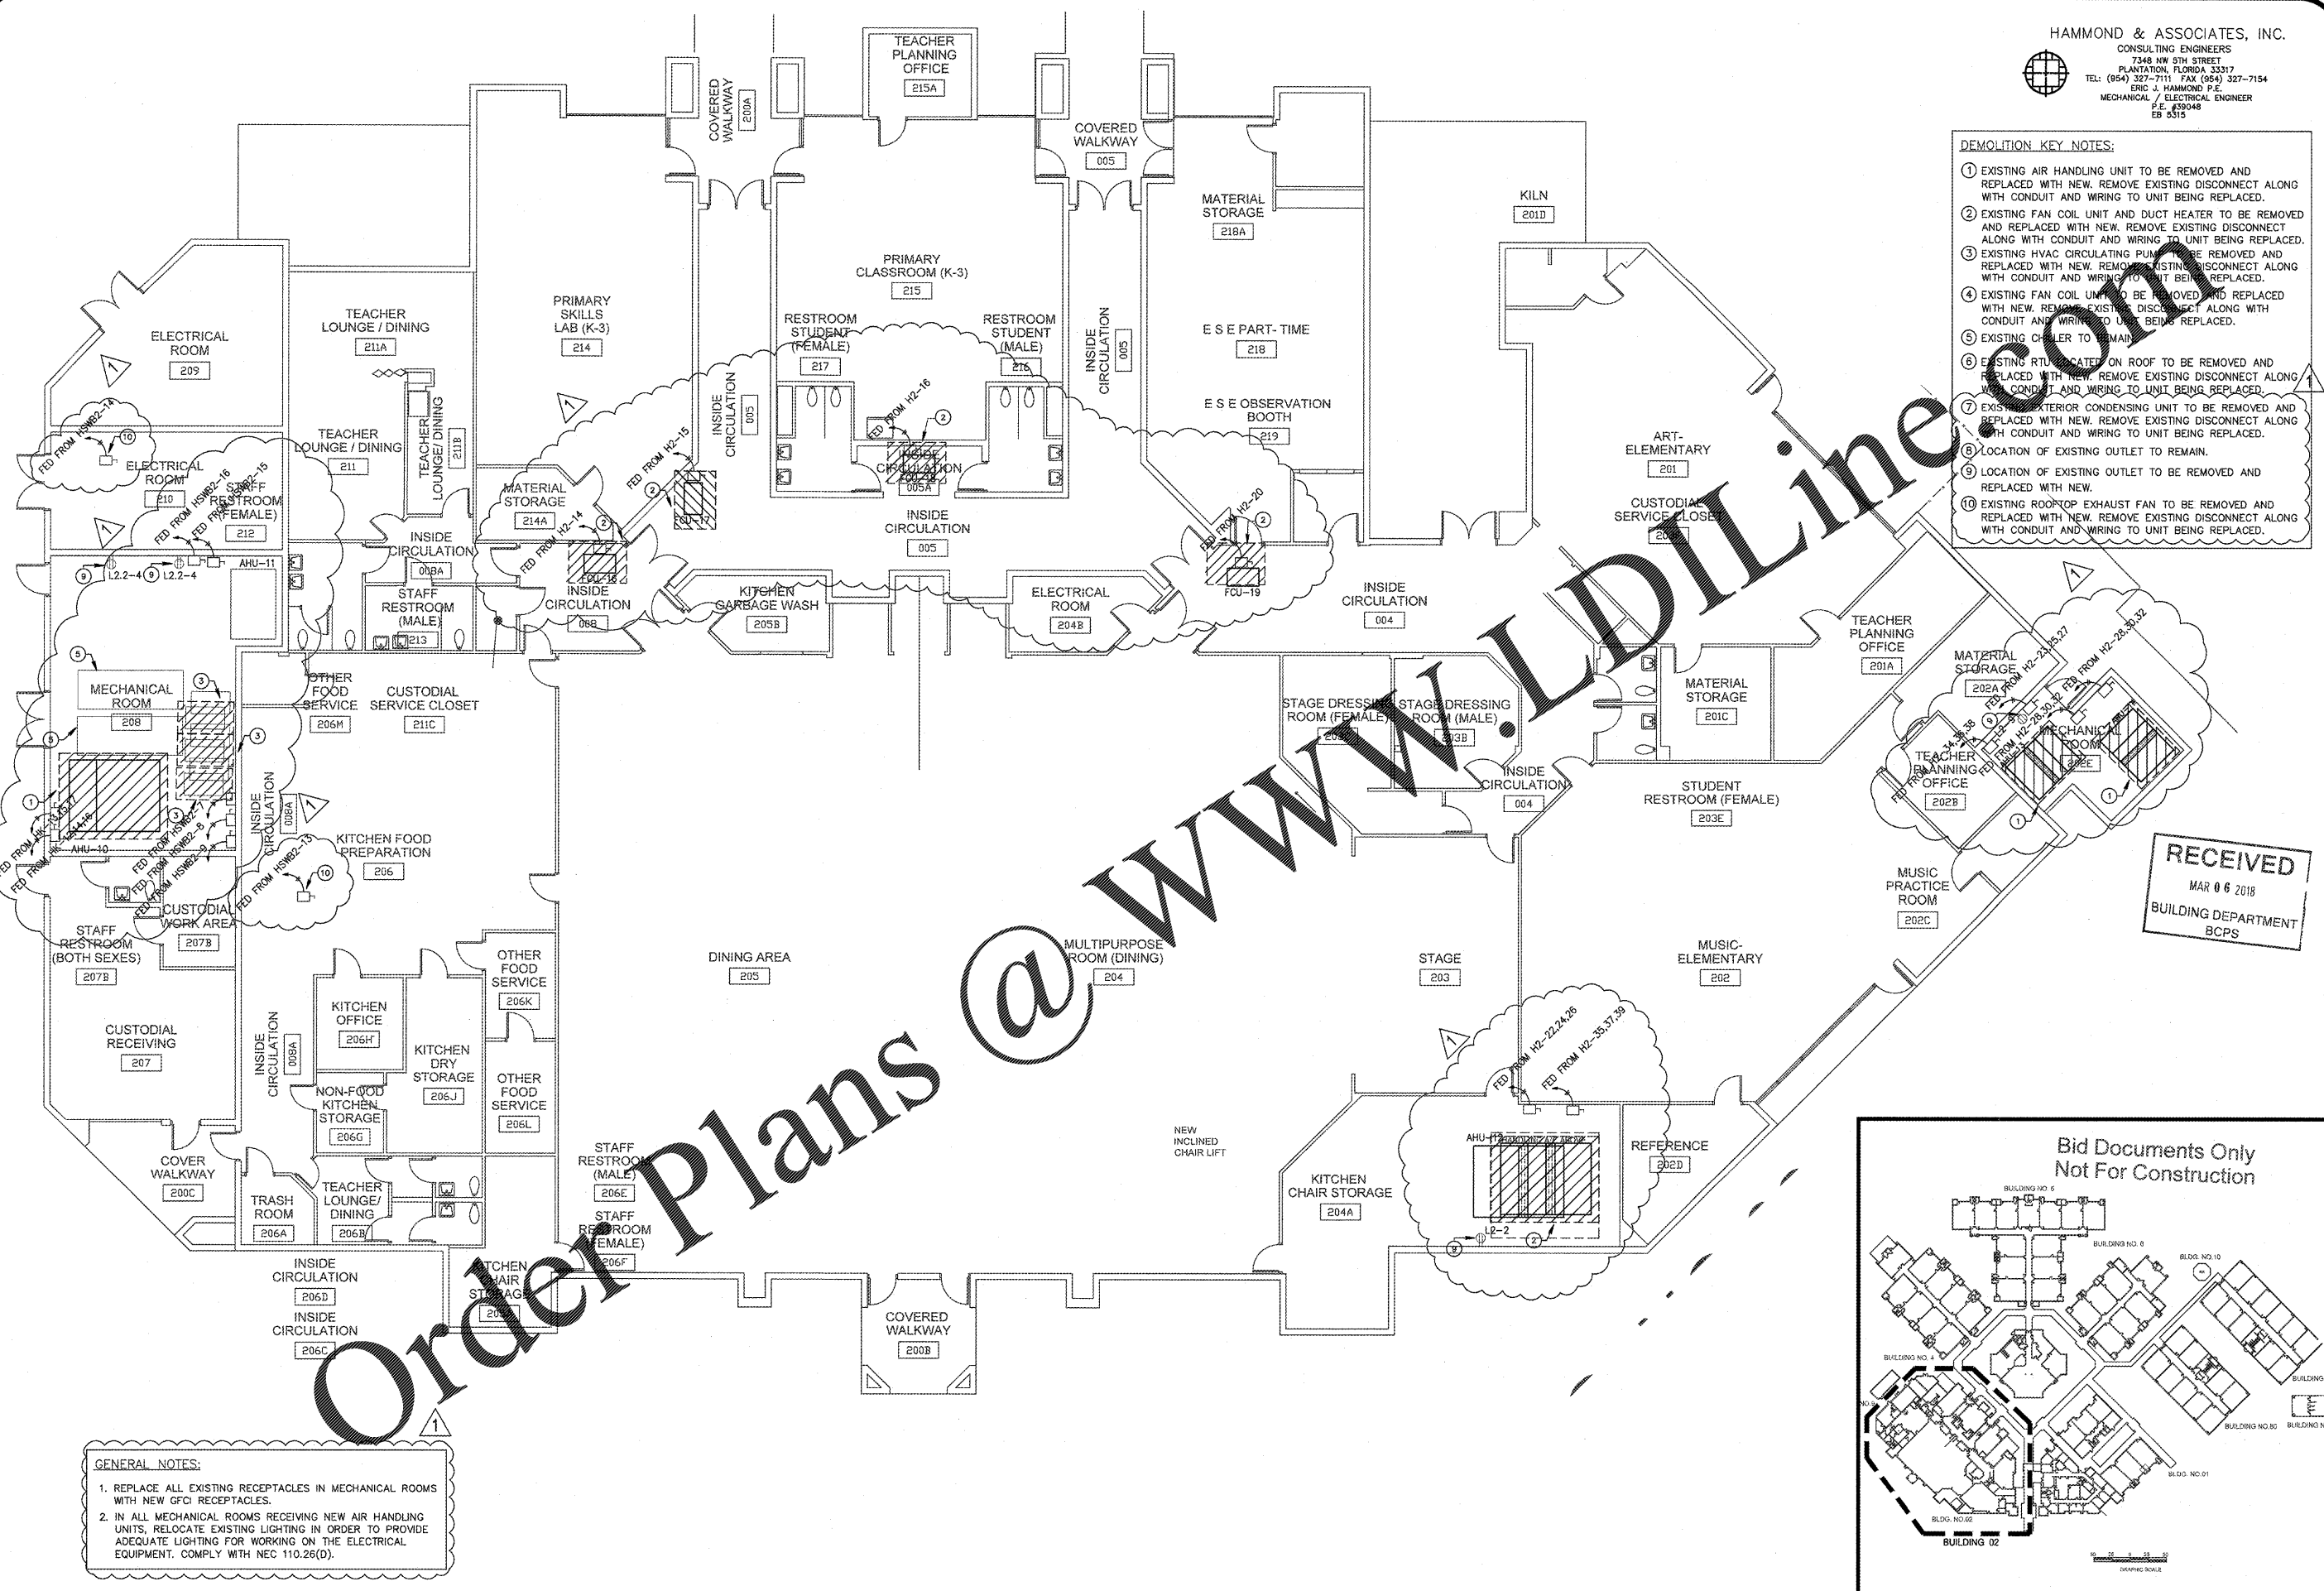

RECEIVED
 MAR 06 2018
 BUILDING DEPARTMENT
 BCPS

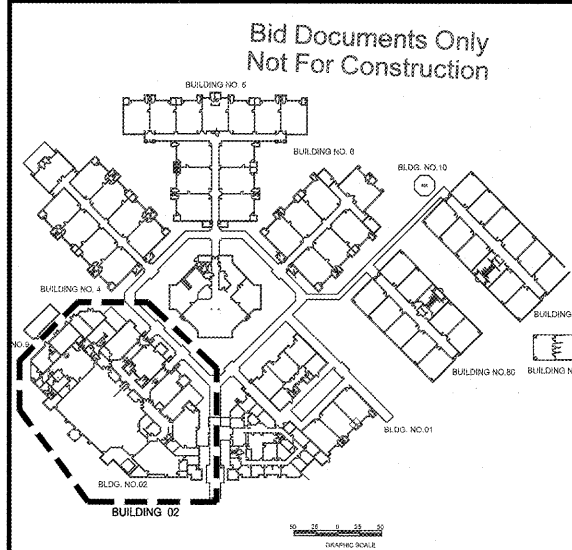

CRAN ATLANTIS ENGINEERING, INC.
 CONSULTING ENGINEERS & ARCHITECTS
 210 SW 14TH AVENUE
 GAINESVILLE, FLORIDA 32601
 TEL: (352) 371-2011
 FAX: (352) 371-2011
 AA 20001808 EB - 27488
 COPYRIGHT 2017 CRAN ATLANTIS ENGINEERING, INC.

REVISIONS

NO.	DATE	DESCRIPTION
1	02/23/18	BUILDING DEPARTMENT COMMENTS

SEA CASTLE ELEMENTARY SCHOOL
 9000 MIRAMAR BOULEVARD
 MIRAMAR, FLORIDA 33025



THE SCHOOL BOARD OF BROWARD COUNTY

PARTIAL DEMOLITION ELECTRICAL FLOOR PLAN
 BUILDING 02

JOB PHASE: 100% SUBMITTAL
 SBBC PROJECT: P-001632
 DATE: 12.13.16
 SCALE: AS SHOWN
 DRAWN BY: HA
 CHECKED BY: E.H.
 CAE PROJECT NO. 2015.55

FL LIC #SH15004047
 ERIC J. HAMMOND
 PROFESSIONAL ENGINEER
 SEAL

DRAWING No.

DE-102