

HAMMOND & ASSOCIATES, INC.
 CONSULTING ENGINEERS
 7348 NW 5TH STREET
 PLANTATION, FLORIDA 33317
 TEL: (954) 327-7111 FAX (954) 327-7154
 ERIC J. HAMMOND P.E.
 MECHANICAL / ELECTRICAL ENGINEER
 P.E. #29048
 EB 5315



- DEMOLITION KEY NOTES:**
- EXISTING AIR HANDLING UNIT TO BE REMOVED AND REPLACED WITH NEW. REMOVE EXISTING DISCONNECT ALONG WITH CONDUIT AND WIRING TO UNIT BEING REPLACED.
 - EXISTING FAN COIL UNIT AND DUCT HEATER TO BE REMOVED AND REPLACED WITH NEW. REMOVE EXISTING DISCONNECT ALONG WITH CONDUIT AND WIRING TO UNIT BEING REPLACED.
 - EXISTING HVAC CIRCULATING PUMP TO BE REMOVED AND REPLACED WITH NEW. REMOVE EXISTING DISCONNECT ALONG WITH CONDUIT AND WIRING TO UNIT BEING REPLACED.
 - EXISTING FAN COIL UNIT TO BE REMOVED AND REPLACED WITH NEW. REMOVE EXISTING DISCONNECT ALONG WITH CONDUIT AND WIRING TO UNIT BEING REPLACED.
 - EXISTING CHILLER TO REMAIN.
 - EXISTING RTU LOCATED ON ROOF TO BE REMOVED AND REPLACED WITH NEW. REMOVE EXISTING DISCONNECT ALONG WITH CONDUIT AND WIRING TO UNIT BEING REPLACED.
 - EXISTING EXTERIOR CONDENSING UNIT TO BE REMOVED AND REPLACED WITH NEW. REMOVE EXISTING DISCONNECT ALONG WITH CONDUIT AND WIRING TO UNIT BEING REPLACED.
 - LOCATION OF EXISTING OUTLET TO REMAIN.
 - LOCATION OF EXISTING OUTLET TO BE REMOVED AND REPLACED WITH NEW.
 - EXISTING ROOFTOP EXHAUST FAN TO BE REMOVED AND REPLACED WITH NEW. REMOVE EXISTING DISCONNECT ALONG WITH CONDUIT AND WIRING TO UNIT BEING REPLACED.

- GENERAL NOTES:**
- REPLACE ALL EXISTING RECEPTACLES IN MECHANICAL ROOMS WITH NEW GFCI RECEPTACLES.
 - IN ALL MECHANICAL ROOMS RECEIVING NEW AIR HANDLING UNITS, RELOCATE EXISTING LIGHTING IN ORDER TO PROVIDE ADEQUATE LIGHTING FOR WORKING ON THE ELECTRICAL EQUIPMENT. COMPLY WITH NEC 110.26(D).

RECEIVED
 MAR 06 2018
 BUILDING DEPARTMENT
 BCPS

Bid Documents Only
 Not For Construction

Order Plans @ WWW.LDILine.com

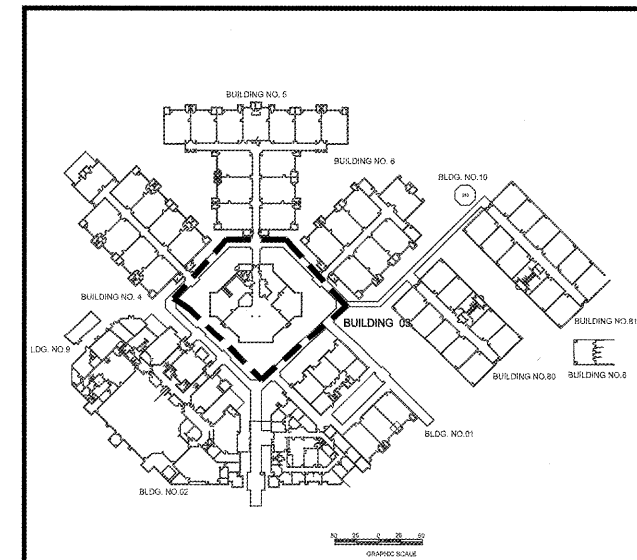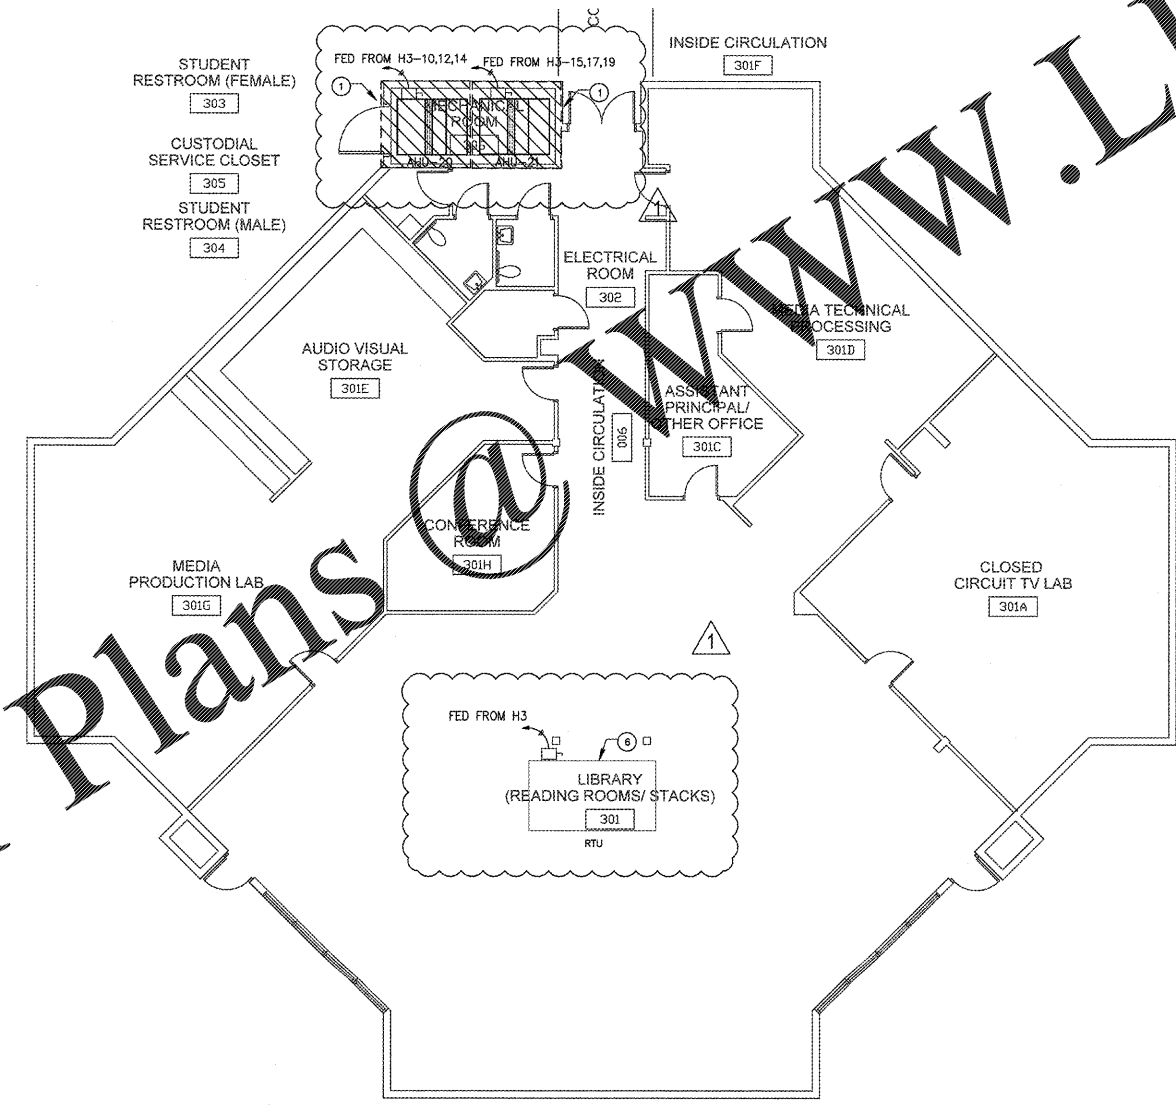

CRAIN ATLANTIS
 ENGINEERING, INC.
 CONSULTING ENGINEERS & ARCHITECTS
 2500 N. UNIVERSITY AVENUE, SUITE 1041
 BOCA RATON, FLORIDA 33431
 TEL: (561) 971-5111
 FAX: (561) 971-5111
 P.E. #2001859
 EB - 2748

REVISIONS	BUILDING DEPARTMENT COMMENTS
A	02/23/18

SEA CASTLE
 ELEMENTARY SCHOOL
 9600 MIRAMAR BOULEVARD
 MIRAMAR, FLORIDA 33025



THE SCHOOL BOARD OF BROWARD COUNTY

PARTIAL DEMOLITION
 ELECTRICAL FLOOR PLAN
 BUILDING 03

JOB PHASE: 100% SUBMITTAL
 SBBC PROJECT: P-001632
 DATE: 12.13.16
 SCALE: AS SHOWN
 DRAWN BY: HA
 CHECKED BY: EH
 CAE PROJECT NO. 2015.55

FL. LICENSE # 39048
 ERIC J. HAMMOND
 PROFESSIONAL ENGINEER
 STATE OF FLORIDA
 MECHANICAL/ELECTRICAL ENGINEER
 SEAL

DRAWING No.

DE-103

THIS IS A VIOLATION OF THE LAW FOR ANY PERSON, UNLESS ACTING UNDER THE DIRECTION OF A LICENSED ARCHITECT, TO ALTER THESE PLANS AND SPECIFICATIONS. THIS DOCUMENT CONTAINS PROPERTY INFORMATION AND SHALL NOT BE USED OR REPRODUCED, IN WHOLE OR IN PART, WITHOUT THE PRIOR WRITTEN CONSENT OF CRAIN ATLANTIS ENGINEERING, INC. COPYRIGHT 2014 CRAIN ATLANTIS ENGINEERING, INC.