
 


HAMMOND & ASSOCIATES, INC.  
 CONSULTING ENGINEERS  
 7348 NW 5TH STREET  
 PLANTATION, FLORIDA 33317  
 TEL: (954) 327-7111 FAX (954) 327-7154  
 ERIC J. HAMMOND P.E.  
 MECHANICAL / ELECTRICAL ENGINEER  
 P.E. #39048  
 EB 5315

CRAIN ATLANTIS  
 ENGINEERING, INC.  
 CONSULTING ENGINEERS & ARCHITECTS  
 210 SW 14TH AVENUE  
 DEERFIELD BEACH, FLORIDA 33441  
 AA 35071655 EB - 27485

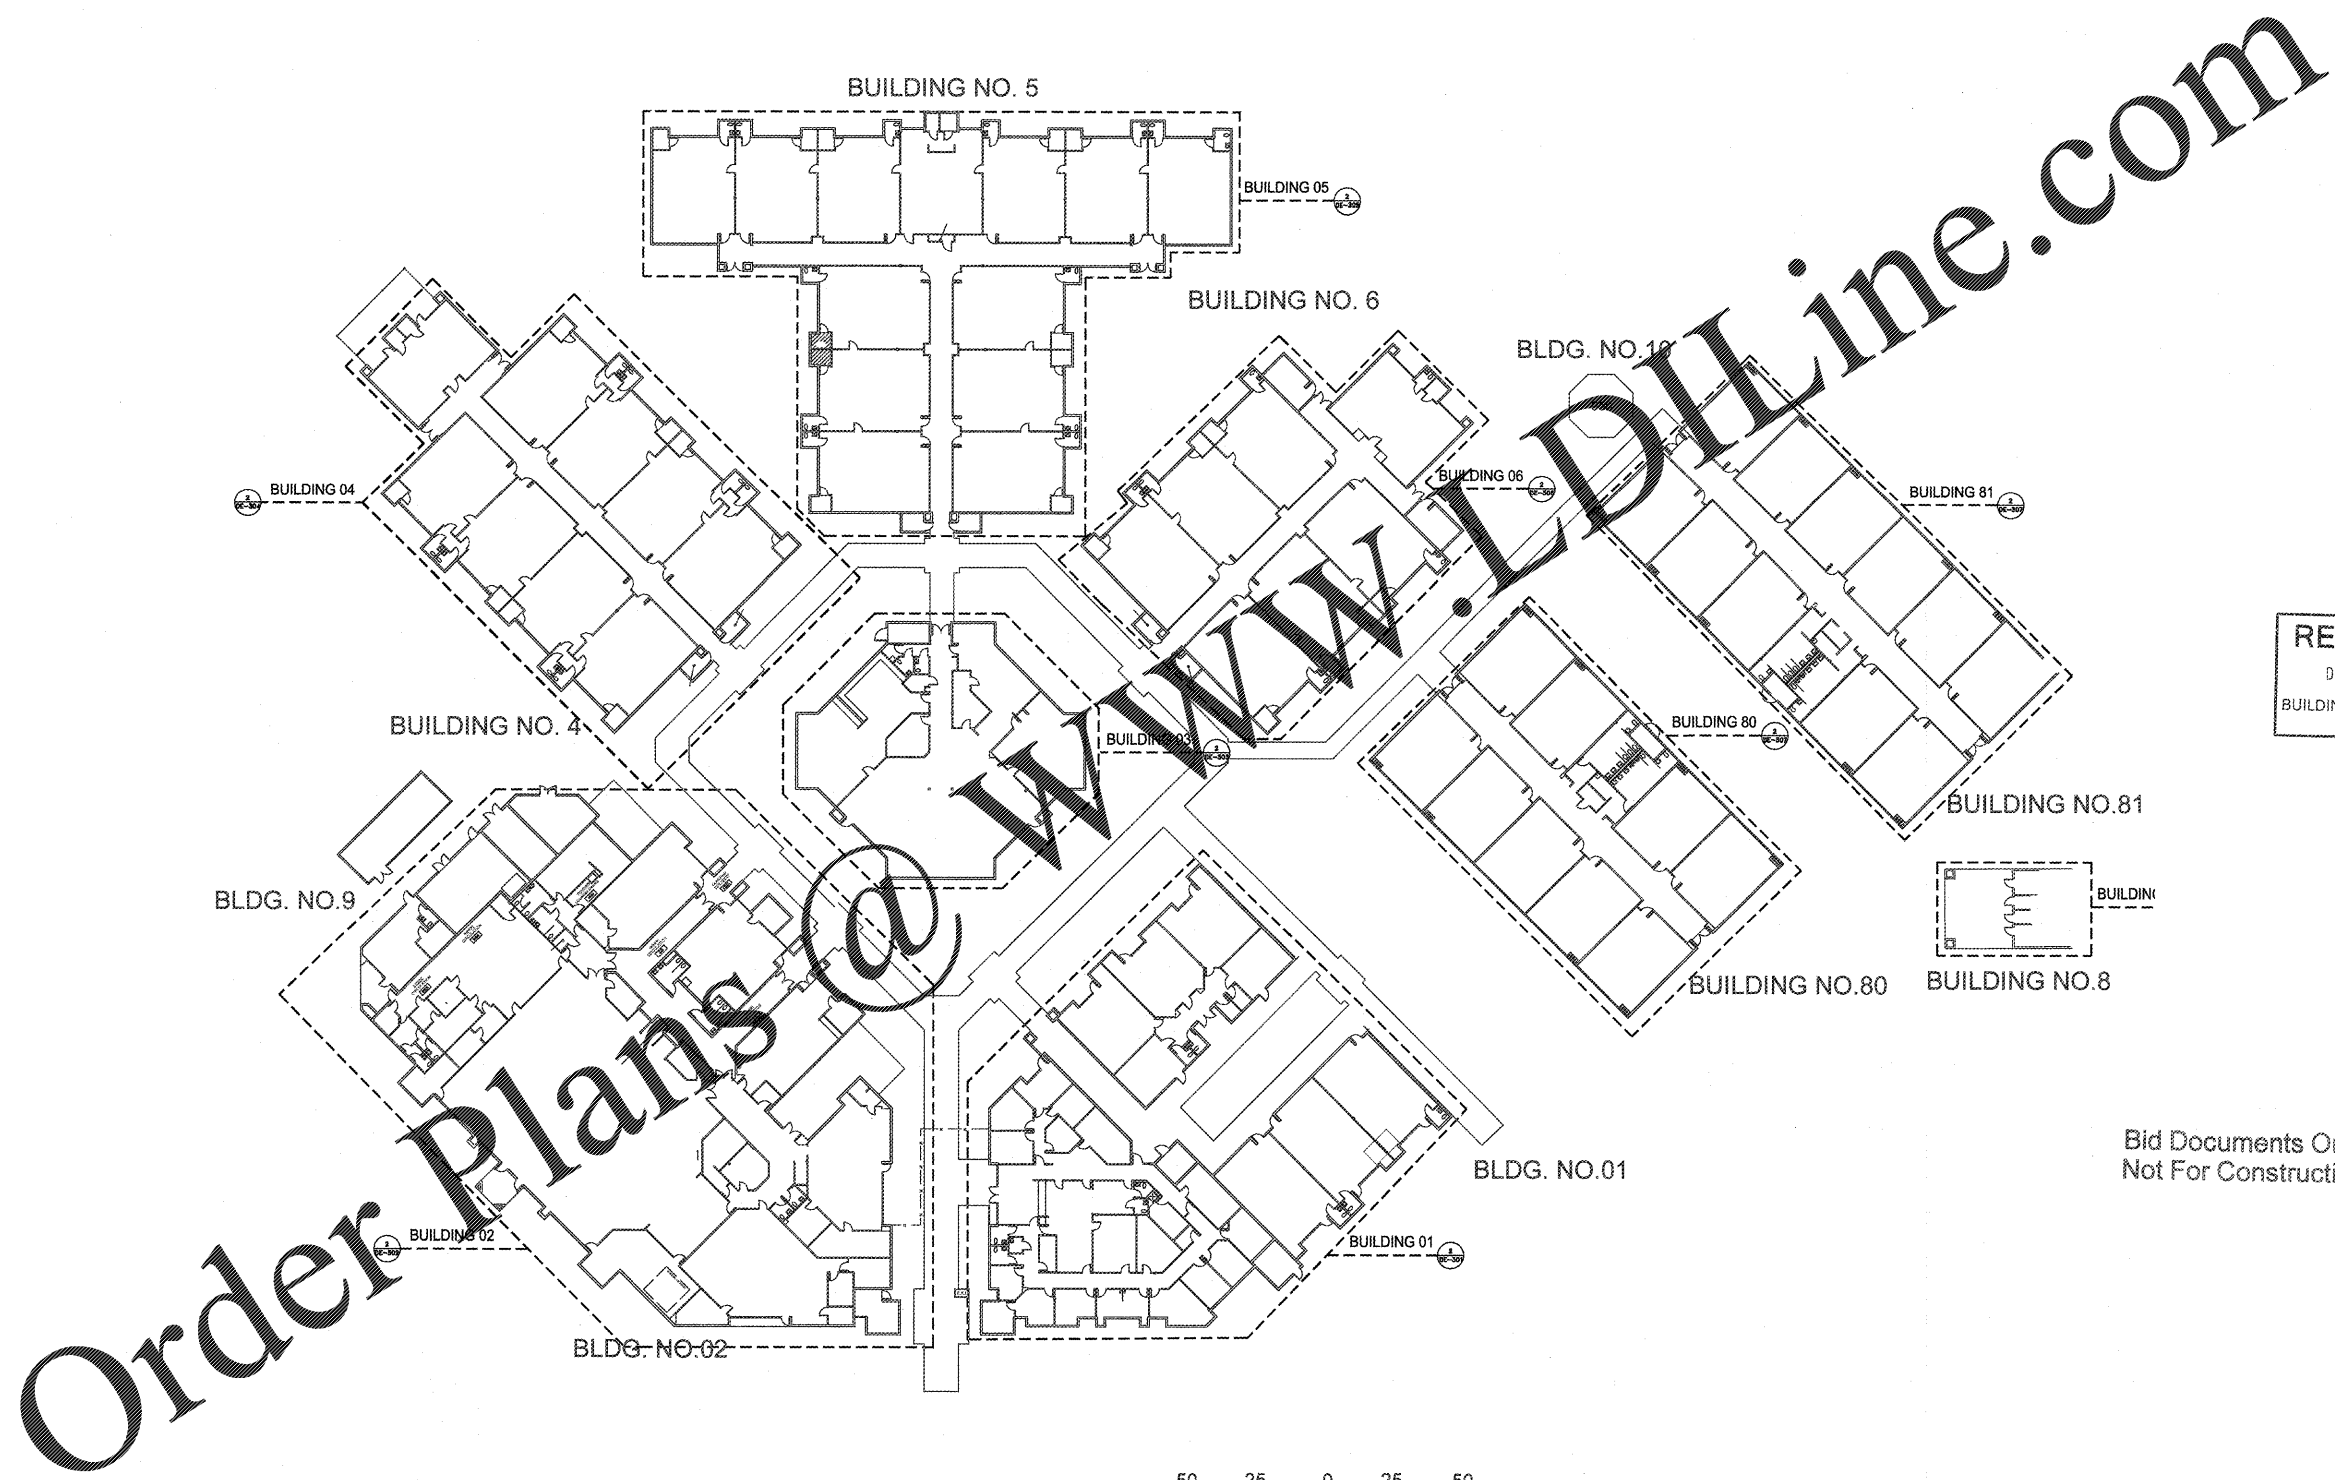

RECEIVED  
 DEC 19 2017  
 BUILDING DEPARTMENT  
 BCPS



Order Plans @

REVISIONS

SEA CASTLE  
 ELEMENTARY SCHOOL  
 9600 MIRAMAR BOULEVARD  
 MIRAMAR, FLORIDA 33025

THE SCHOOL BOARD OF BROWARD COUNTY

OVERALL DEMOLITION  
 FIRE ALARM FLOOR PLAN

JOB PHASE: 100% SUBMITTAL  
 888C PROJECT: P.001632  
 DATE: 12.13.16  
 SCALE: AS SHOWN  
 DRAWN BY: HA  
 CHECKED BY: E.H.  
 CAE PROJECT NO. 2015.55

FL. LICENSE PE# 39048

ERIC HAMMOND  
 PROFESSIONAL ENGINEER  
 SEAL

DRAWING No.

DE-300

THIS IS A VIOLATION OF THE LAW FOR ANY PERSON, UNLESS ACTING UNDER THE DIRECTION OF A LICENSED ARCHITECT, TO ALTER THESE PLANS AND SPECIFICATIONS. THIS DOCUMENT CONTAINS PROPERTY INFORMATION AND SHALL NOT BE USED OR REPRODUCED, IN WHOLE OR IN PART, WITHOUT THE PRIOR WRITTEN CONSENT OF CRAIN ATLANTIS ENGINEERING, INC. COPYRIGHT 2014 CRAIN ATLANTIS ENGINEERING, INC.